









ROBERT R. JONES
AIA, ARCHITECT
CARMEL, CALIF.

JOB
4820

HARRISON LIBRARY
CARMEL CALIF.



SHEET
FSD
I

DATE 7/29/49

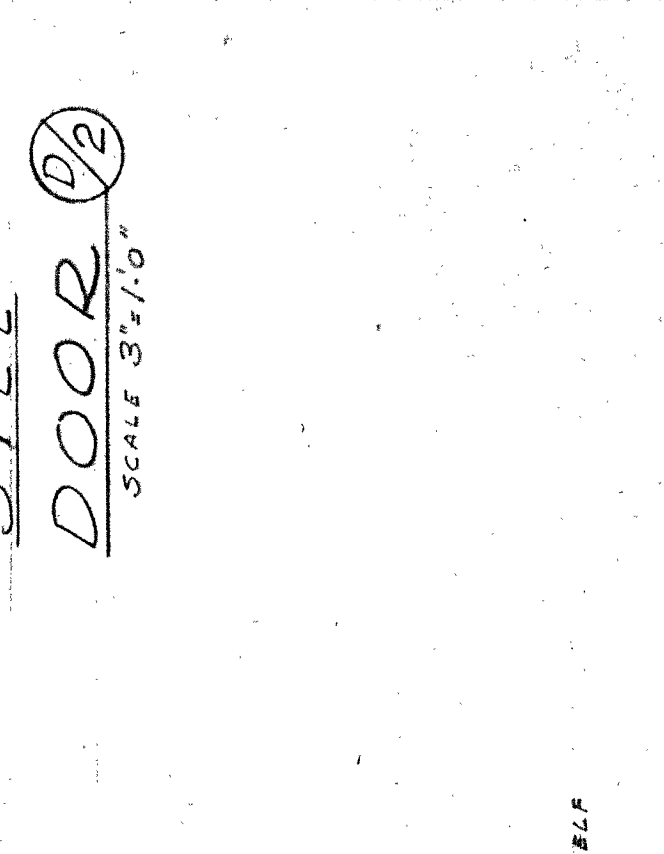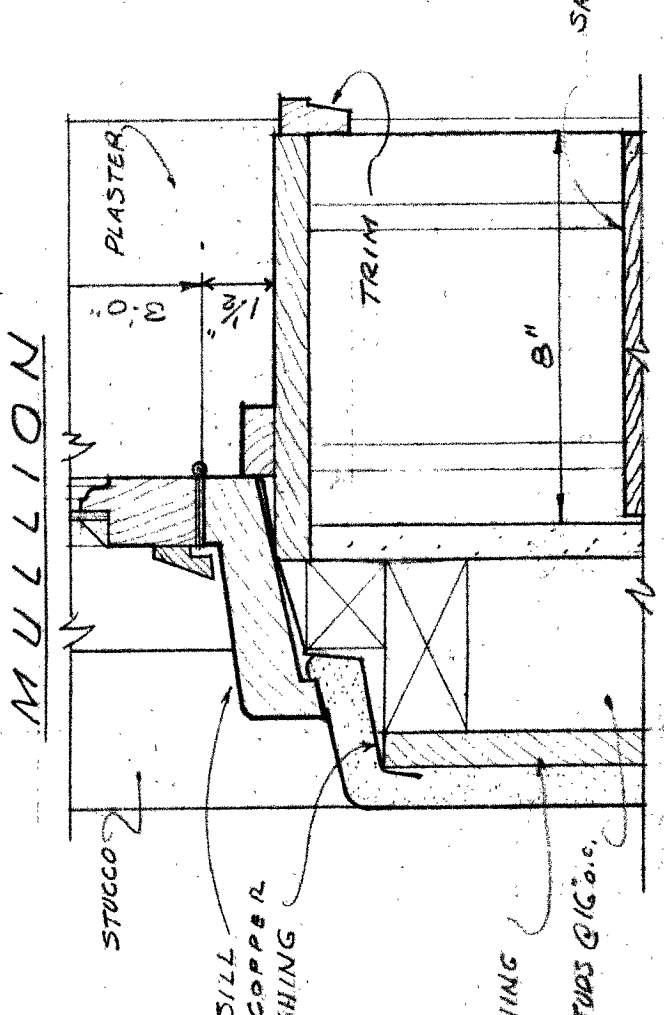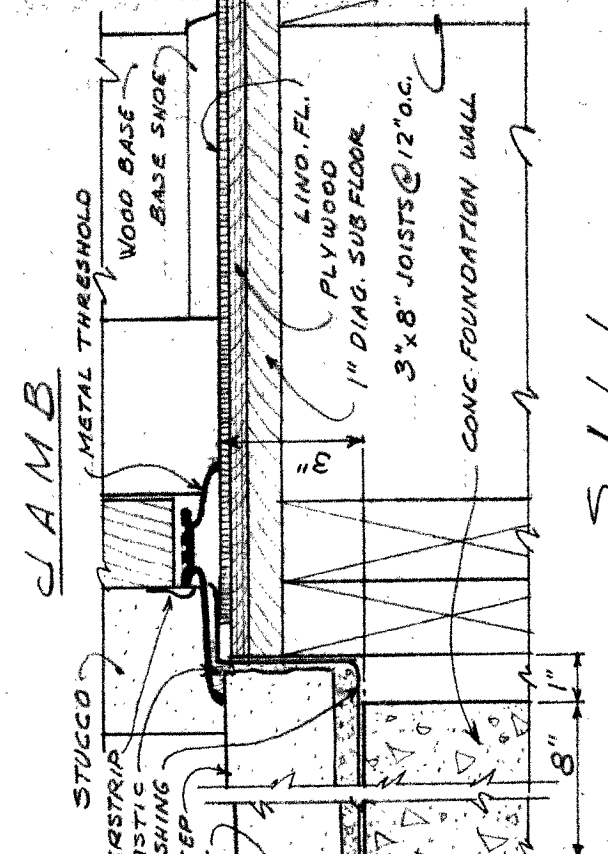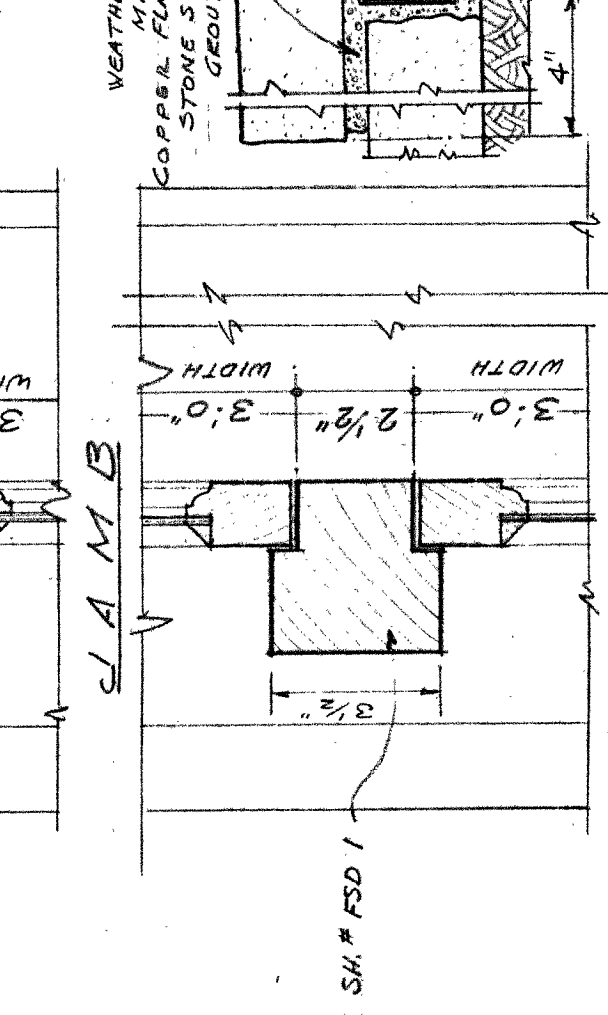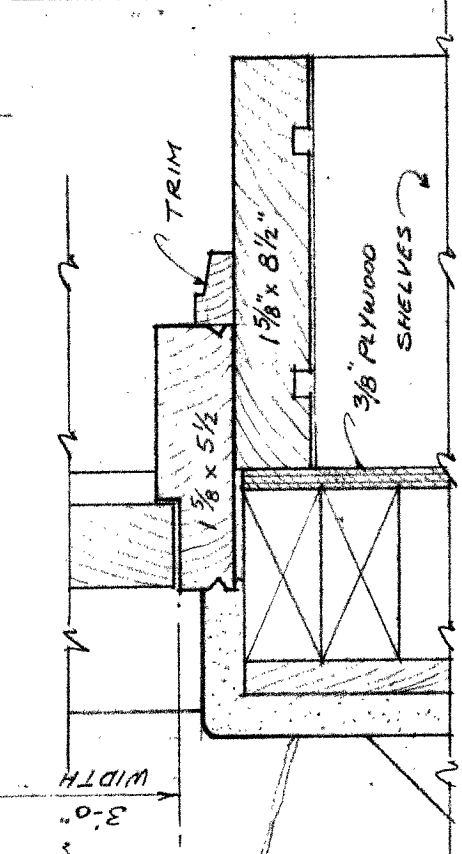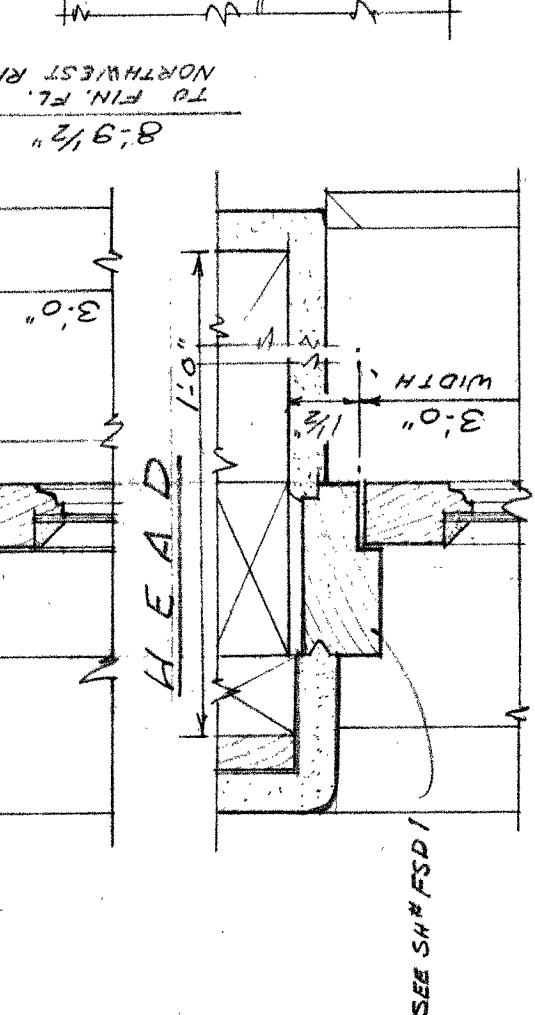
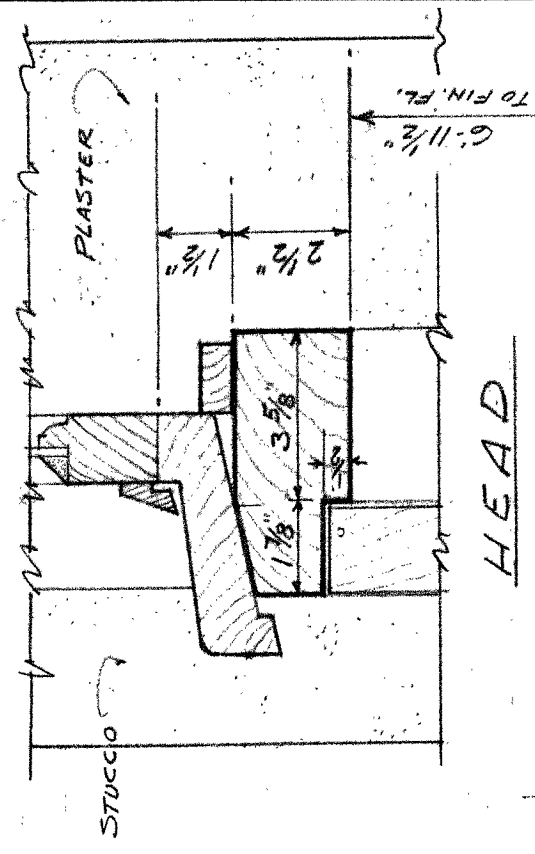
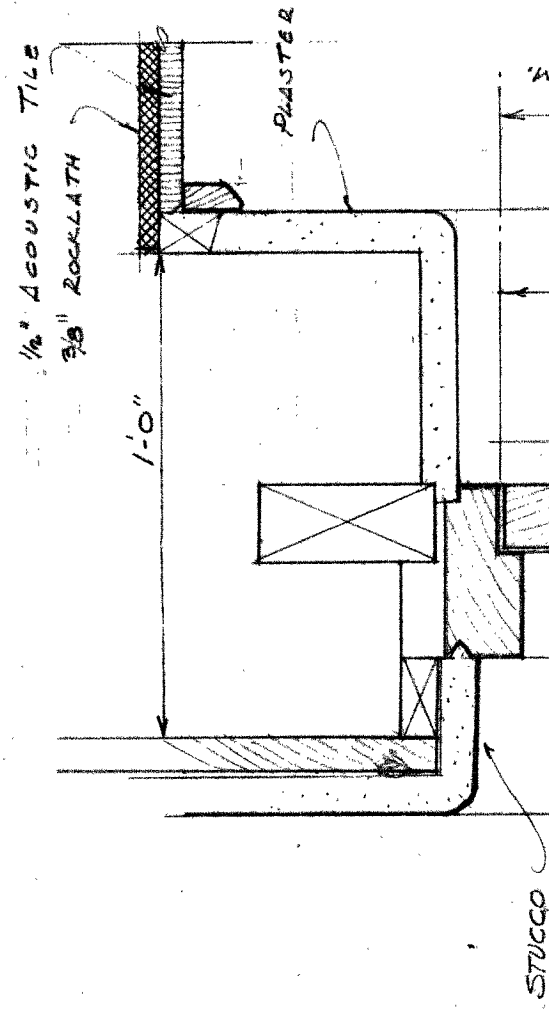


SILL
DOOR D/2
SCALE 3"=1'-0"

SILL
WINDOW B
SCALE 3"=1'-0"

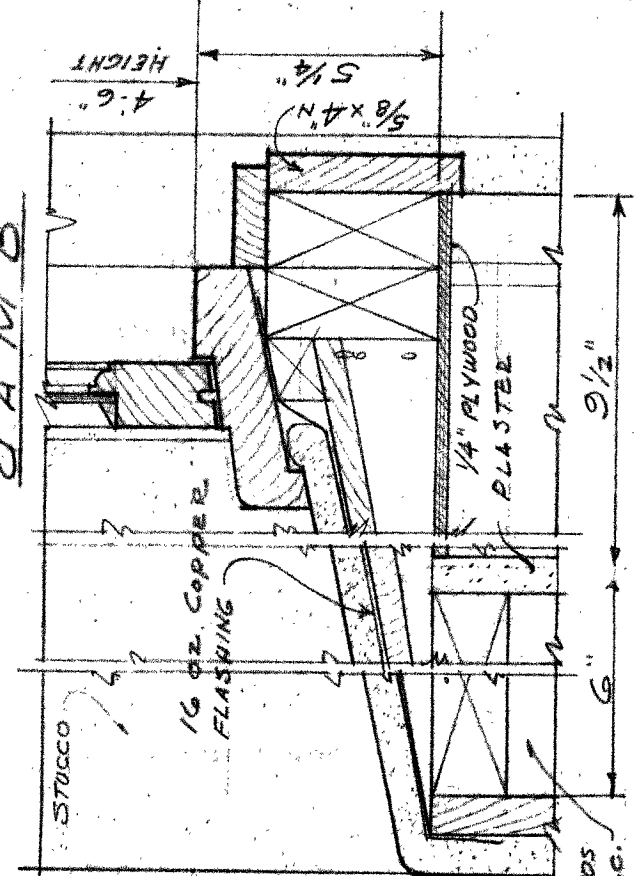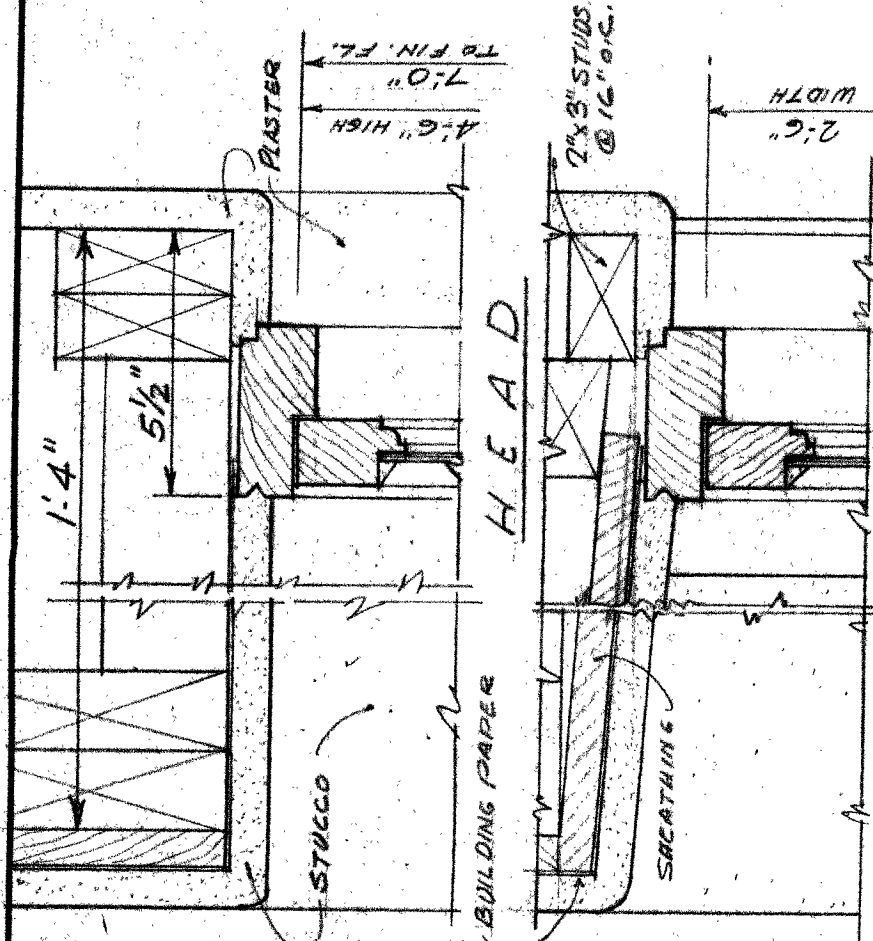

SILL
WINDOW C

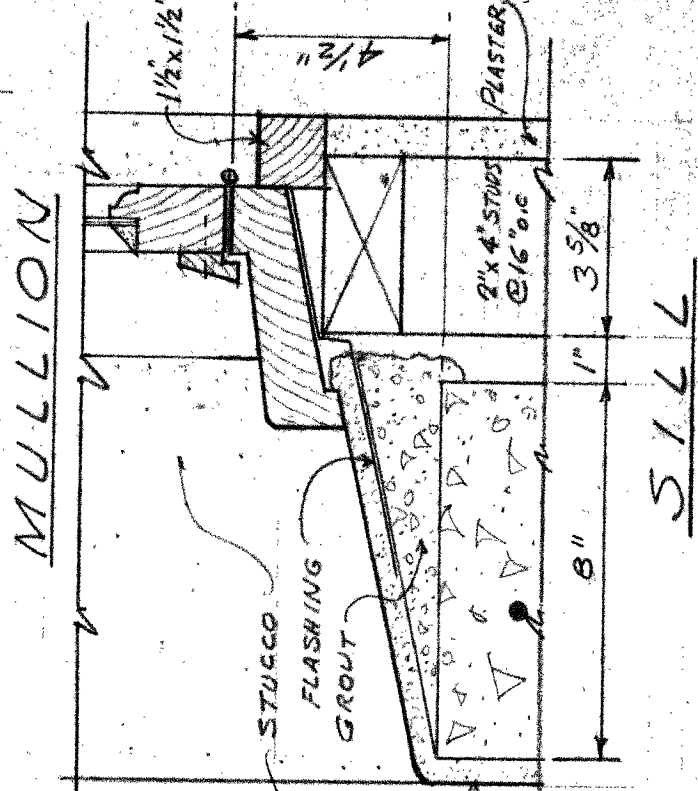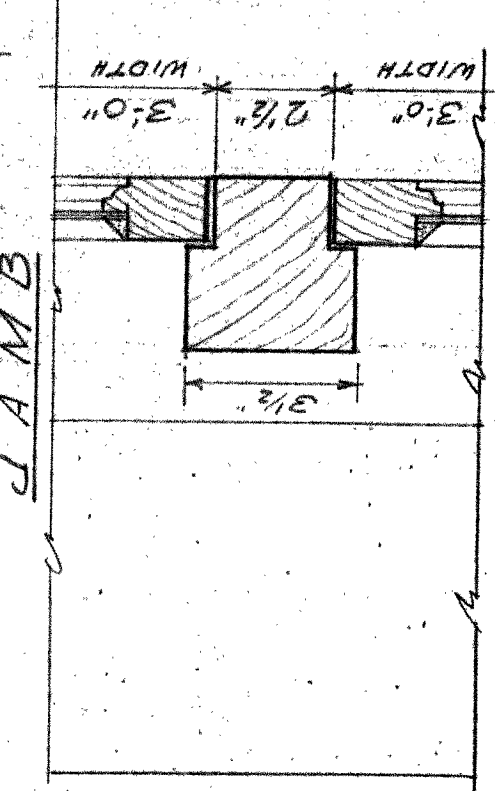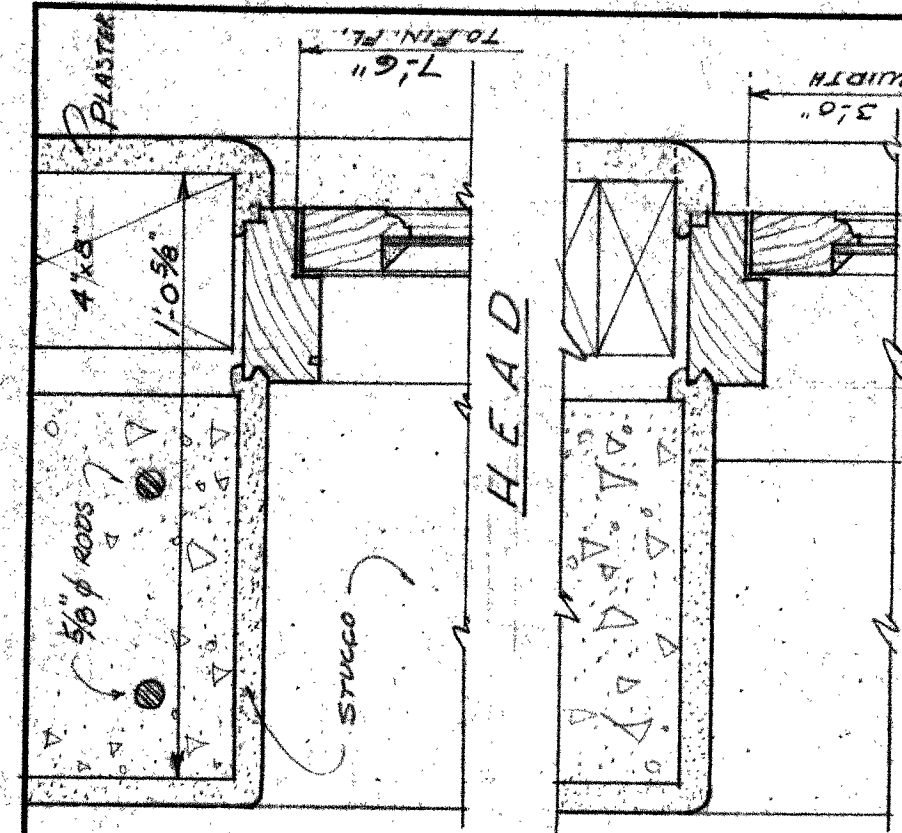

SILL
WINDOW D

SCALE 3/4"=1'-0"

ROBERT R. JONES
AIA. ARCHITECT
CARMEL, CALIF.

JOB
4820


HARRISON LIBRARY
CARMEL CALIF.

WINDOWS:
C & D


SHEET
D-3

DATE 7/29/49

NOTE: STONE WALL TO REMAIN.
 EXISTING FOOTING BELOW FIN
 AREA WAY SLAB

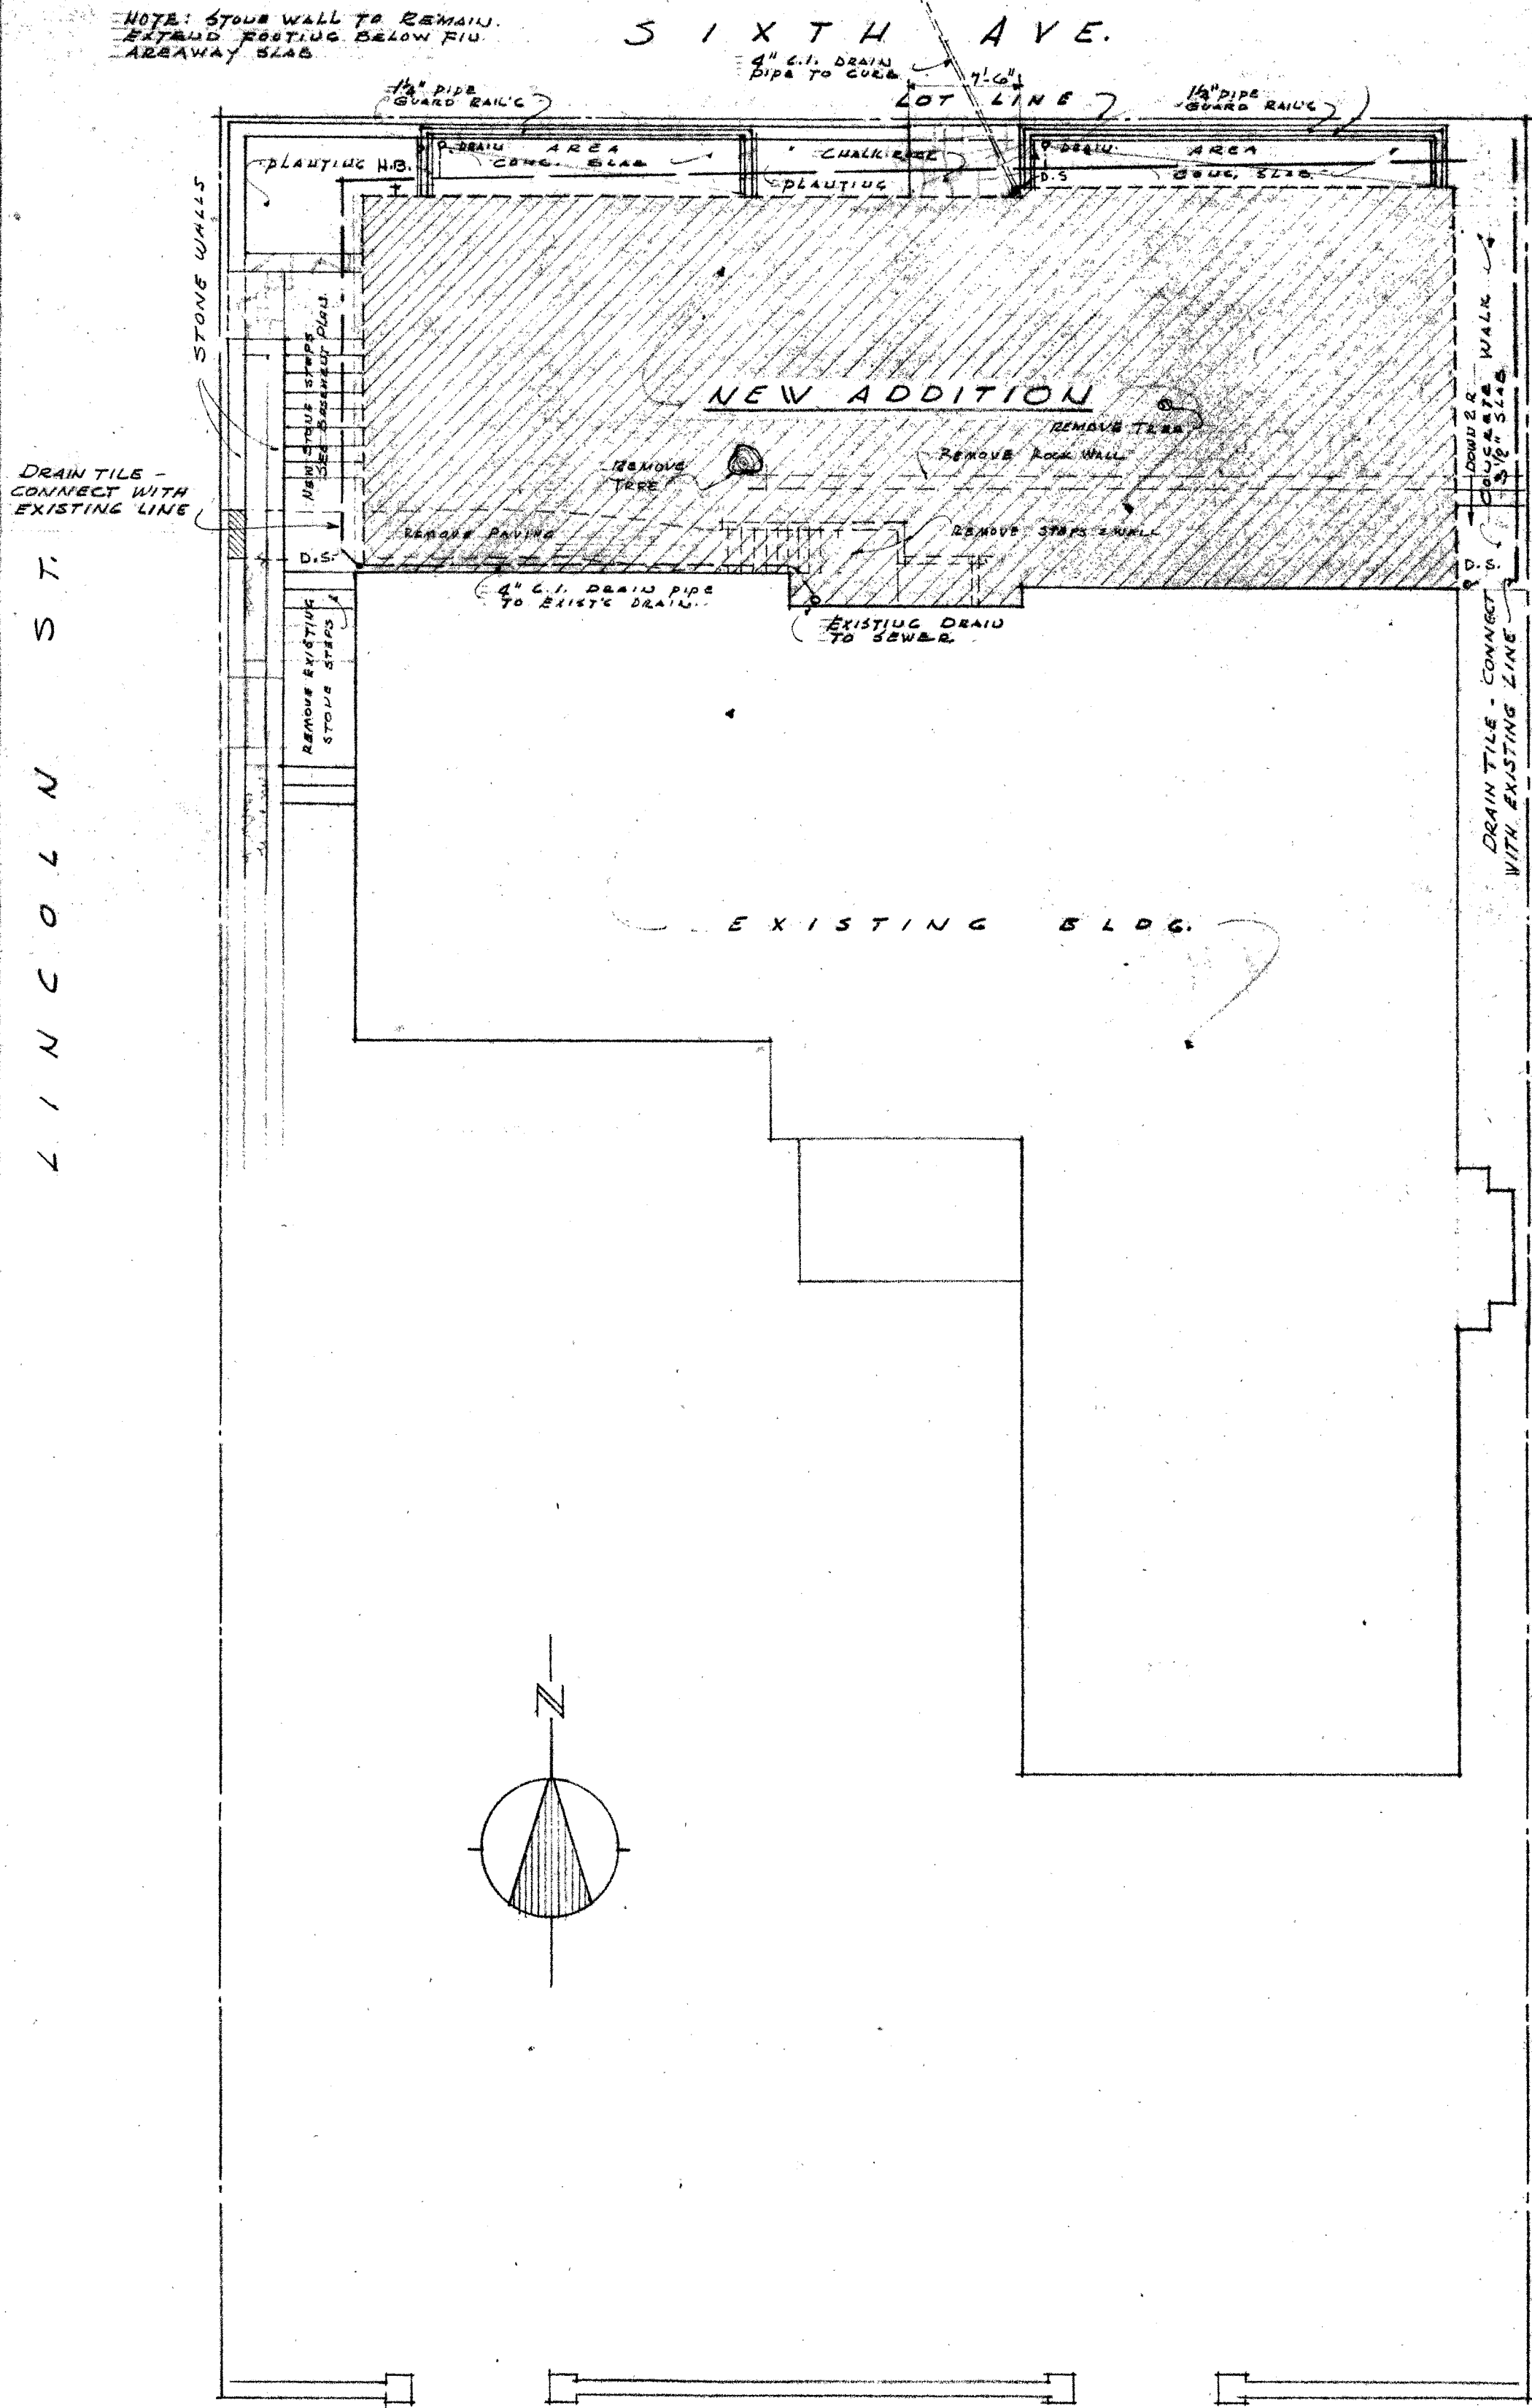

OCEAN AVE.
 PLOT PLAN
 SCALE 1/8" = 1'-0"

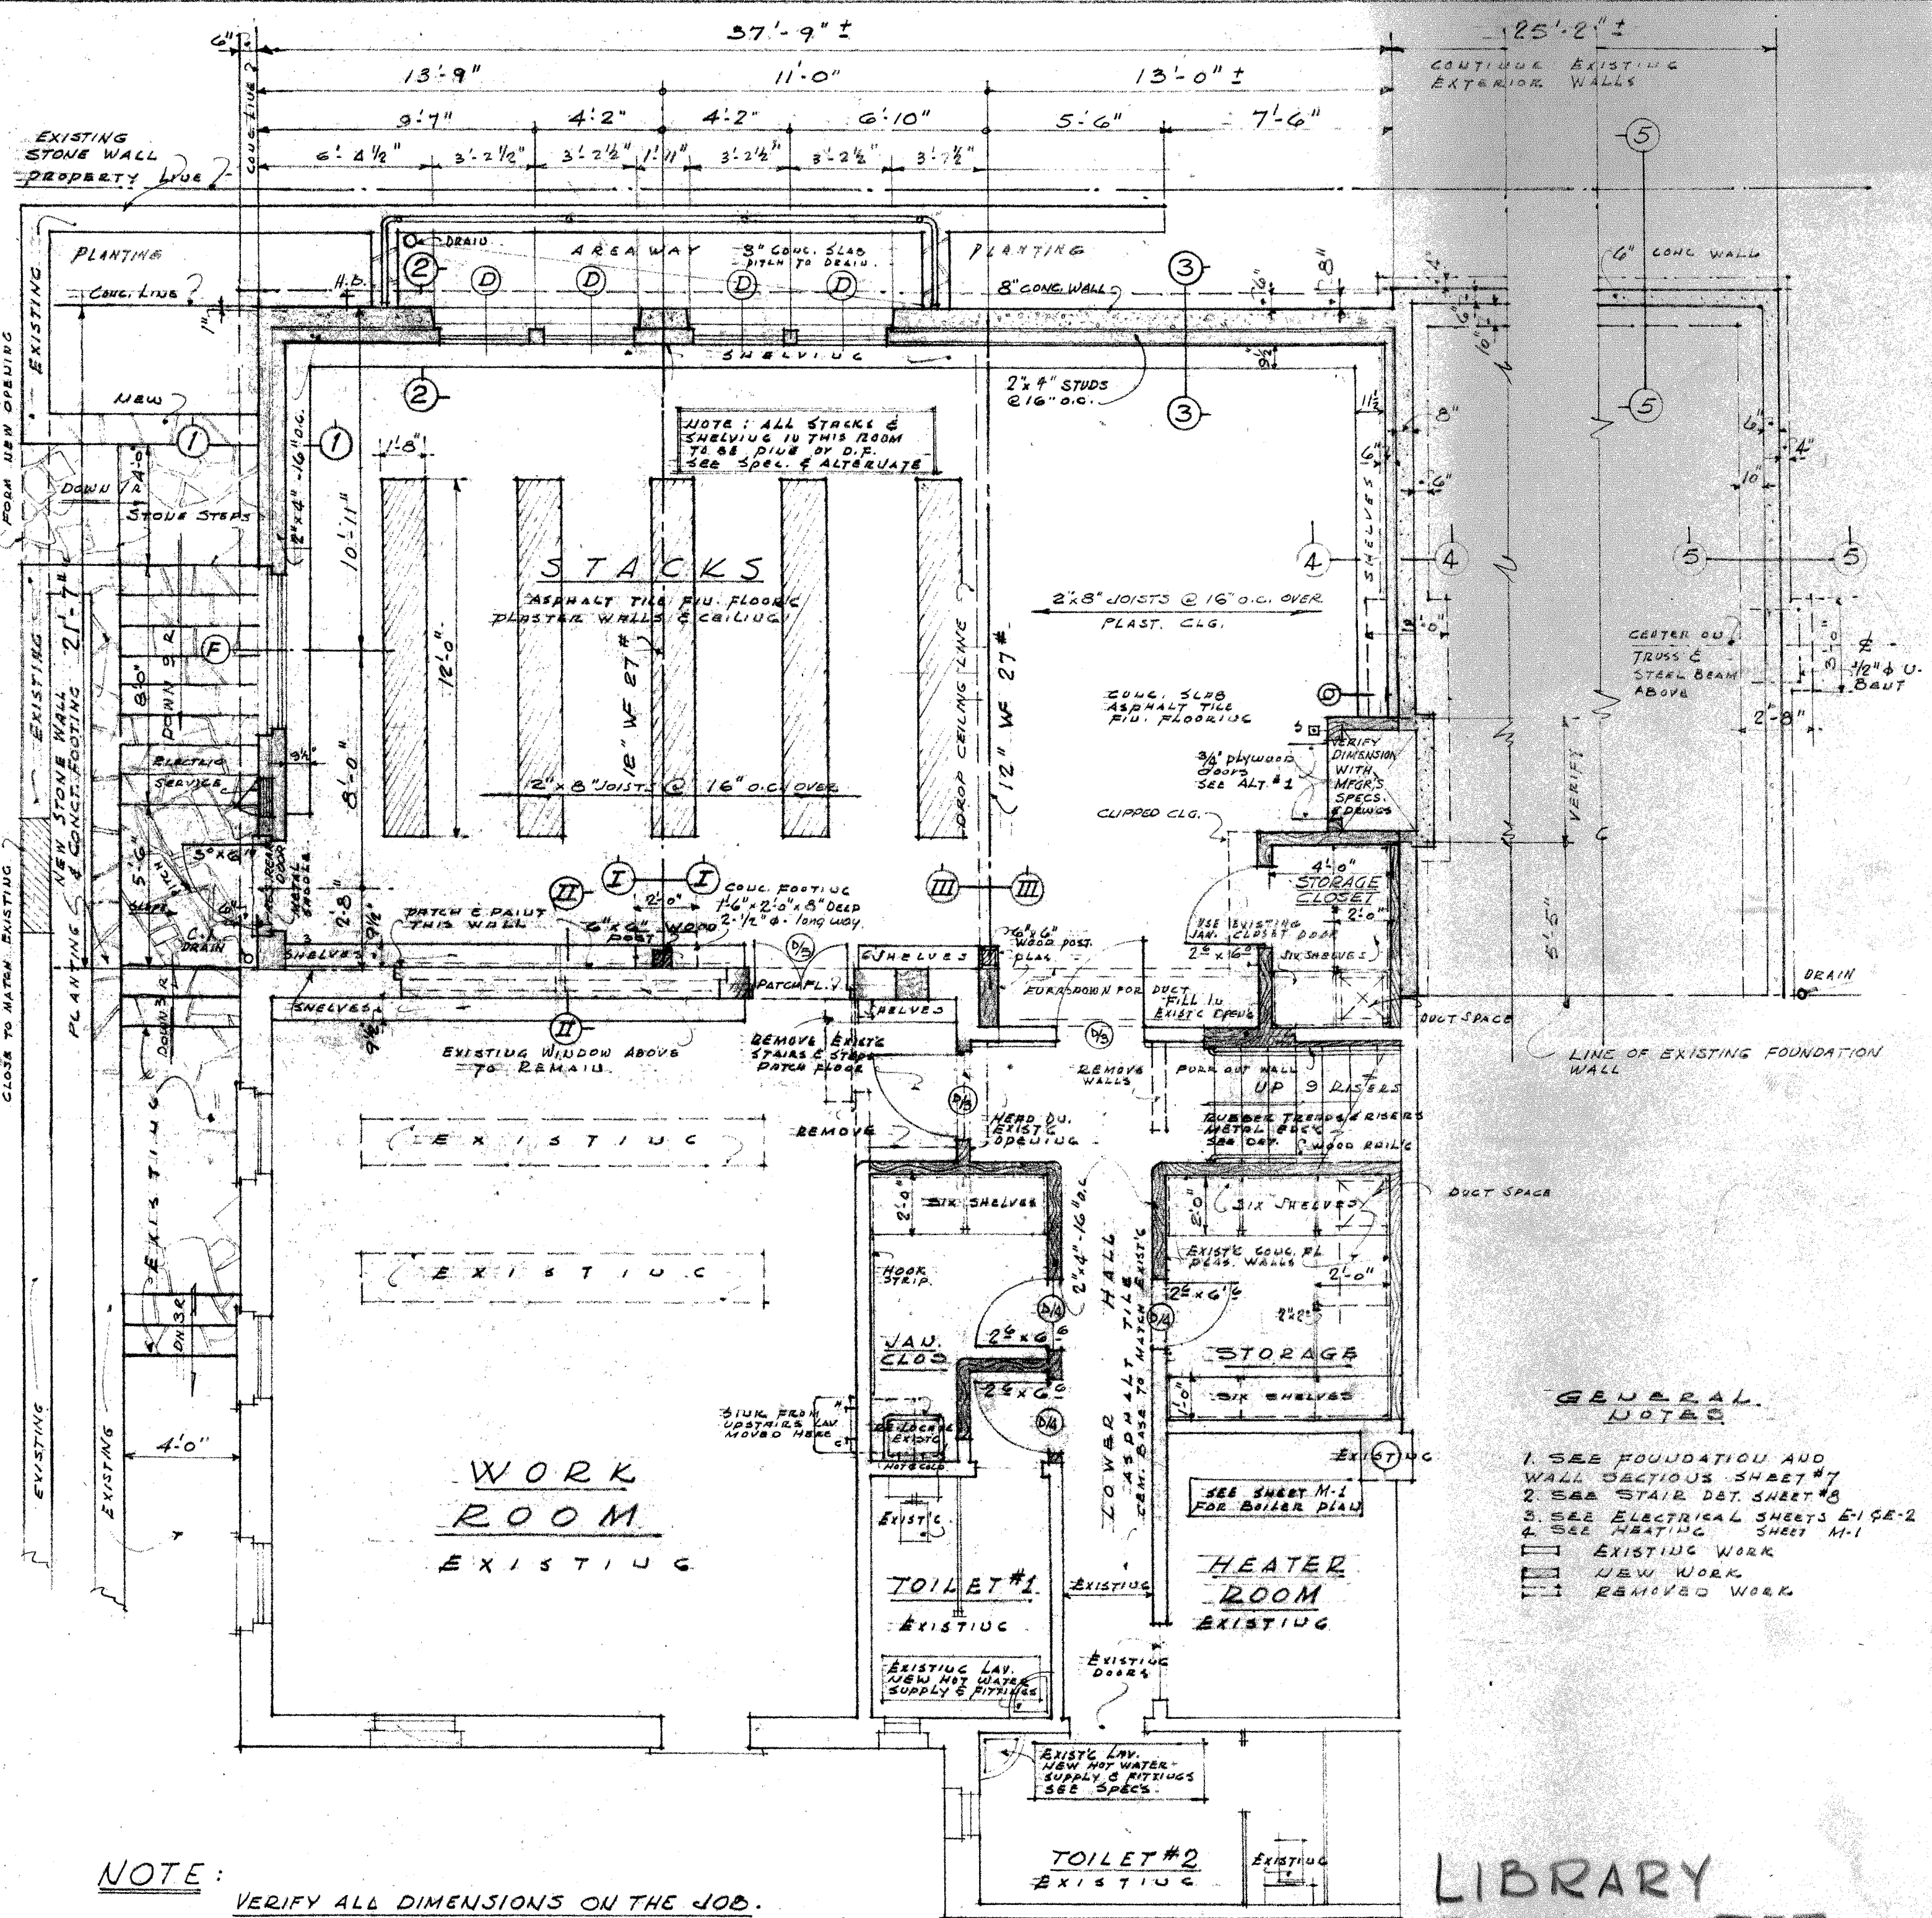

BASEMENT PLAN
 SCALE 1/4" = 1'-0"

LIBRARY BOARD SET

ALTERATIONS & ADDITIONS HARRISON MEMORIAL LIBRARY CARMEL, CALIF.	DWG. NO. 4820
ROBERT E. JONES, ARCHITECT BOX 107 - CARMEL, CALIFORNIA - 95008	DRAWN BY S.J.S.
PLOT PLAN - BASEMENT PLAN	DATE 7/22/49
	HTB
	1

Cammel Library

Lower Flon -

Assembly area

280

1530
902

Main Flon -

Upper Flon -

2712 ft

Other areas

1462

902

PP0

3244 ft

Group "C"
DIV. 2

24
400

14
400 400
460

23
400 100
400

16
36
522

100 | 3244 | 30
3000
244

46
22

410
460

522
1462

34
40

22
40 22
PP0 4
22
PP
502

170
186
1530

2712
3244
5556

Cammel Library

7 | 2712 | 388


21
61
52
52

① - 388


216
604 see survey

2' / 100 216
12' - mit. / 15' | 3244
30
24
15
94

mit
wet stamping required

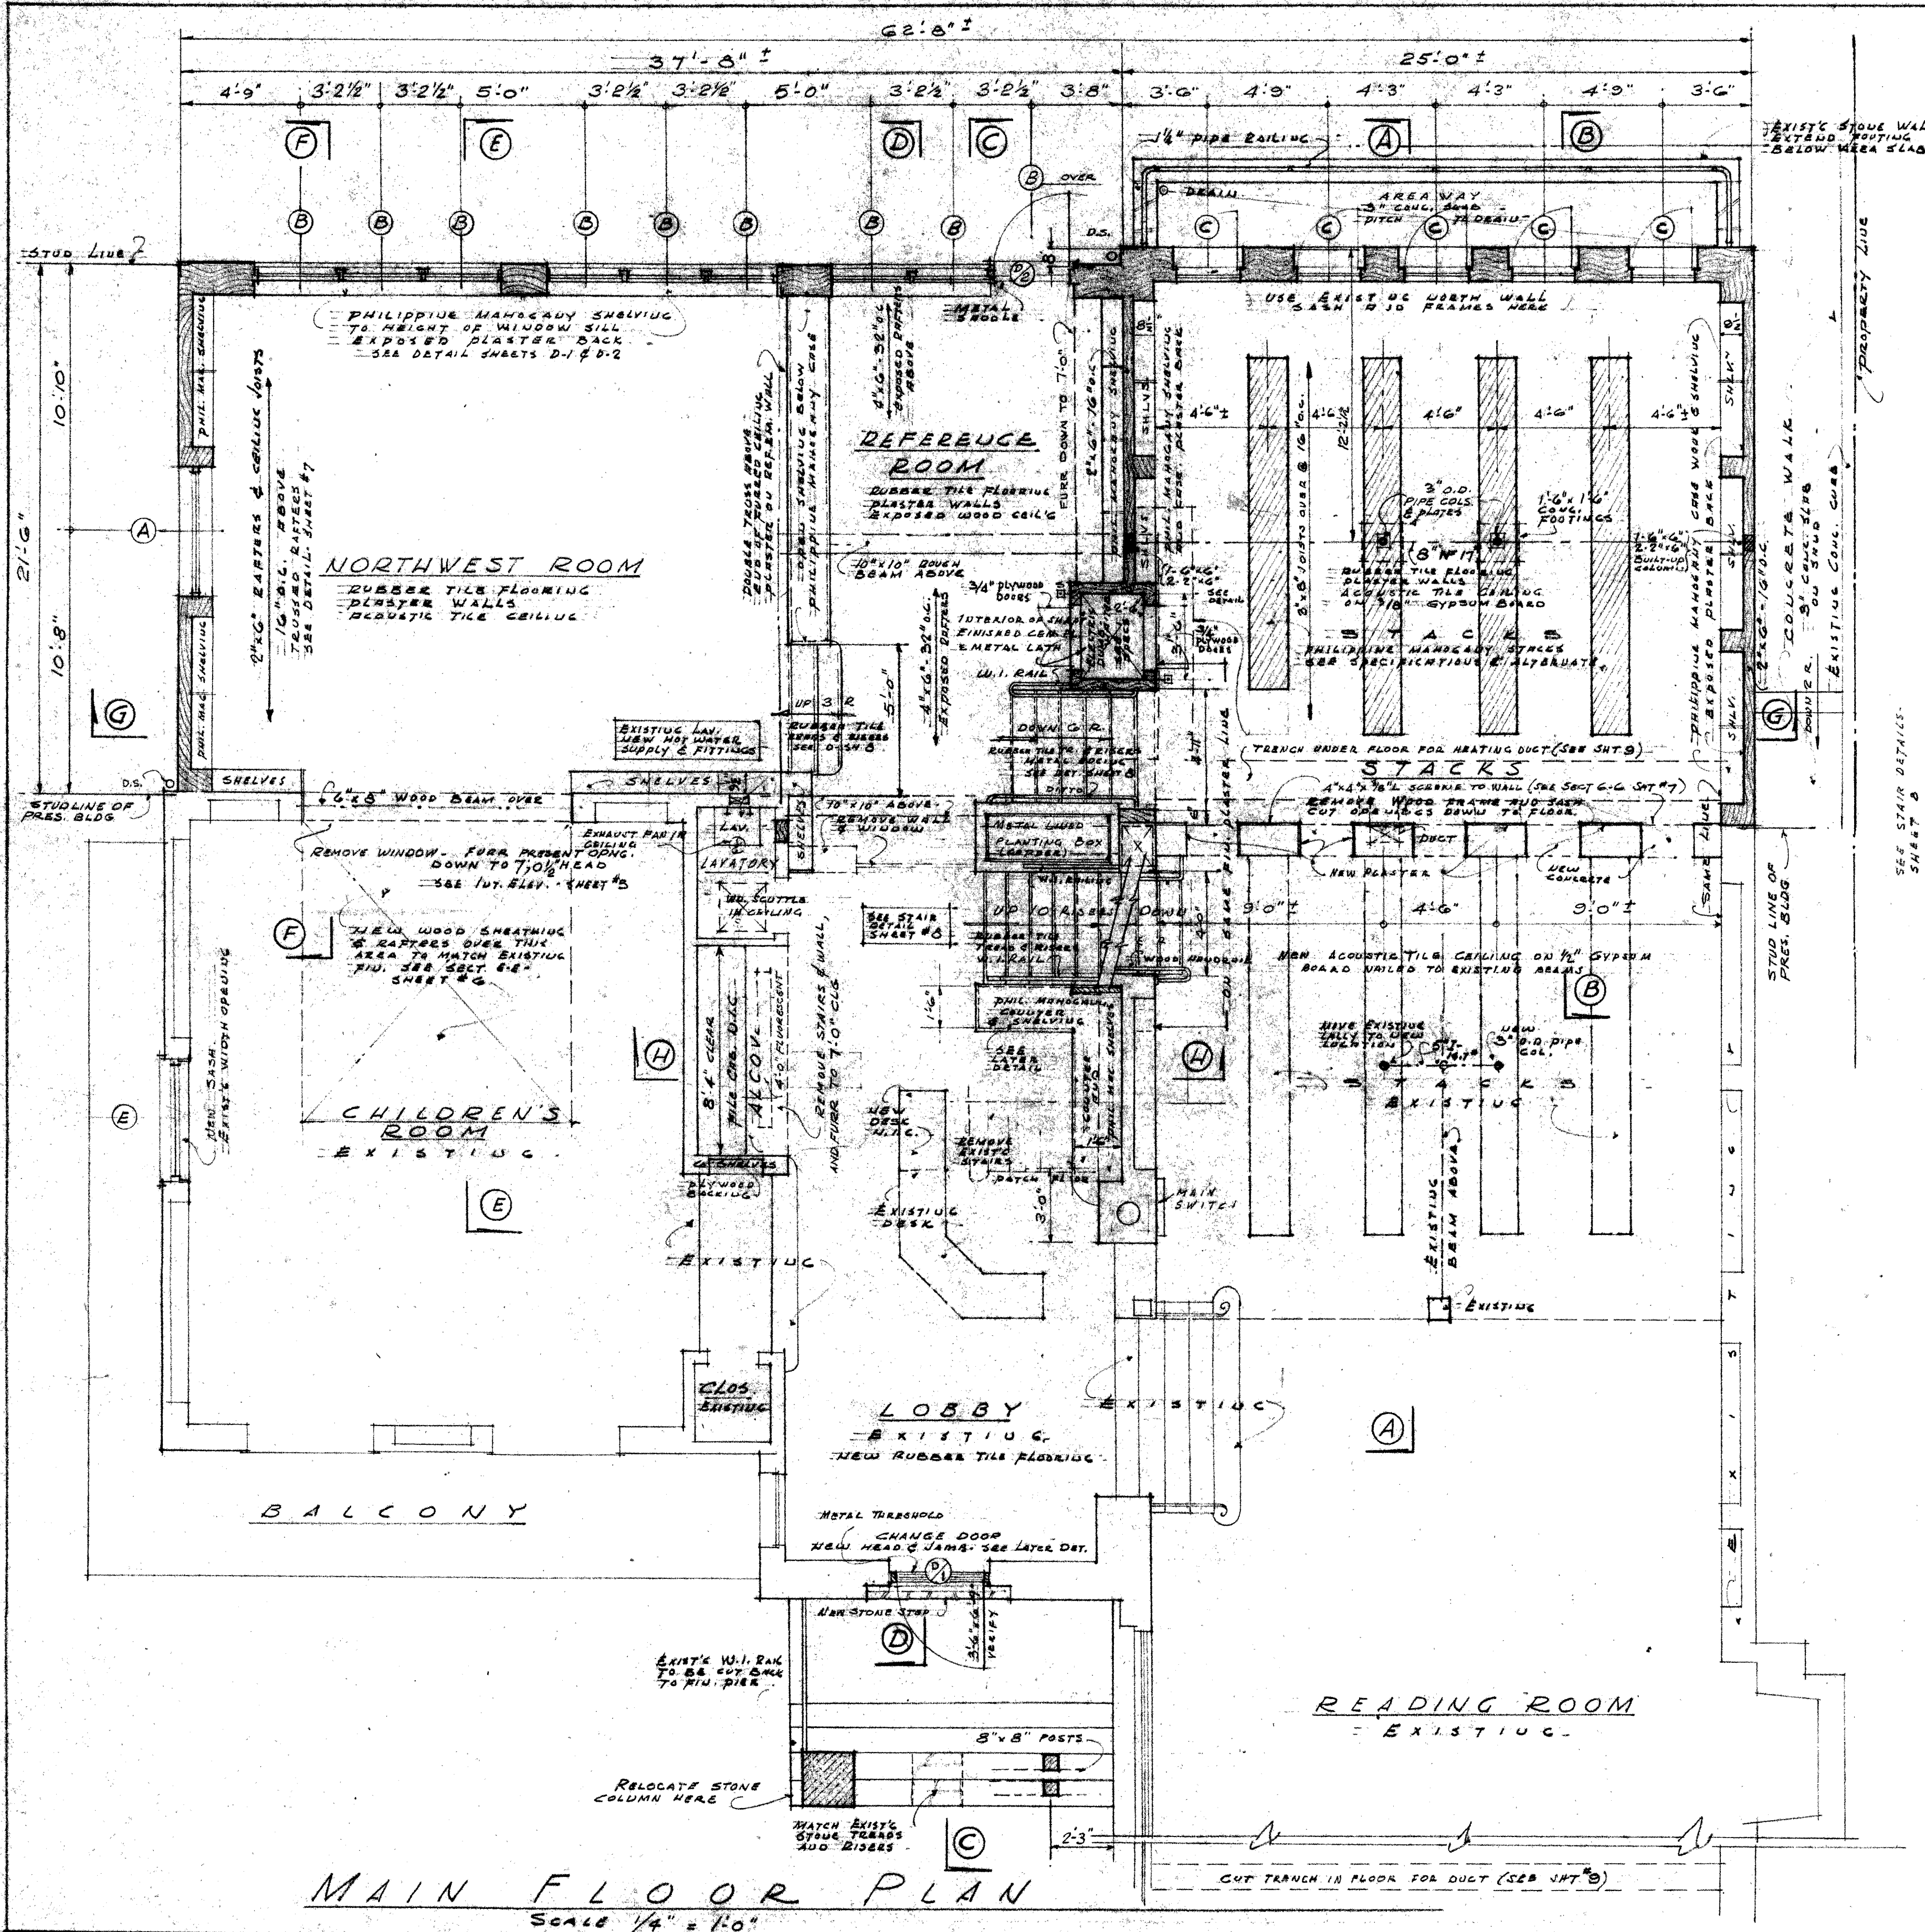


MAIN FLOOR PLAN
SCALE 1/4" = 1'-0"

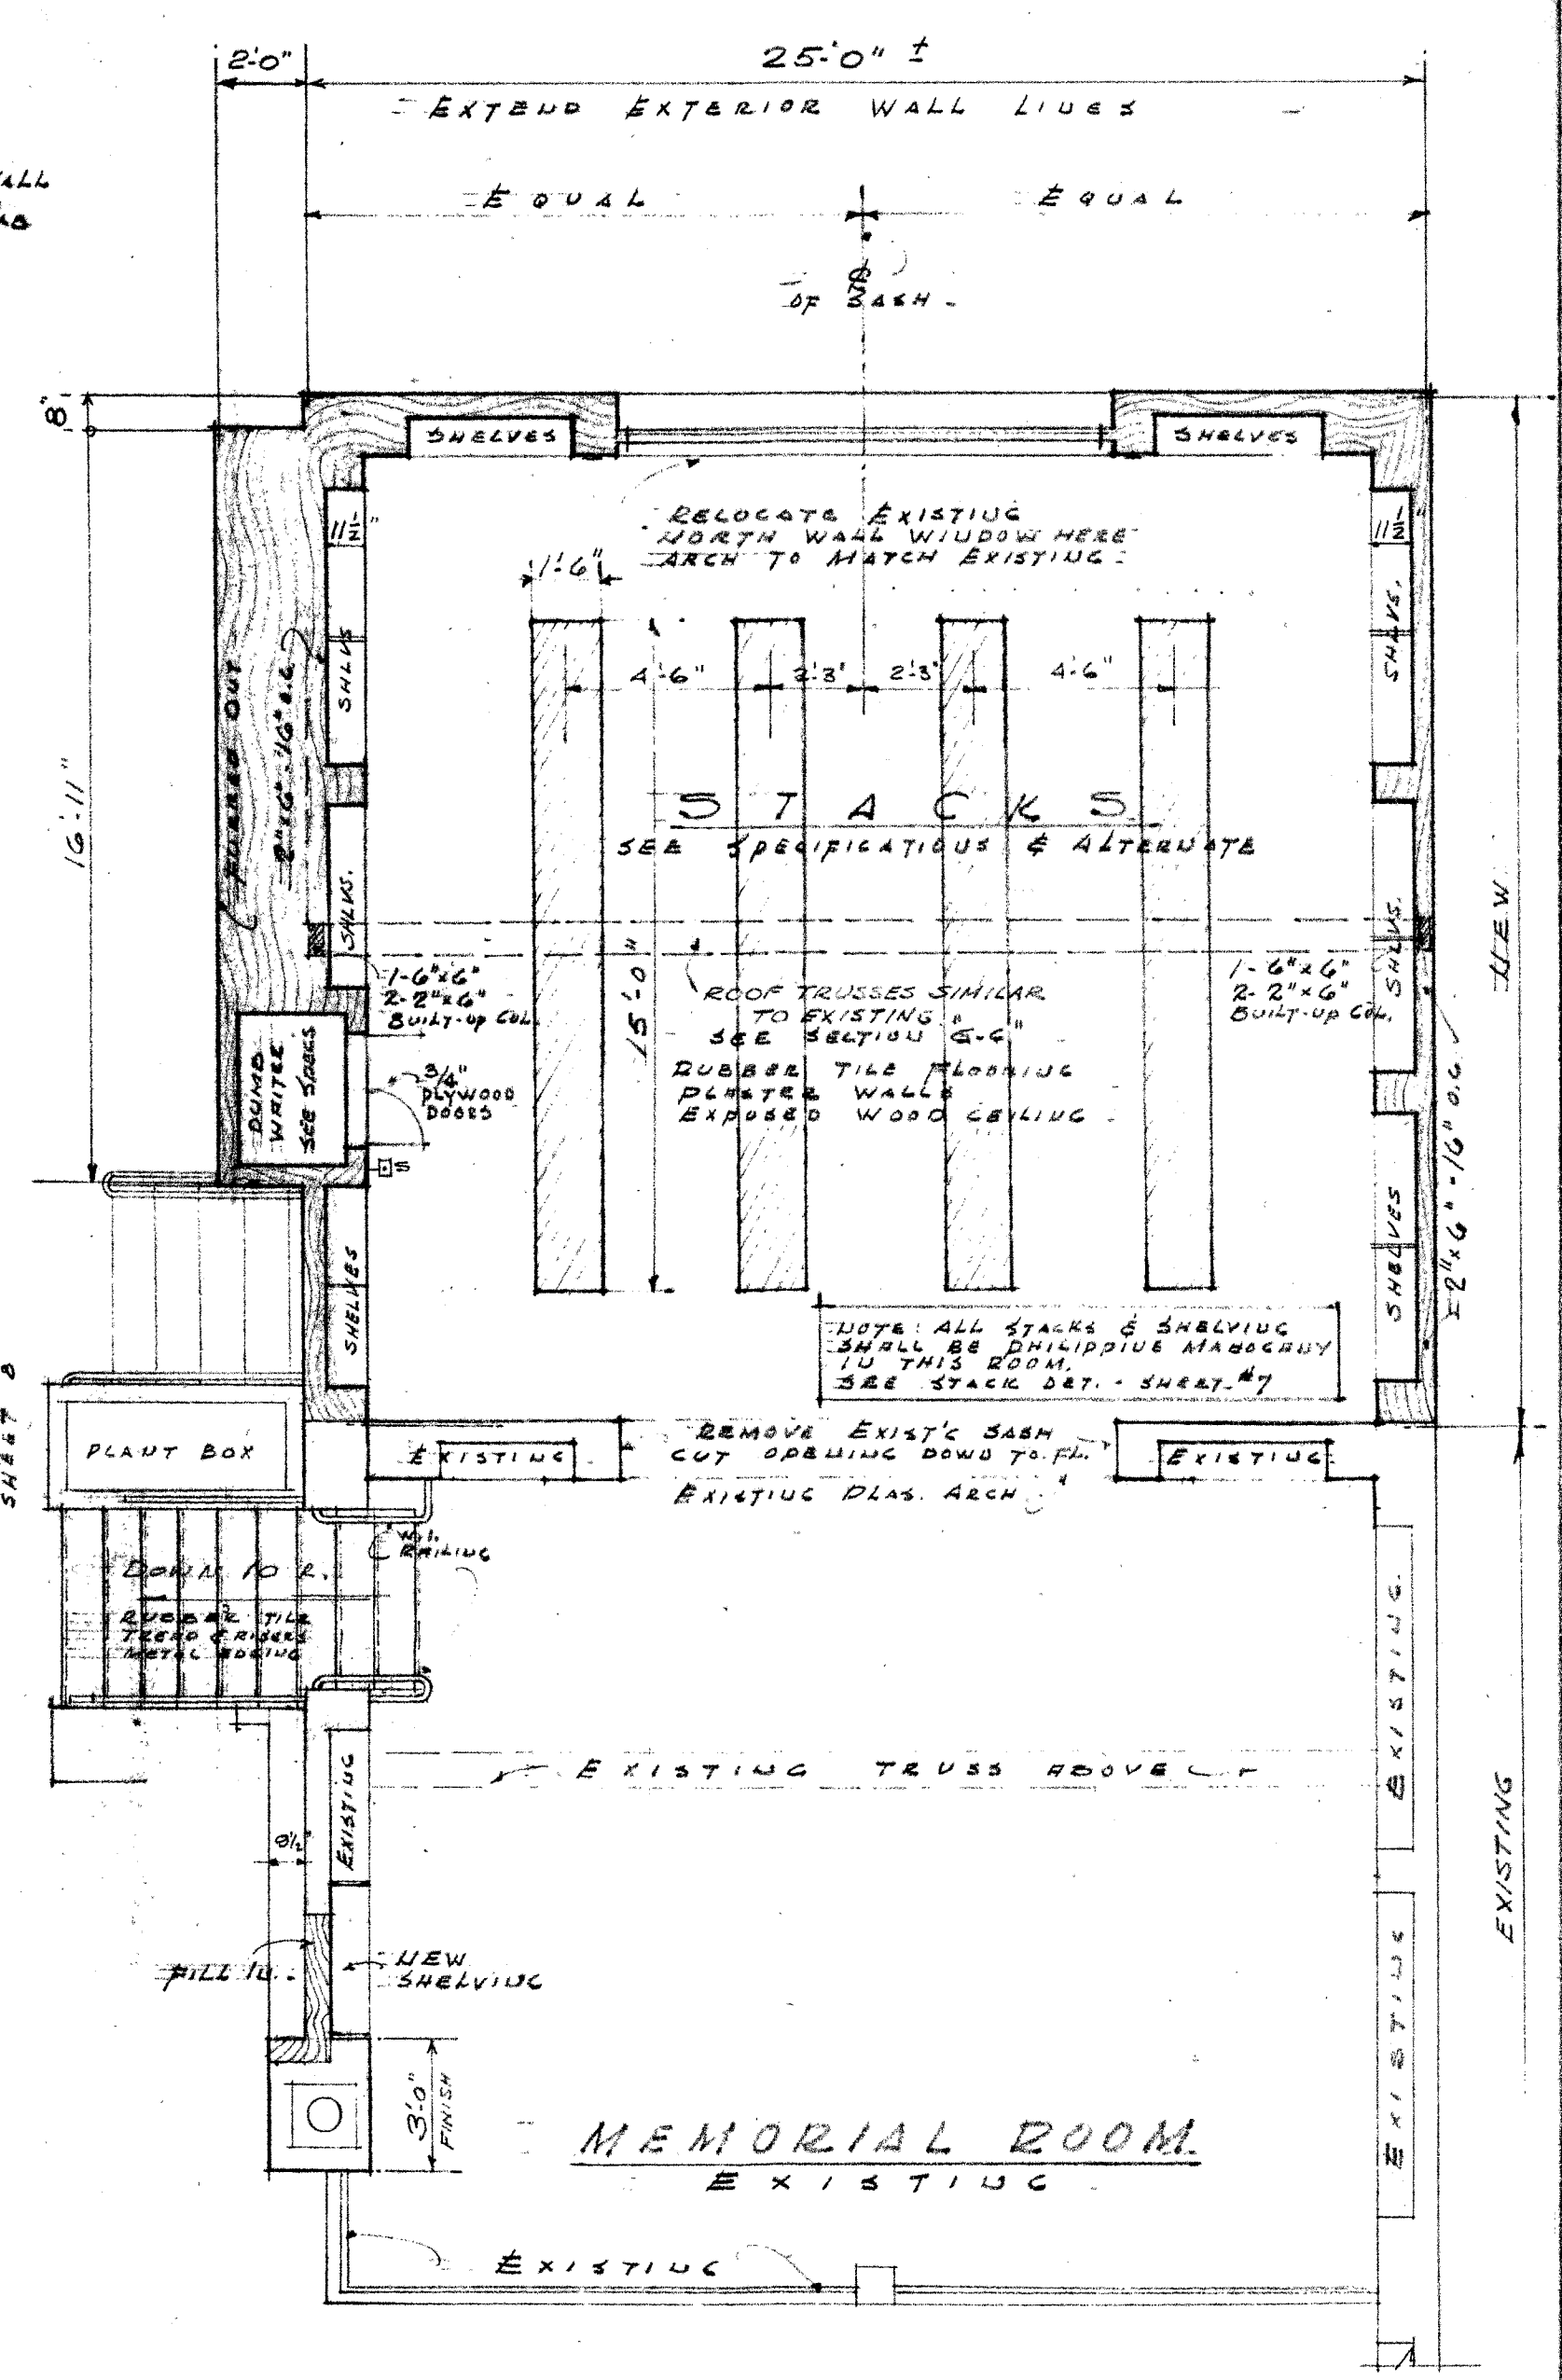


UPPER FLOOR PLAN
SCALE 1/4" = 1'-0"

- NOTES:**
1. INTERIOR & EXTERIOR PLASTER FINISH TO MATCH EXISTING.
 2. RUBBER TILE ON ALL NEW MAIN FL., UPPER FL. & LOBBY FLOORS.
 3. OPEN CEILING TO MATCH EXISTING IN SIZE & SPACING OF MEMBERS, BUT UNSURFACED OR RESAWN FINISH SHALL BE USED INSTEAD OF ADZED FINISH AS IN EXISTING.
 4. SEE DETAIL SHEETS D-1, D-2 & D-3 FOR F.S.D. TRIM & DOOR & WINDOW SECTIONS.
 5. NEW WORK
 6. EXISTING WORK
 7. WORK REMOVED
 8. ALTERNATE #1 - STACKS

ALTERATIONS & ADDITIONS		JOB NO. 4820
HARRISON MEMORIAL LIBRARY		DWG. BY S.J.S.
CARMEL CALIF.		CHK. BY W.T.S.
ROBERT R. JONES, ARCHITECT		DATE 7/29/49
BOX 227 - CARMEL, CALIF. - PHONE 347		ISSUED
MAIN FLOOR PLAN		SHEET 2 OF 8
UPPER FLOOR PLAN		

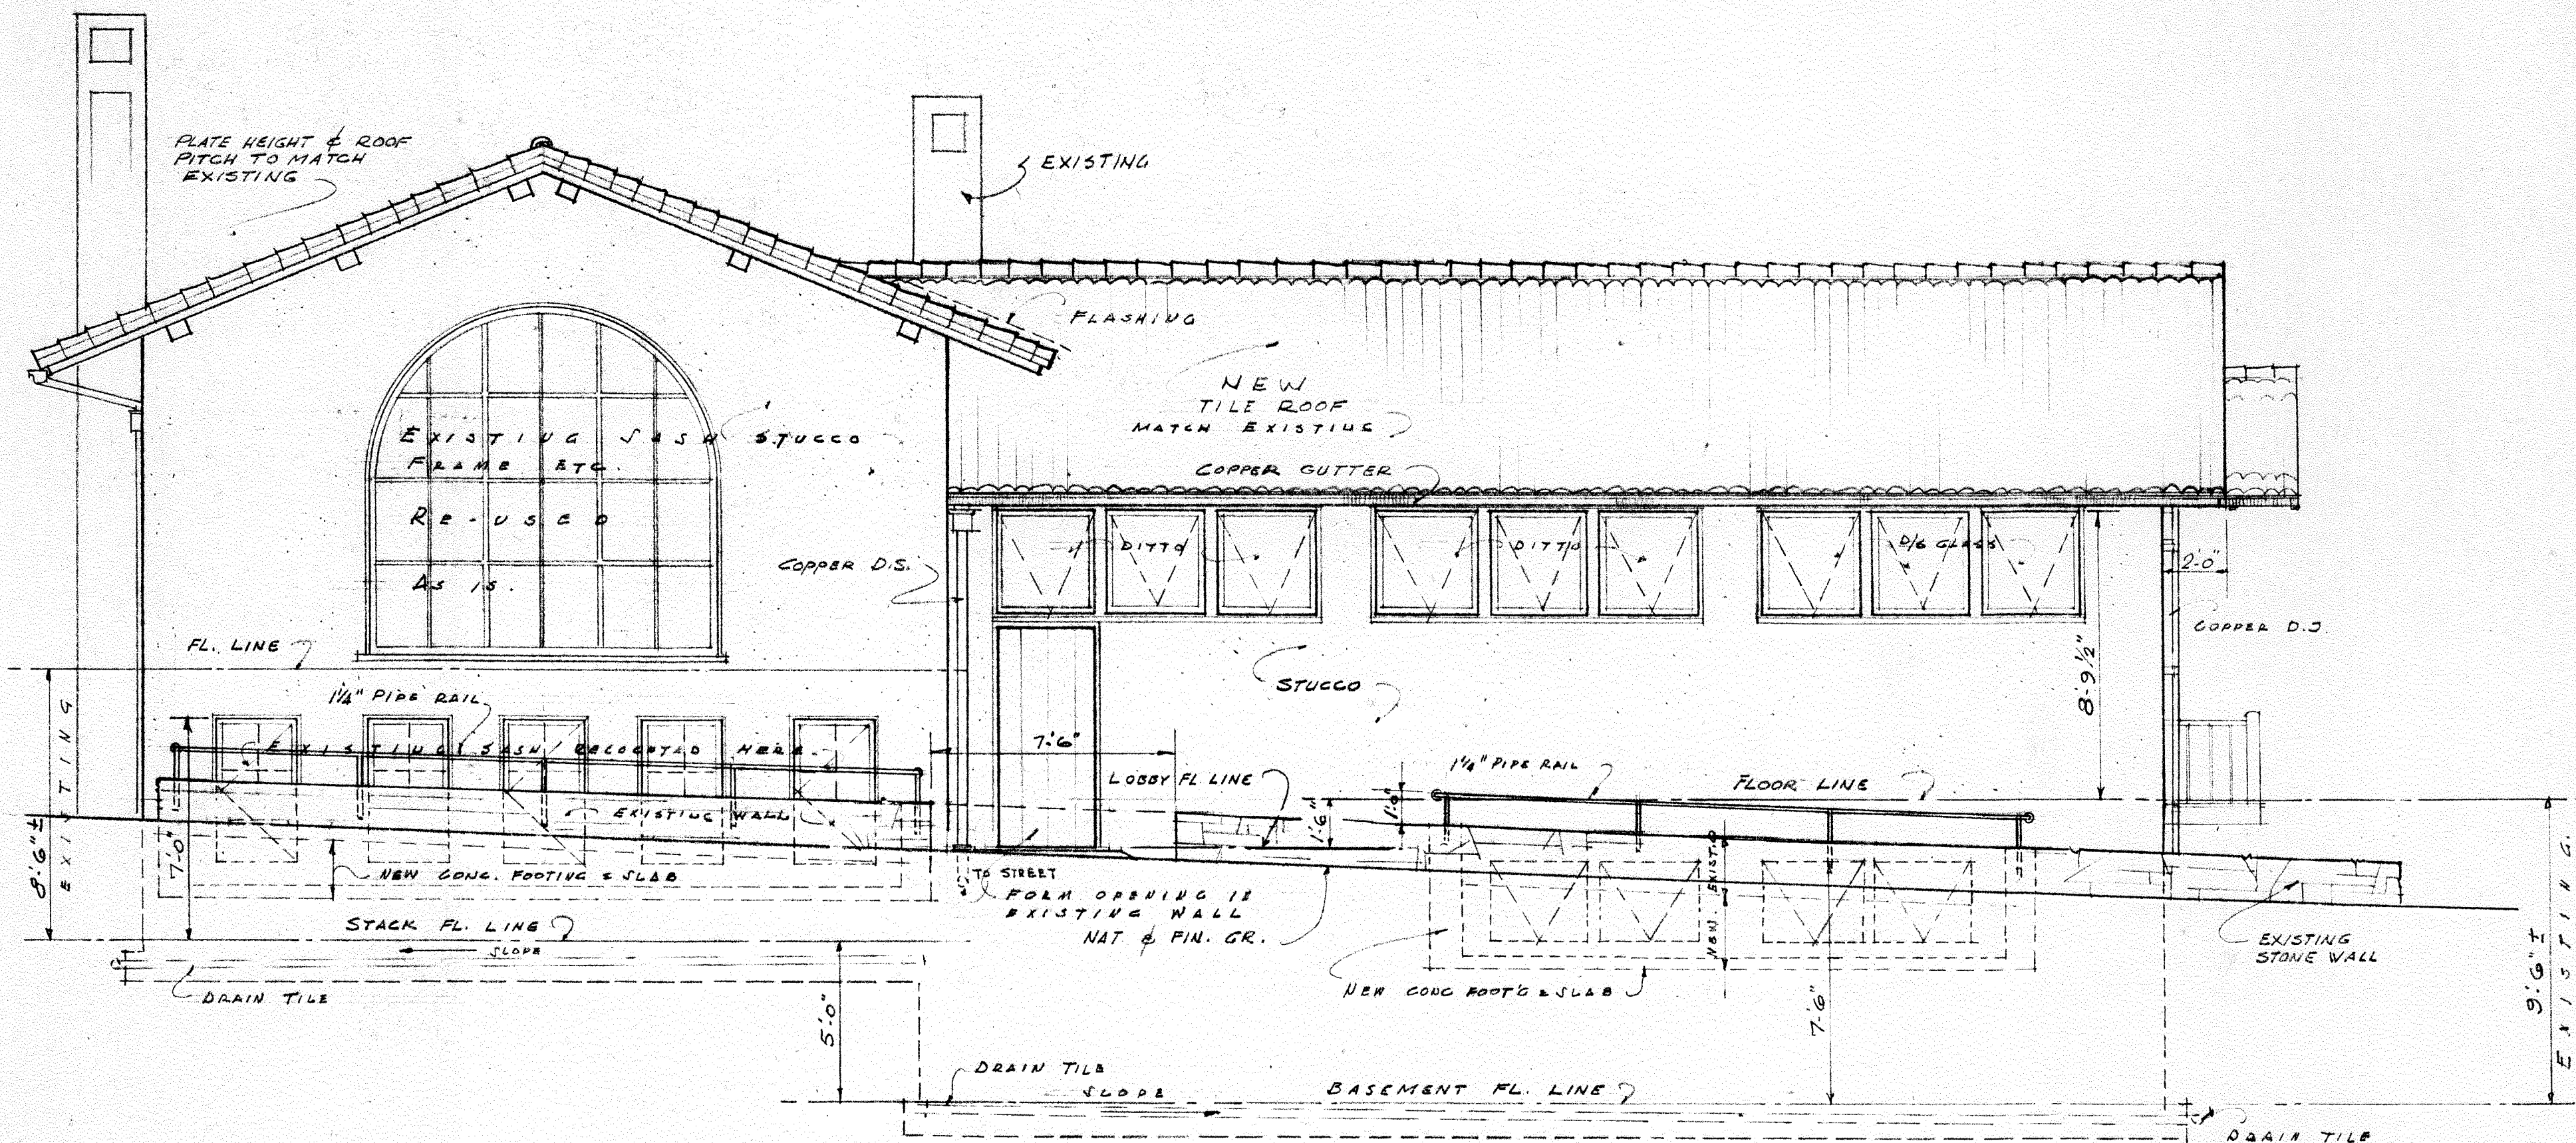


NORTH (SIXTH AVE.)

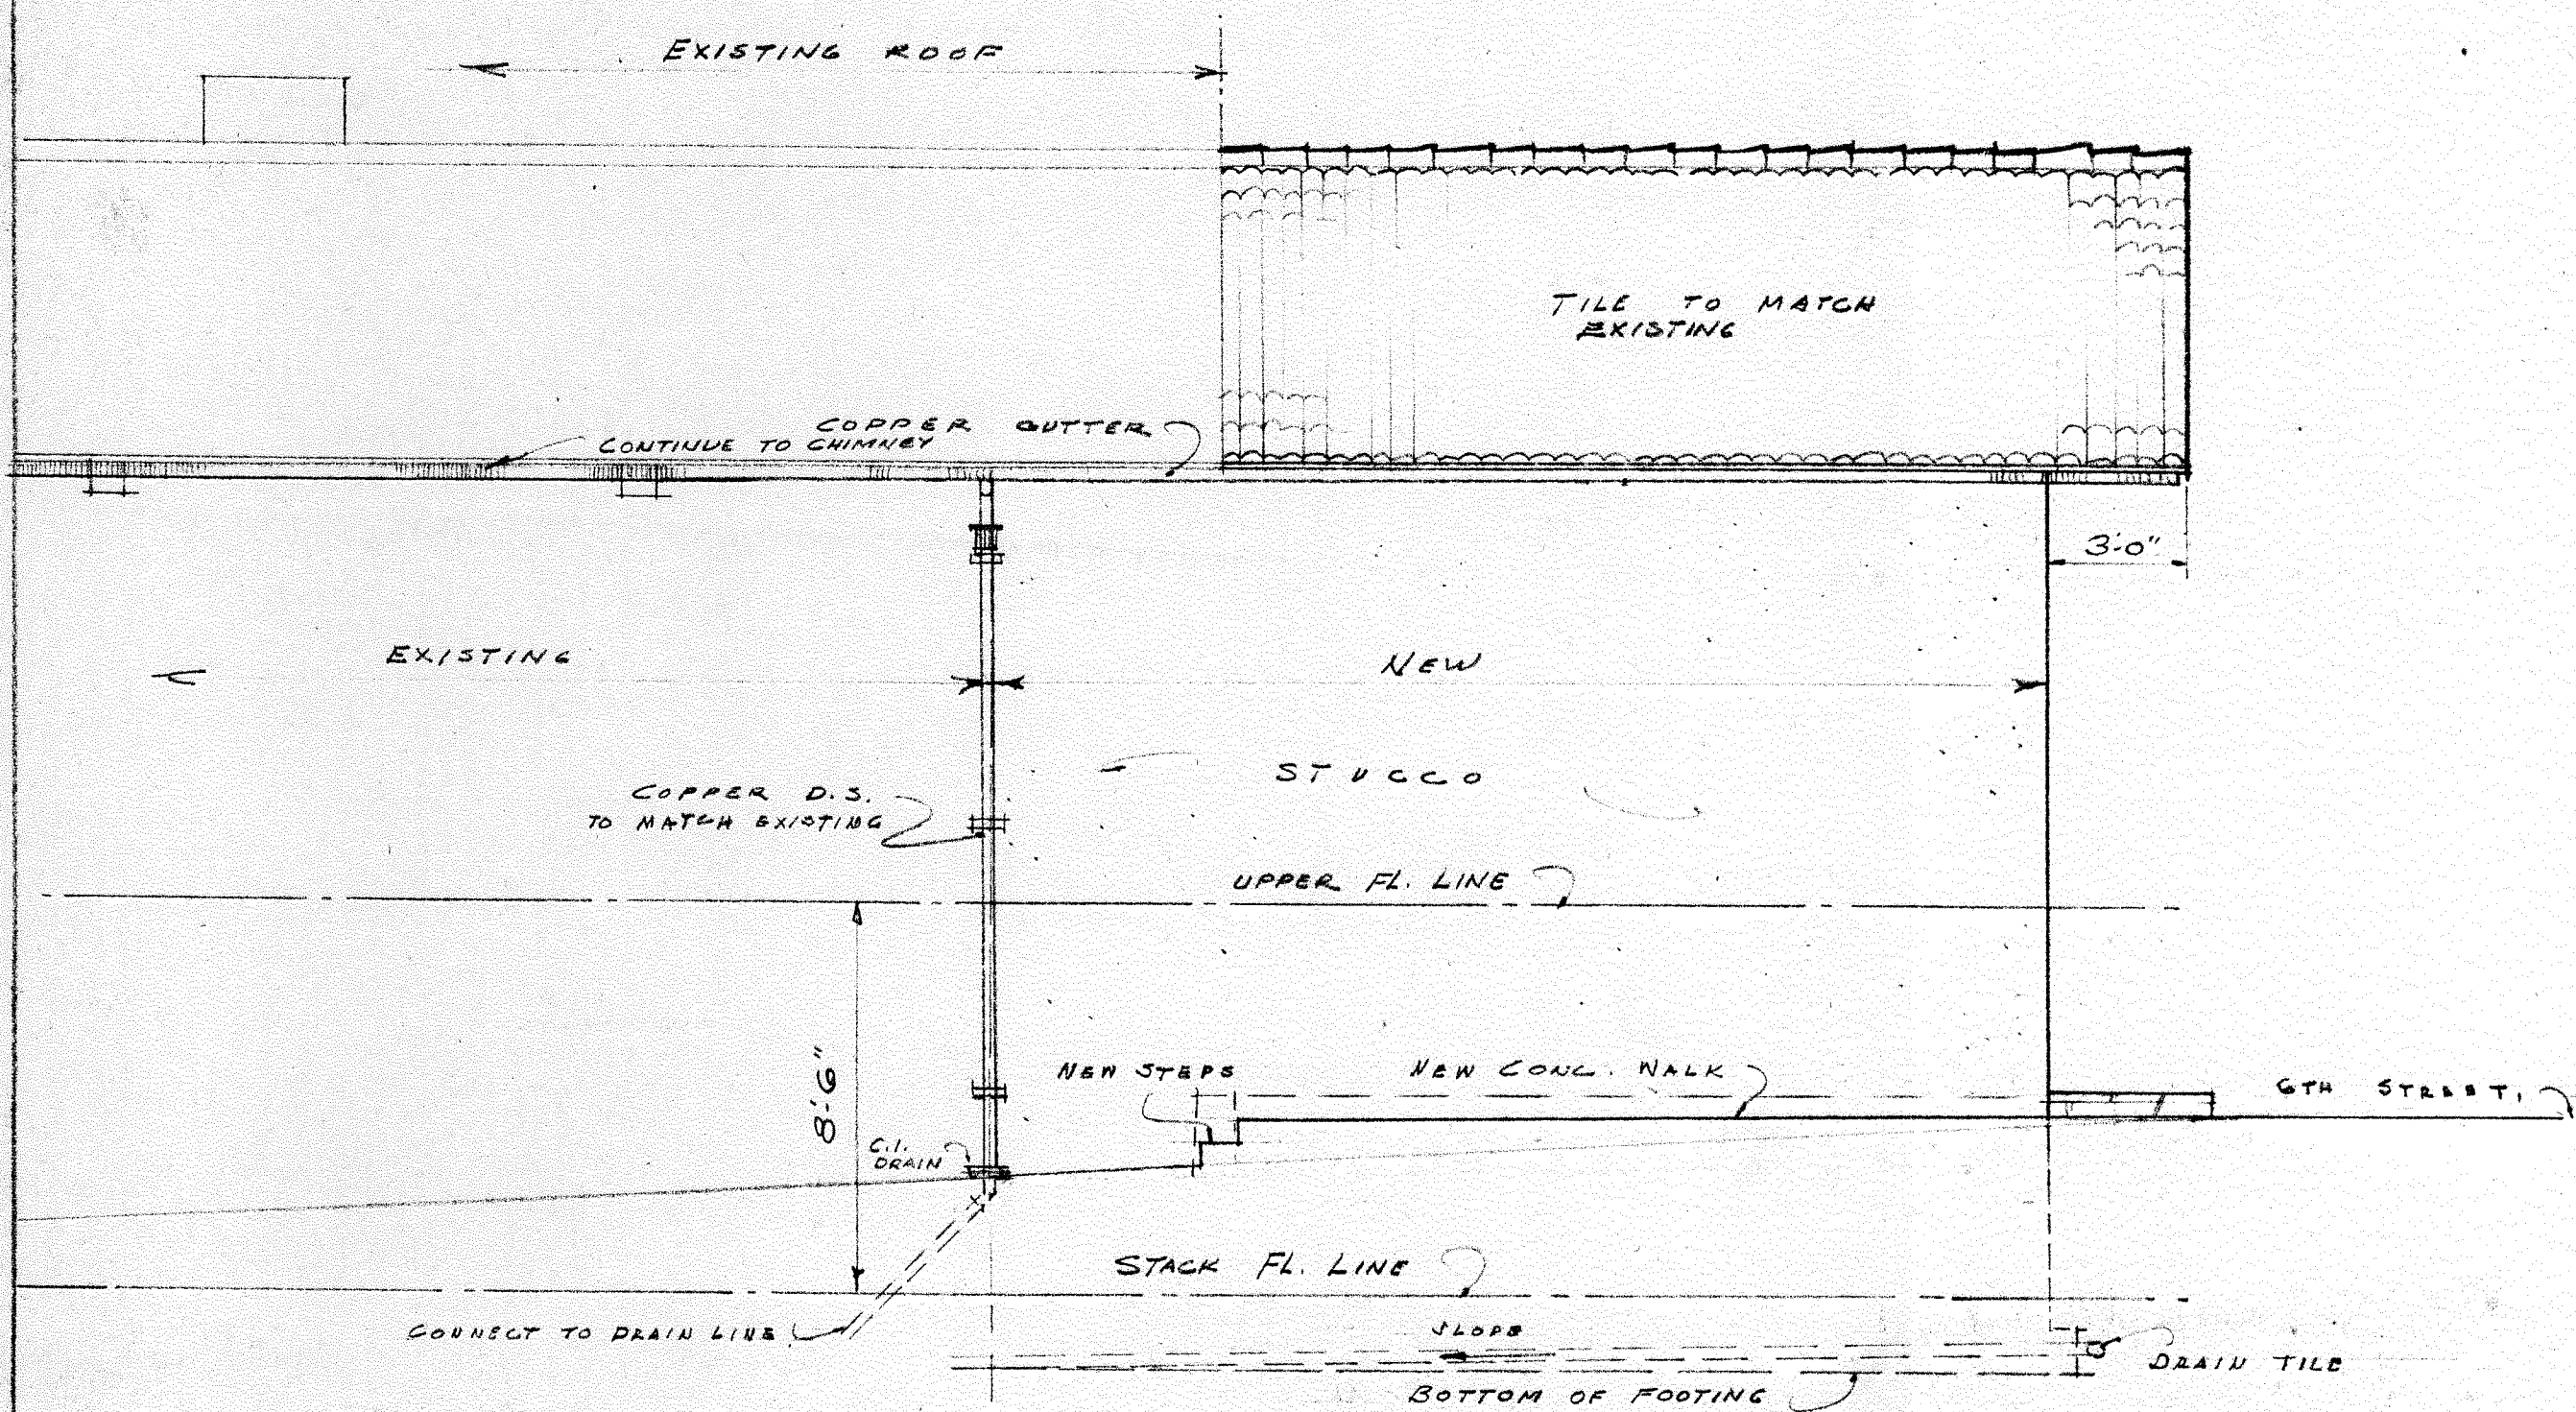


EAST

6	ALTERATIONS & ADDITIONS	JOB NO.	4820
5	HARRISON MEMORIAL	DRWG BY	S.W.S.
4	LIBRARY	CHK BY	HTS
3	CARMEL CALIF	SHEET	4
2	ROBERT K. JONES, ARCHITECT	OF	8
1	BOX 927 - CARMEL, CALIFORNIA - PHONE 347		
Date	By	Rev	Issued
7/29/49			

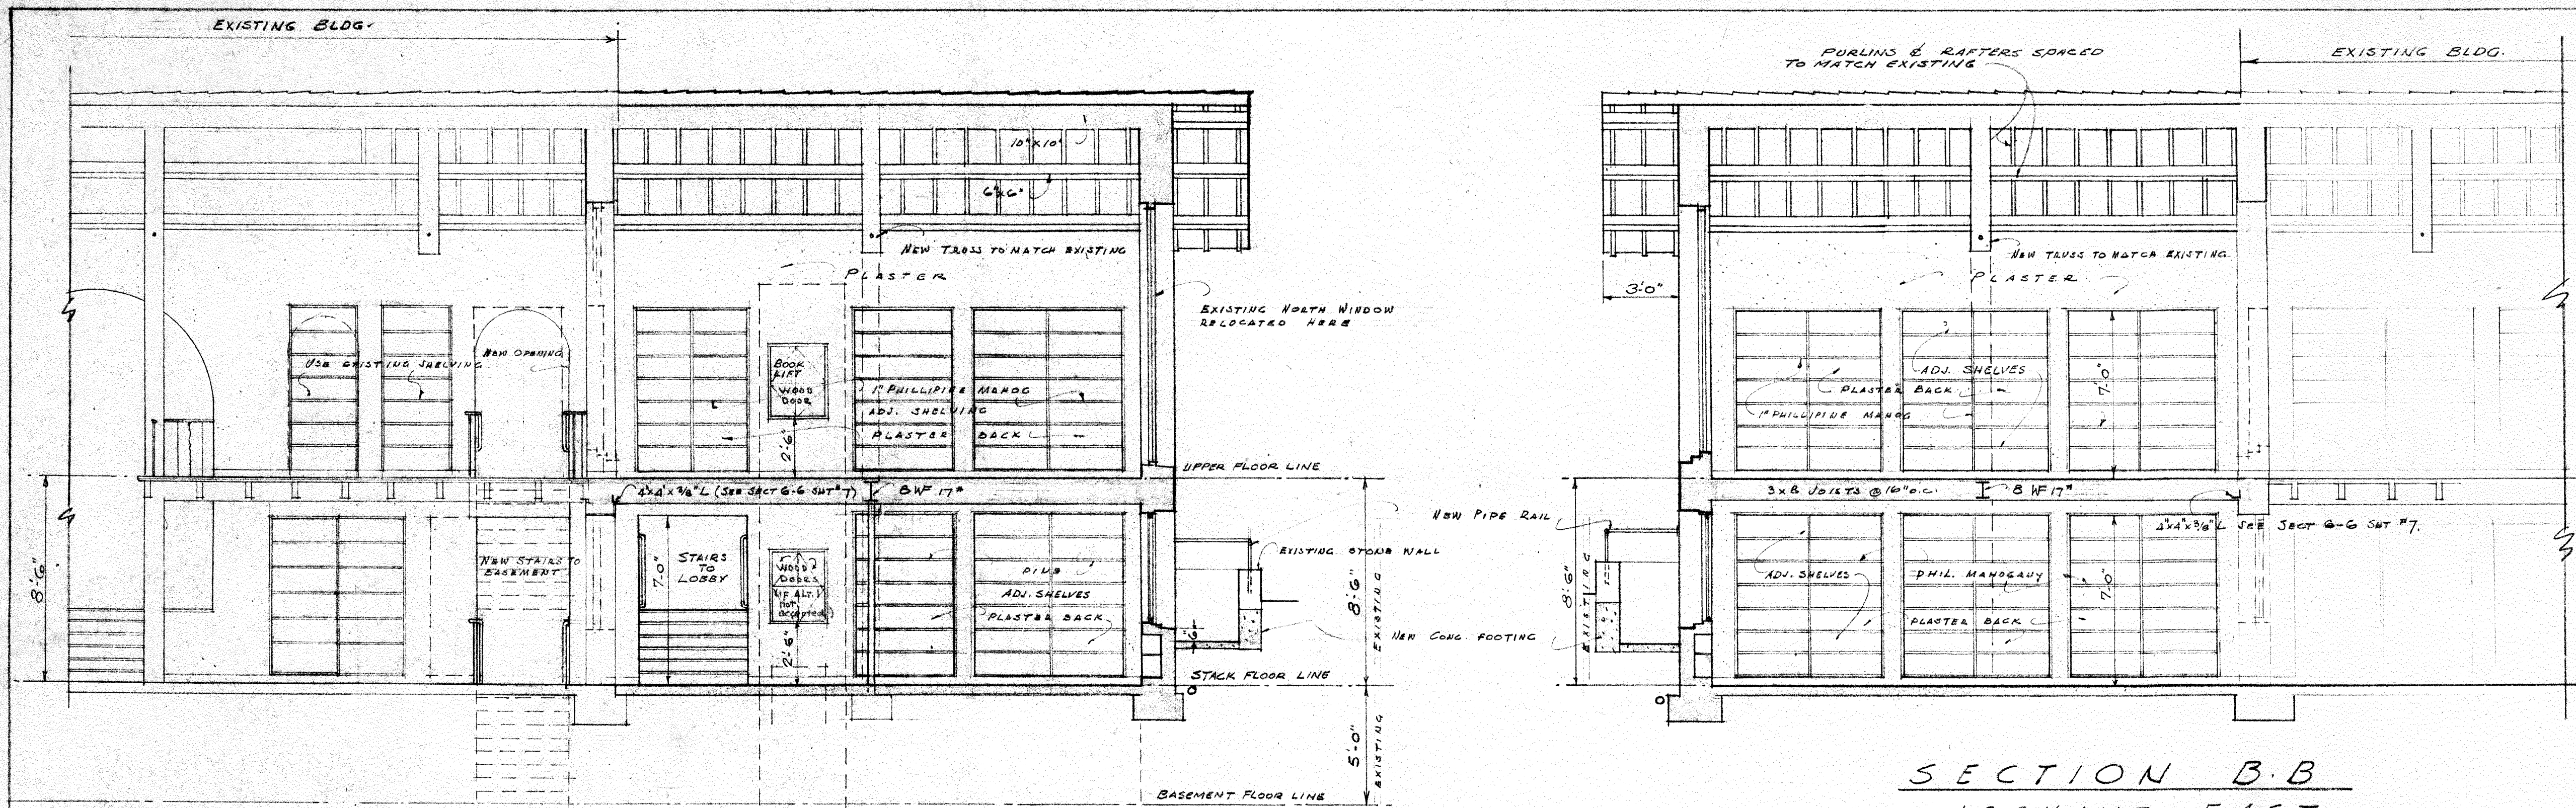

SECTION A-A
LOOKING WEST


SECTION B-B
LOOKING EAST

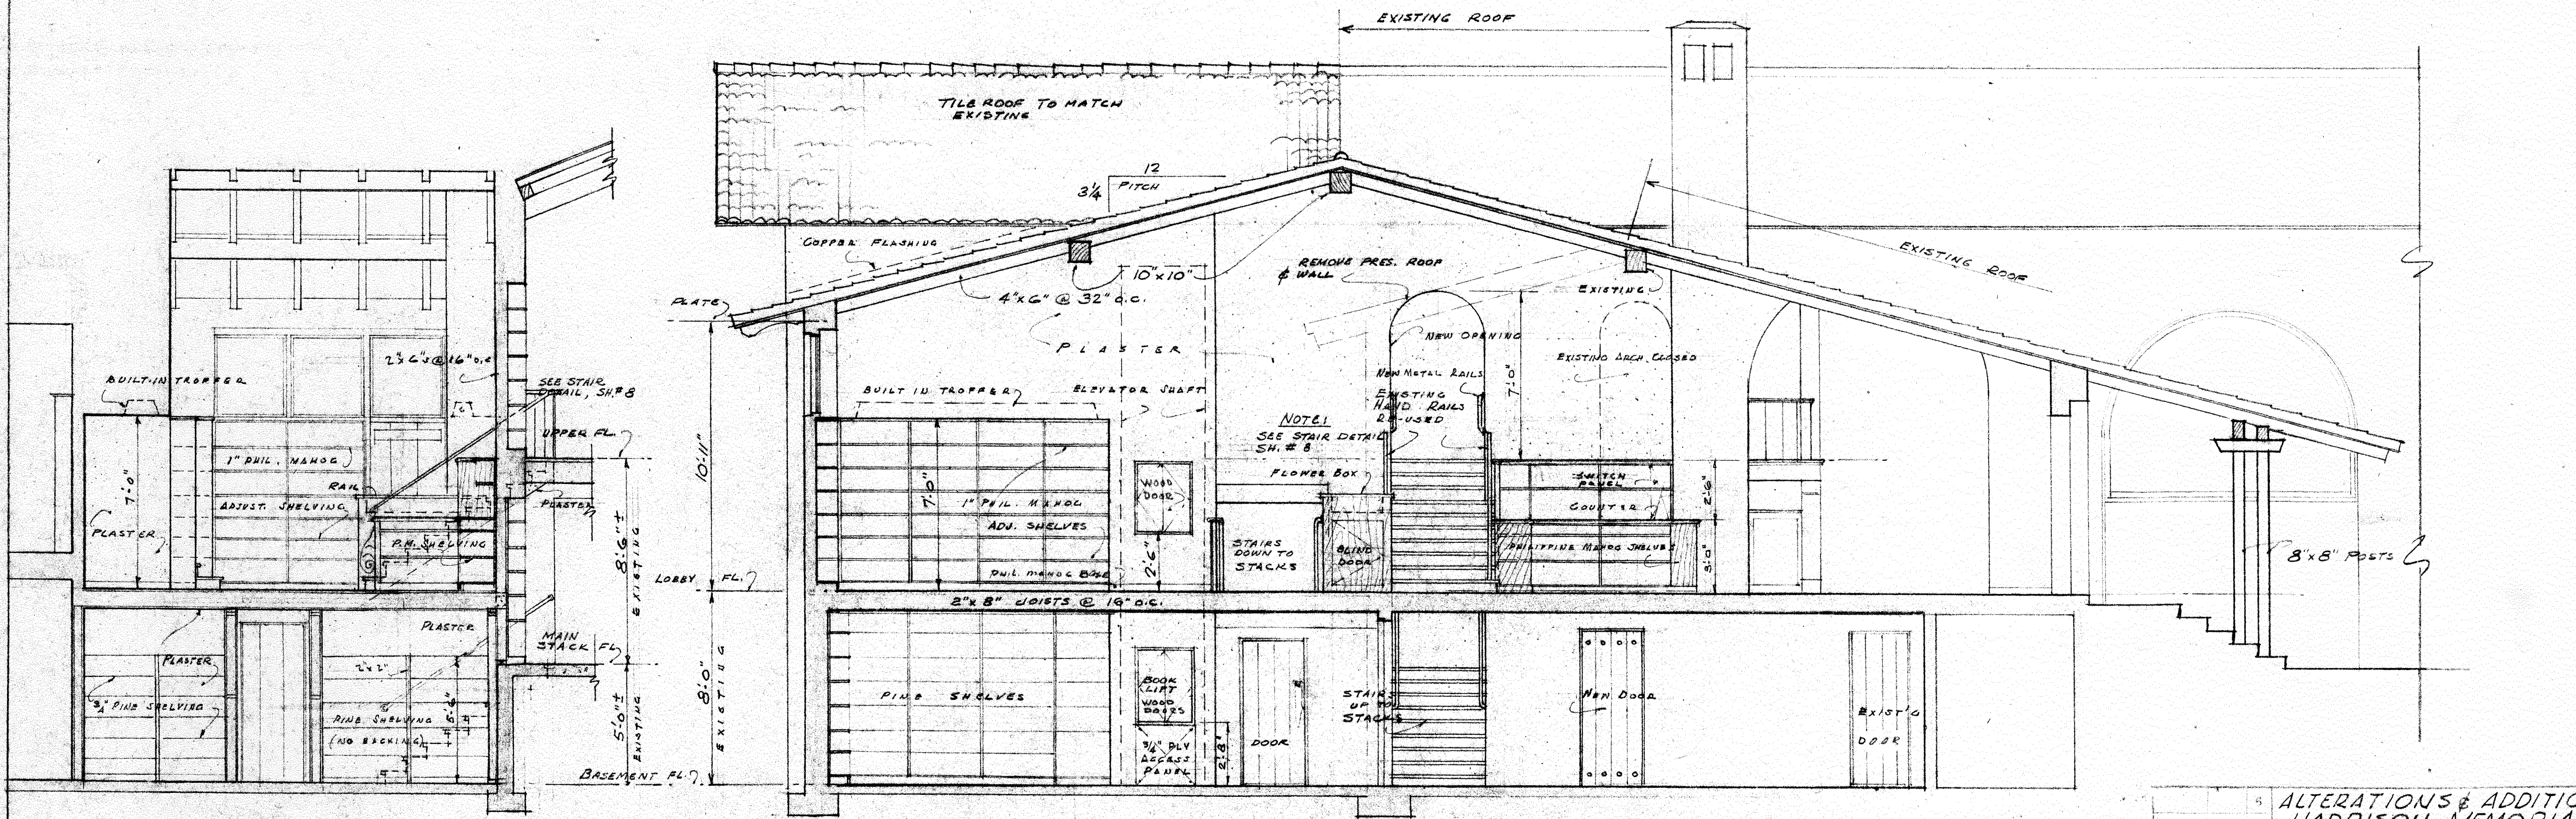


SECTION H-H

SECTION C-C


5	ALTERATIONS & ADDITIONS	4820
4	HARRISON MEMORIAL	DRAWN BY
3	LIBRARY	5-1-51
2	CARMEL CALIF	CHK BY
1	ROBERT R. JONES, ARCHITECT	HTS.
	BOX 917 - CARMEL, CALIFORNIA - PHONE 247	SHEET
	<u>SECTIONS (A) (B) (C) & (H)</u>	5
Date	7/22/49	OF 8

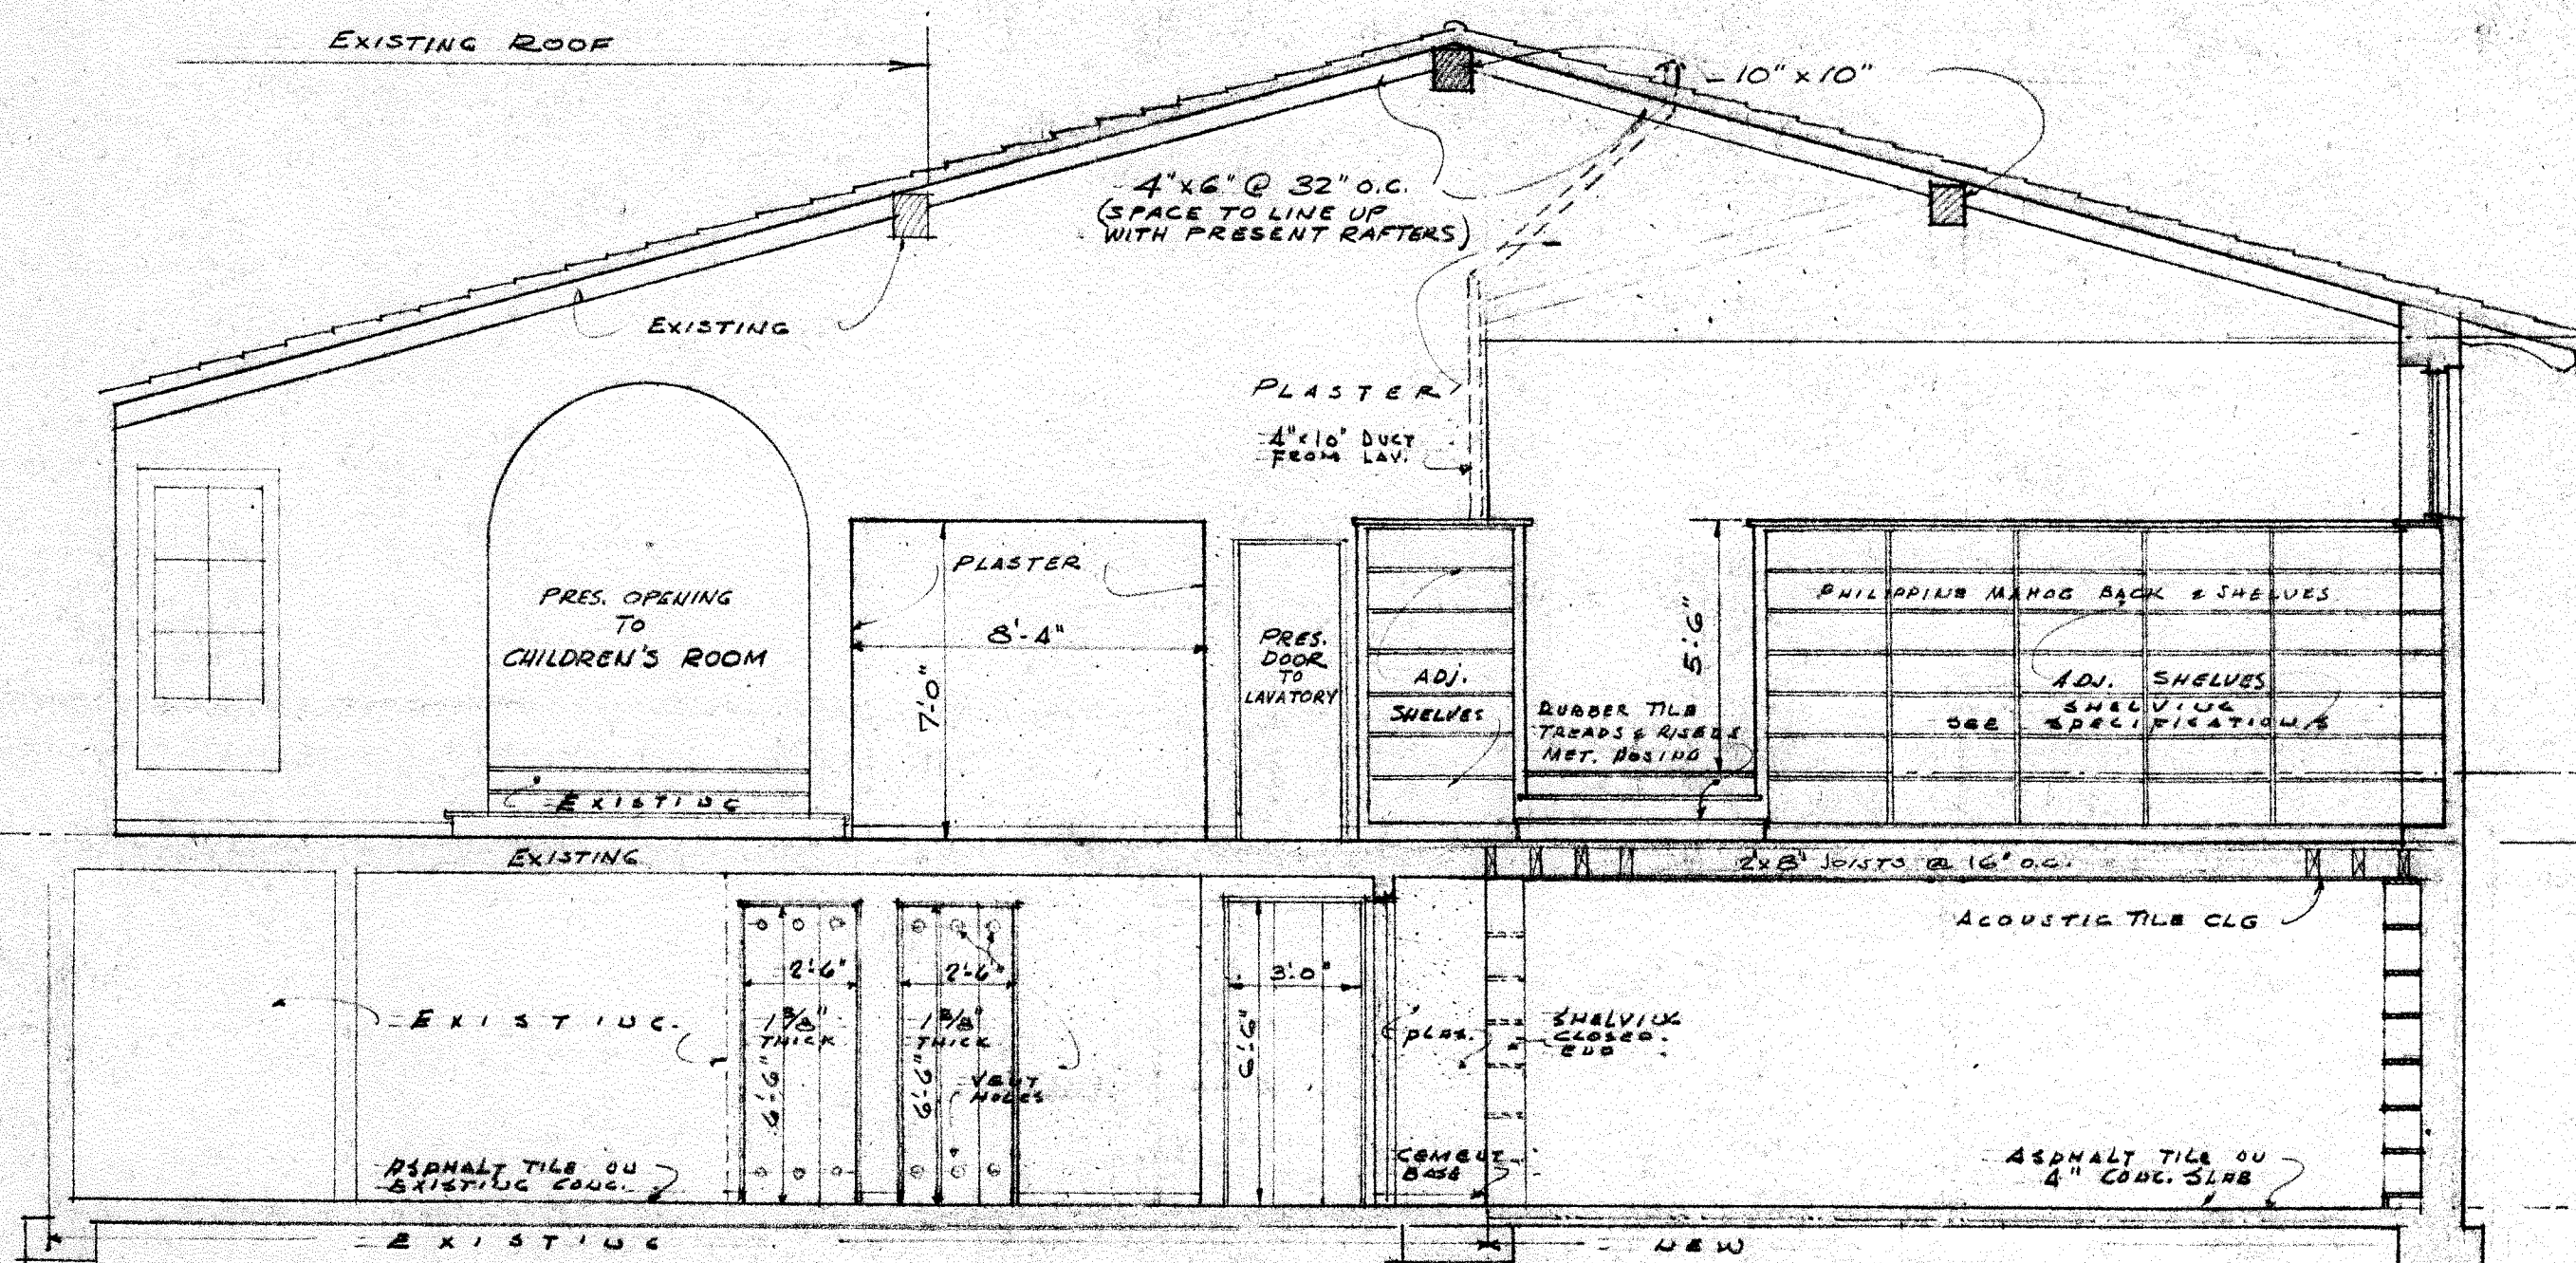


SECTION D-D
LOOKING WEST

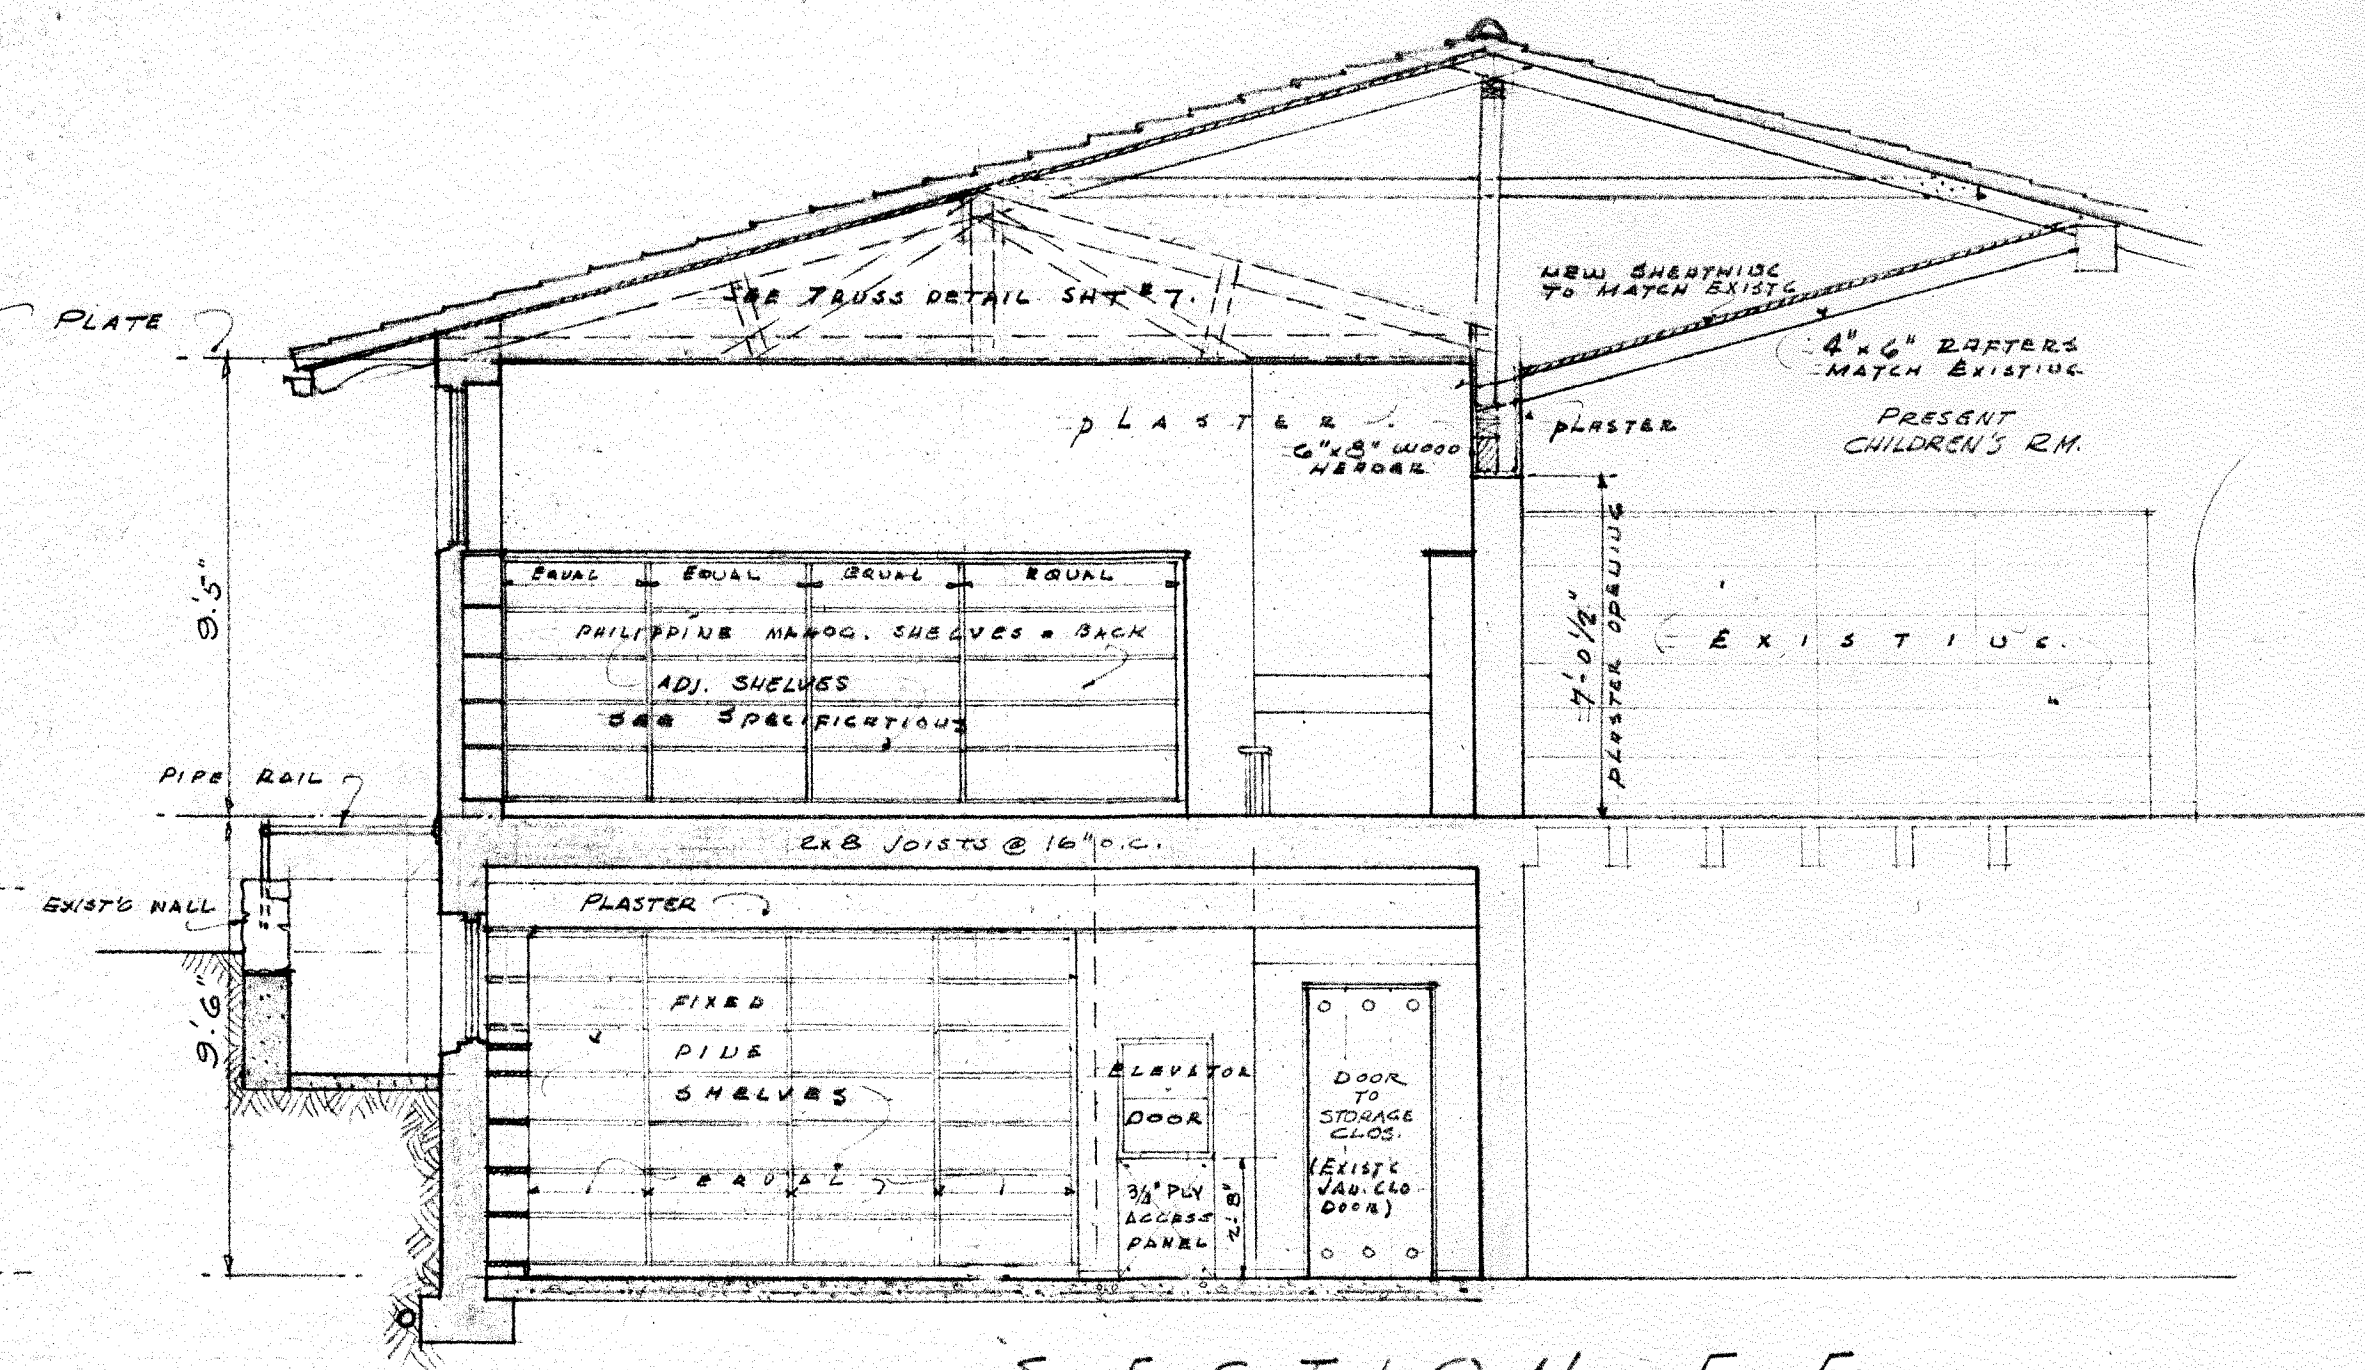


SECTION E-E
LOOKING EAST

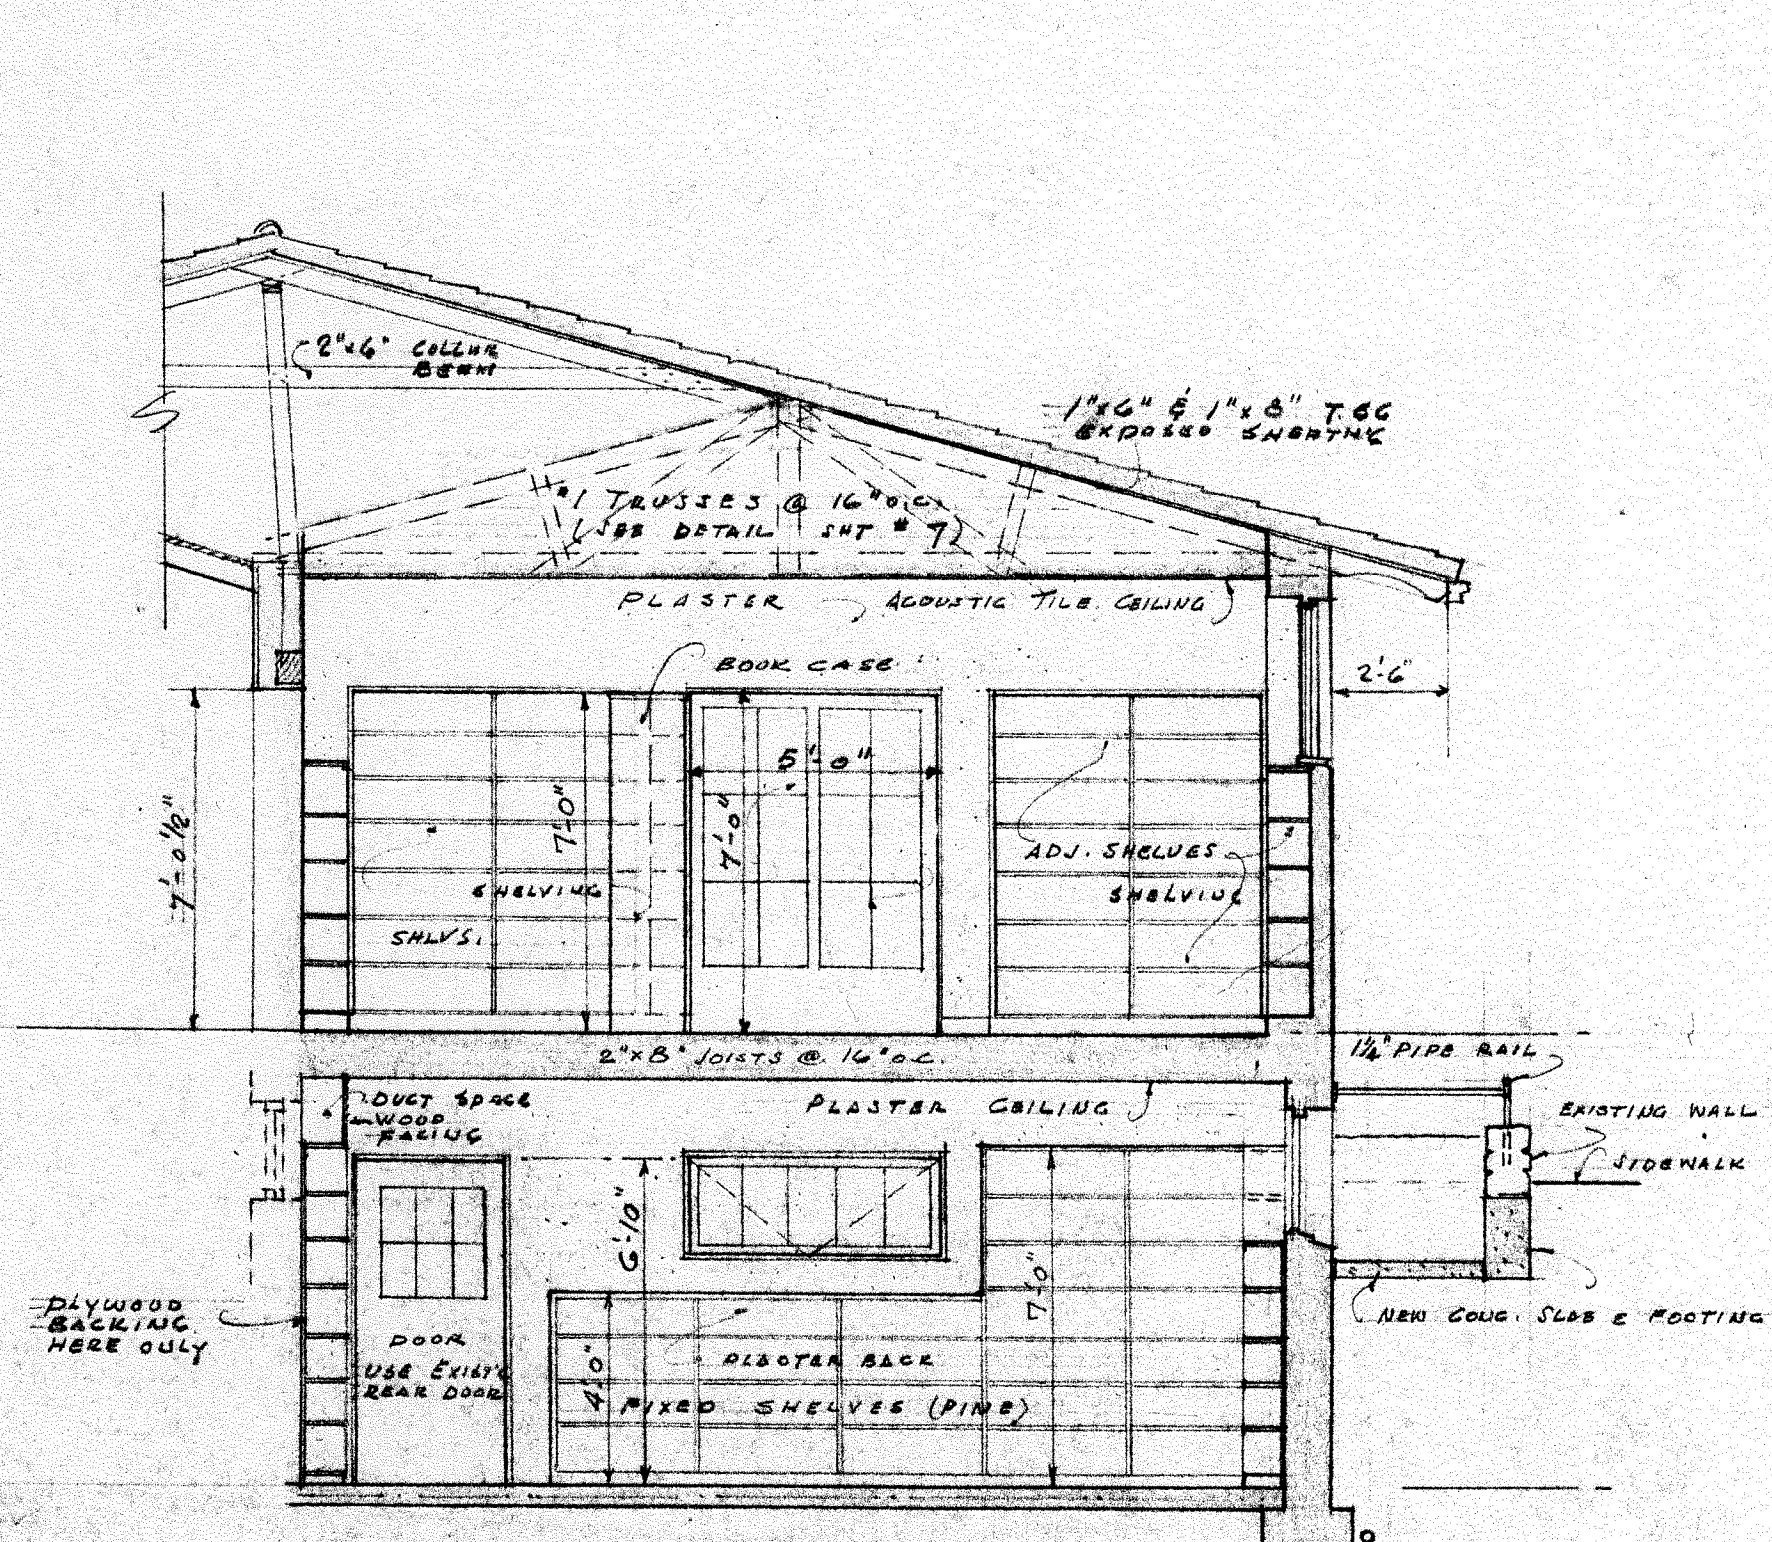


SECTION F-F
LOOKING WEST

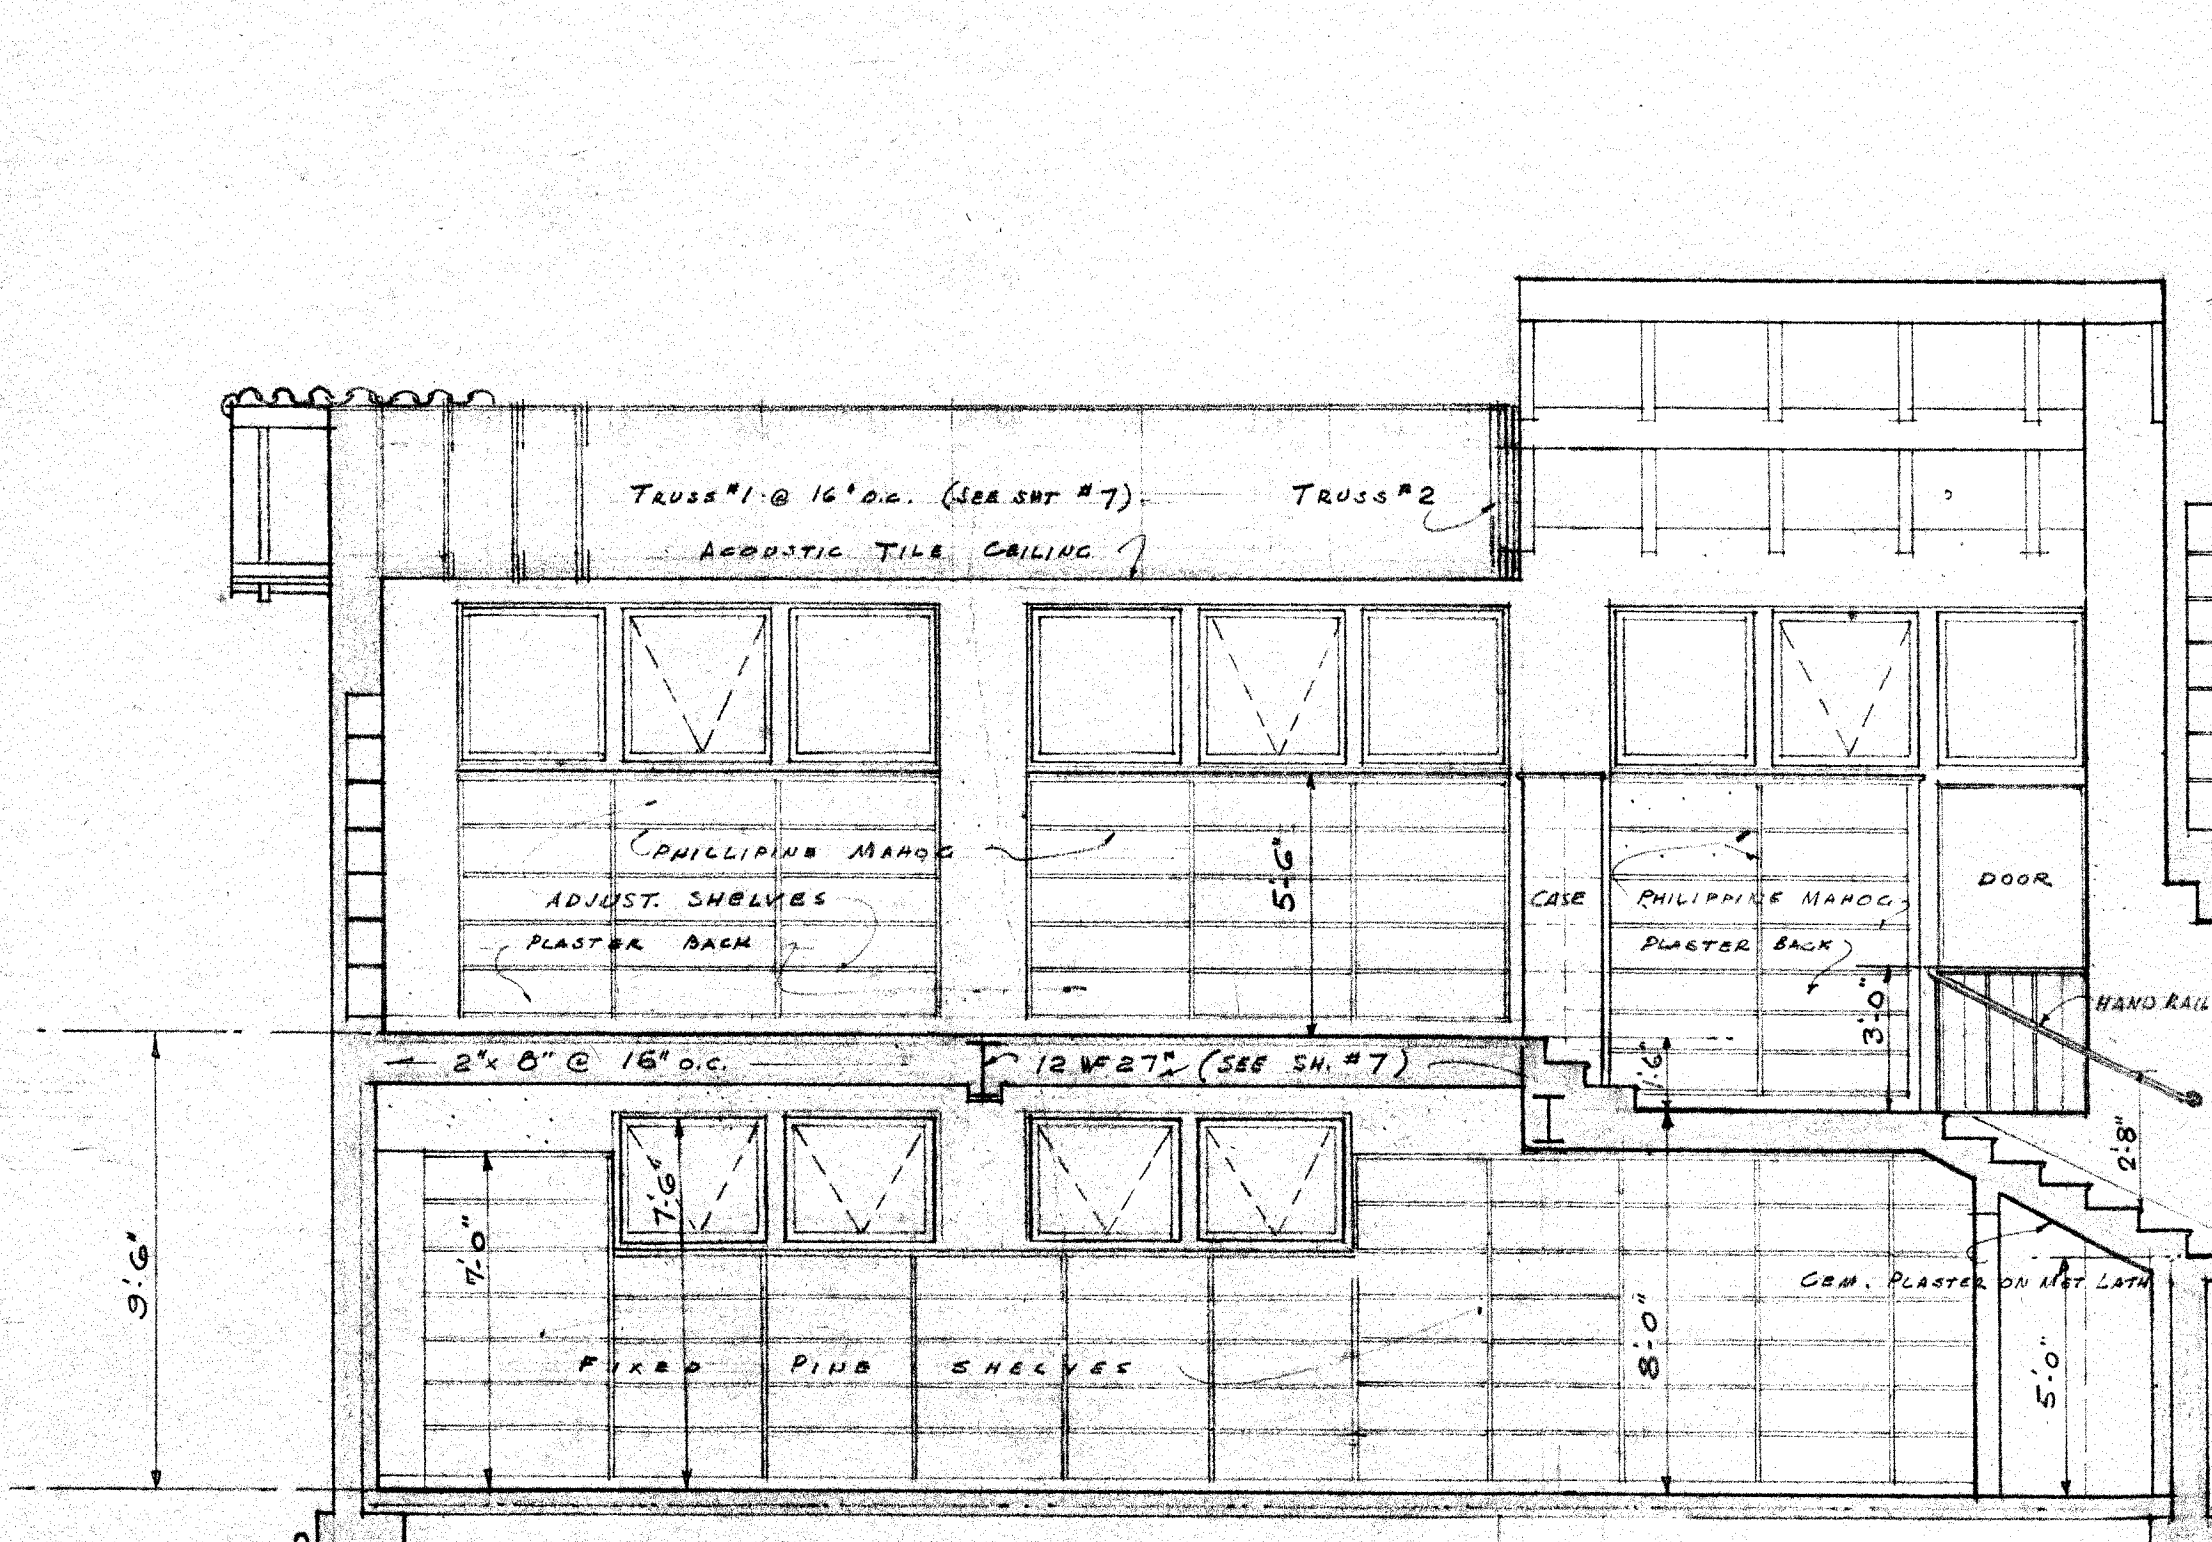





SECTION G-G
LOOKING NORTH

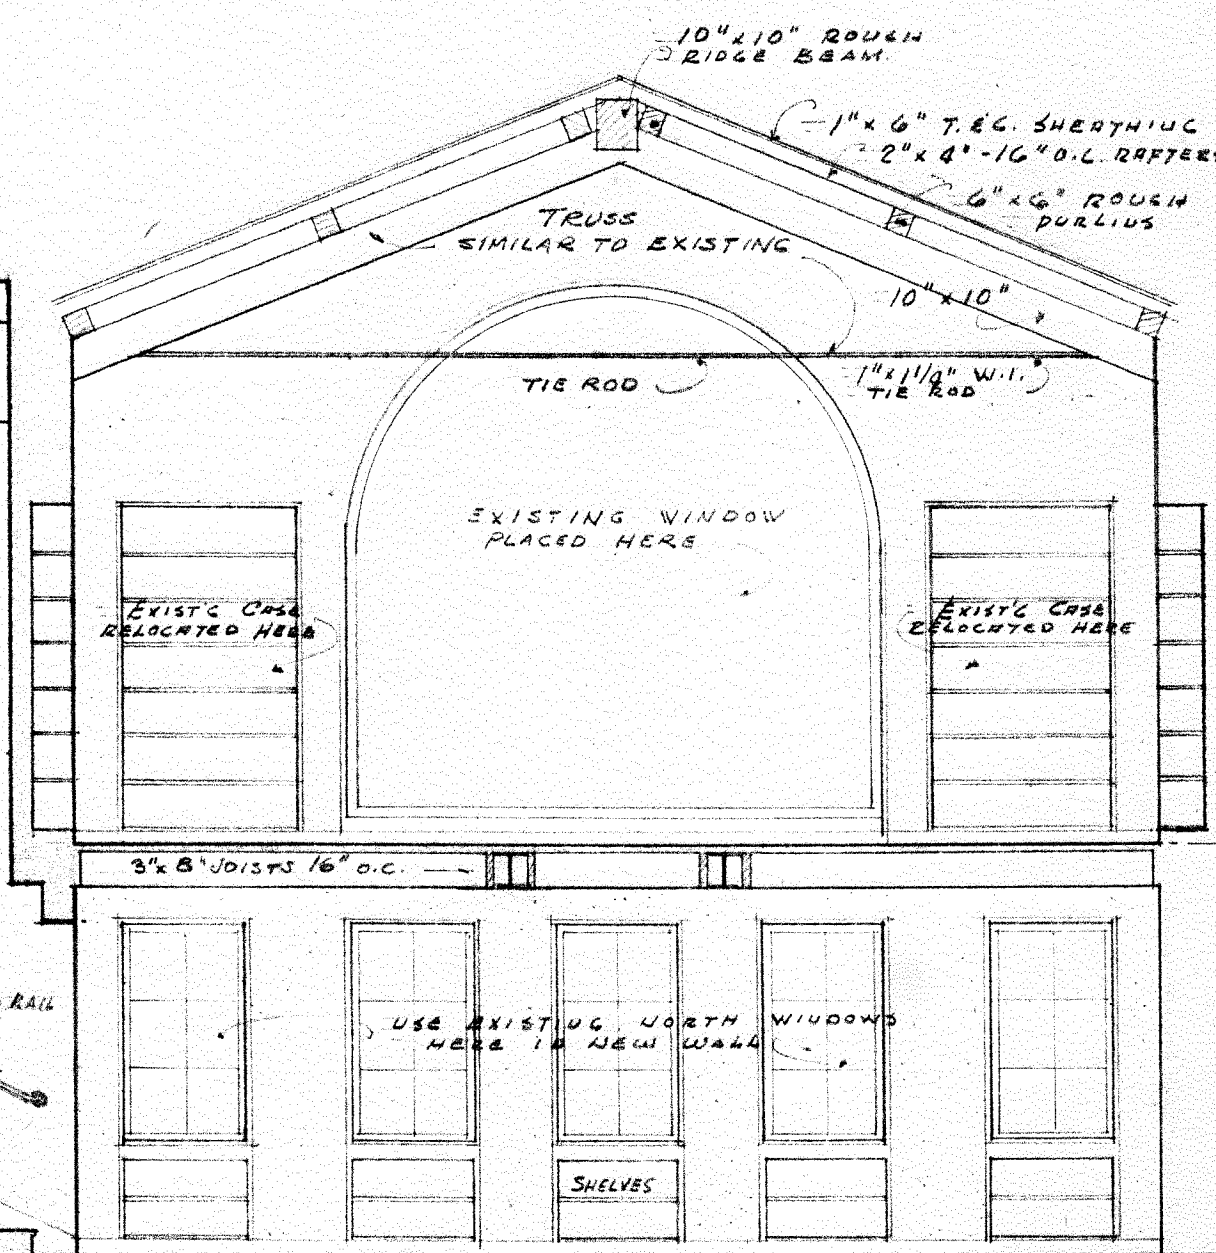

6	ALTERATIONS & ADDITIONS	JOB NO.	4820
5	HARRISON MEMORIAL	DRWG BY	S.J.S.
4	LIBRARY	CHK BY	HTS
3	CARMEL CALIF.	DATE	4/29/49
2	ROBERT R. JONES, ARCHITECT	FIGURE	547
1	BOX 927 - CARMEL, CALIFORNIA	SECTION	(D) (E) (F) & (G)
		OF	8

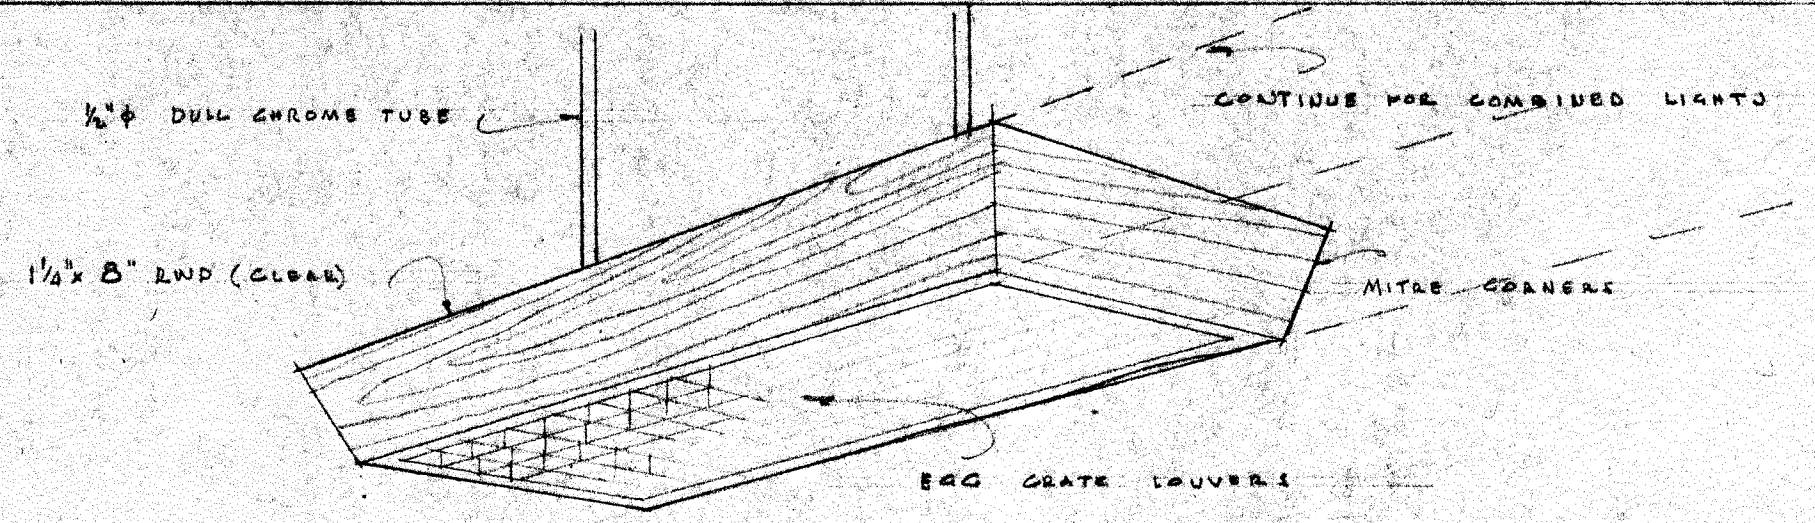

PERSPECTIVE SKETCH OF LIGHT

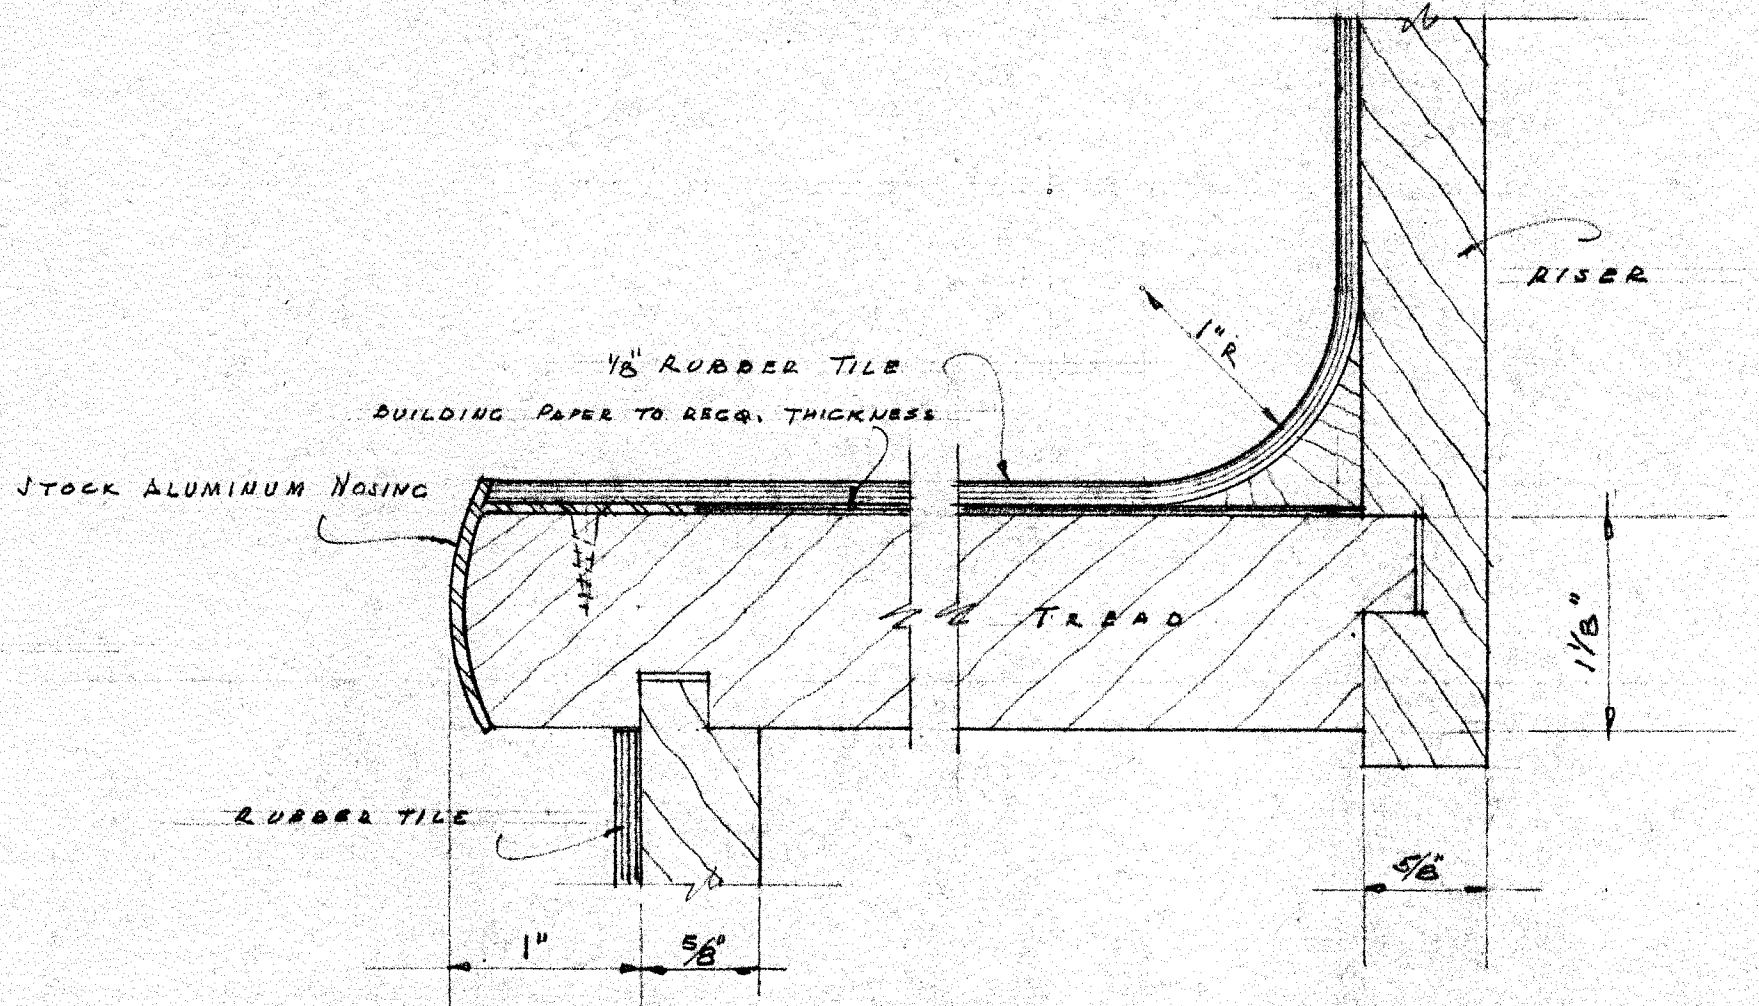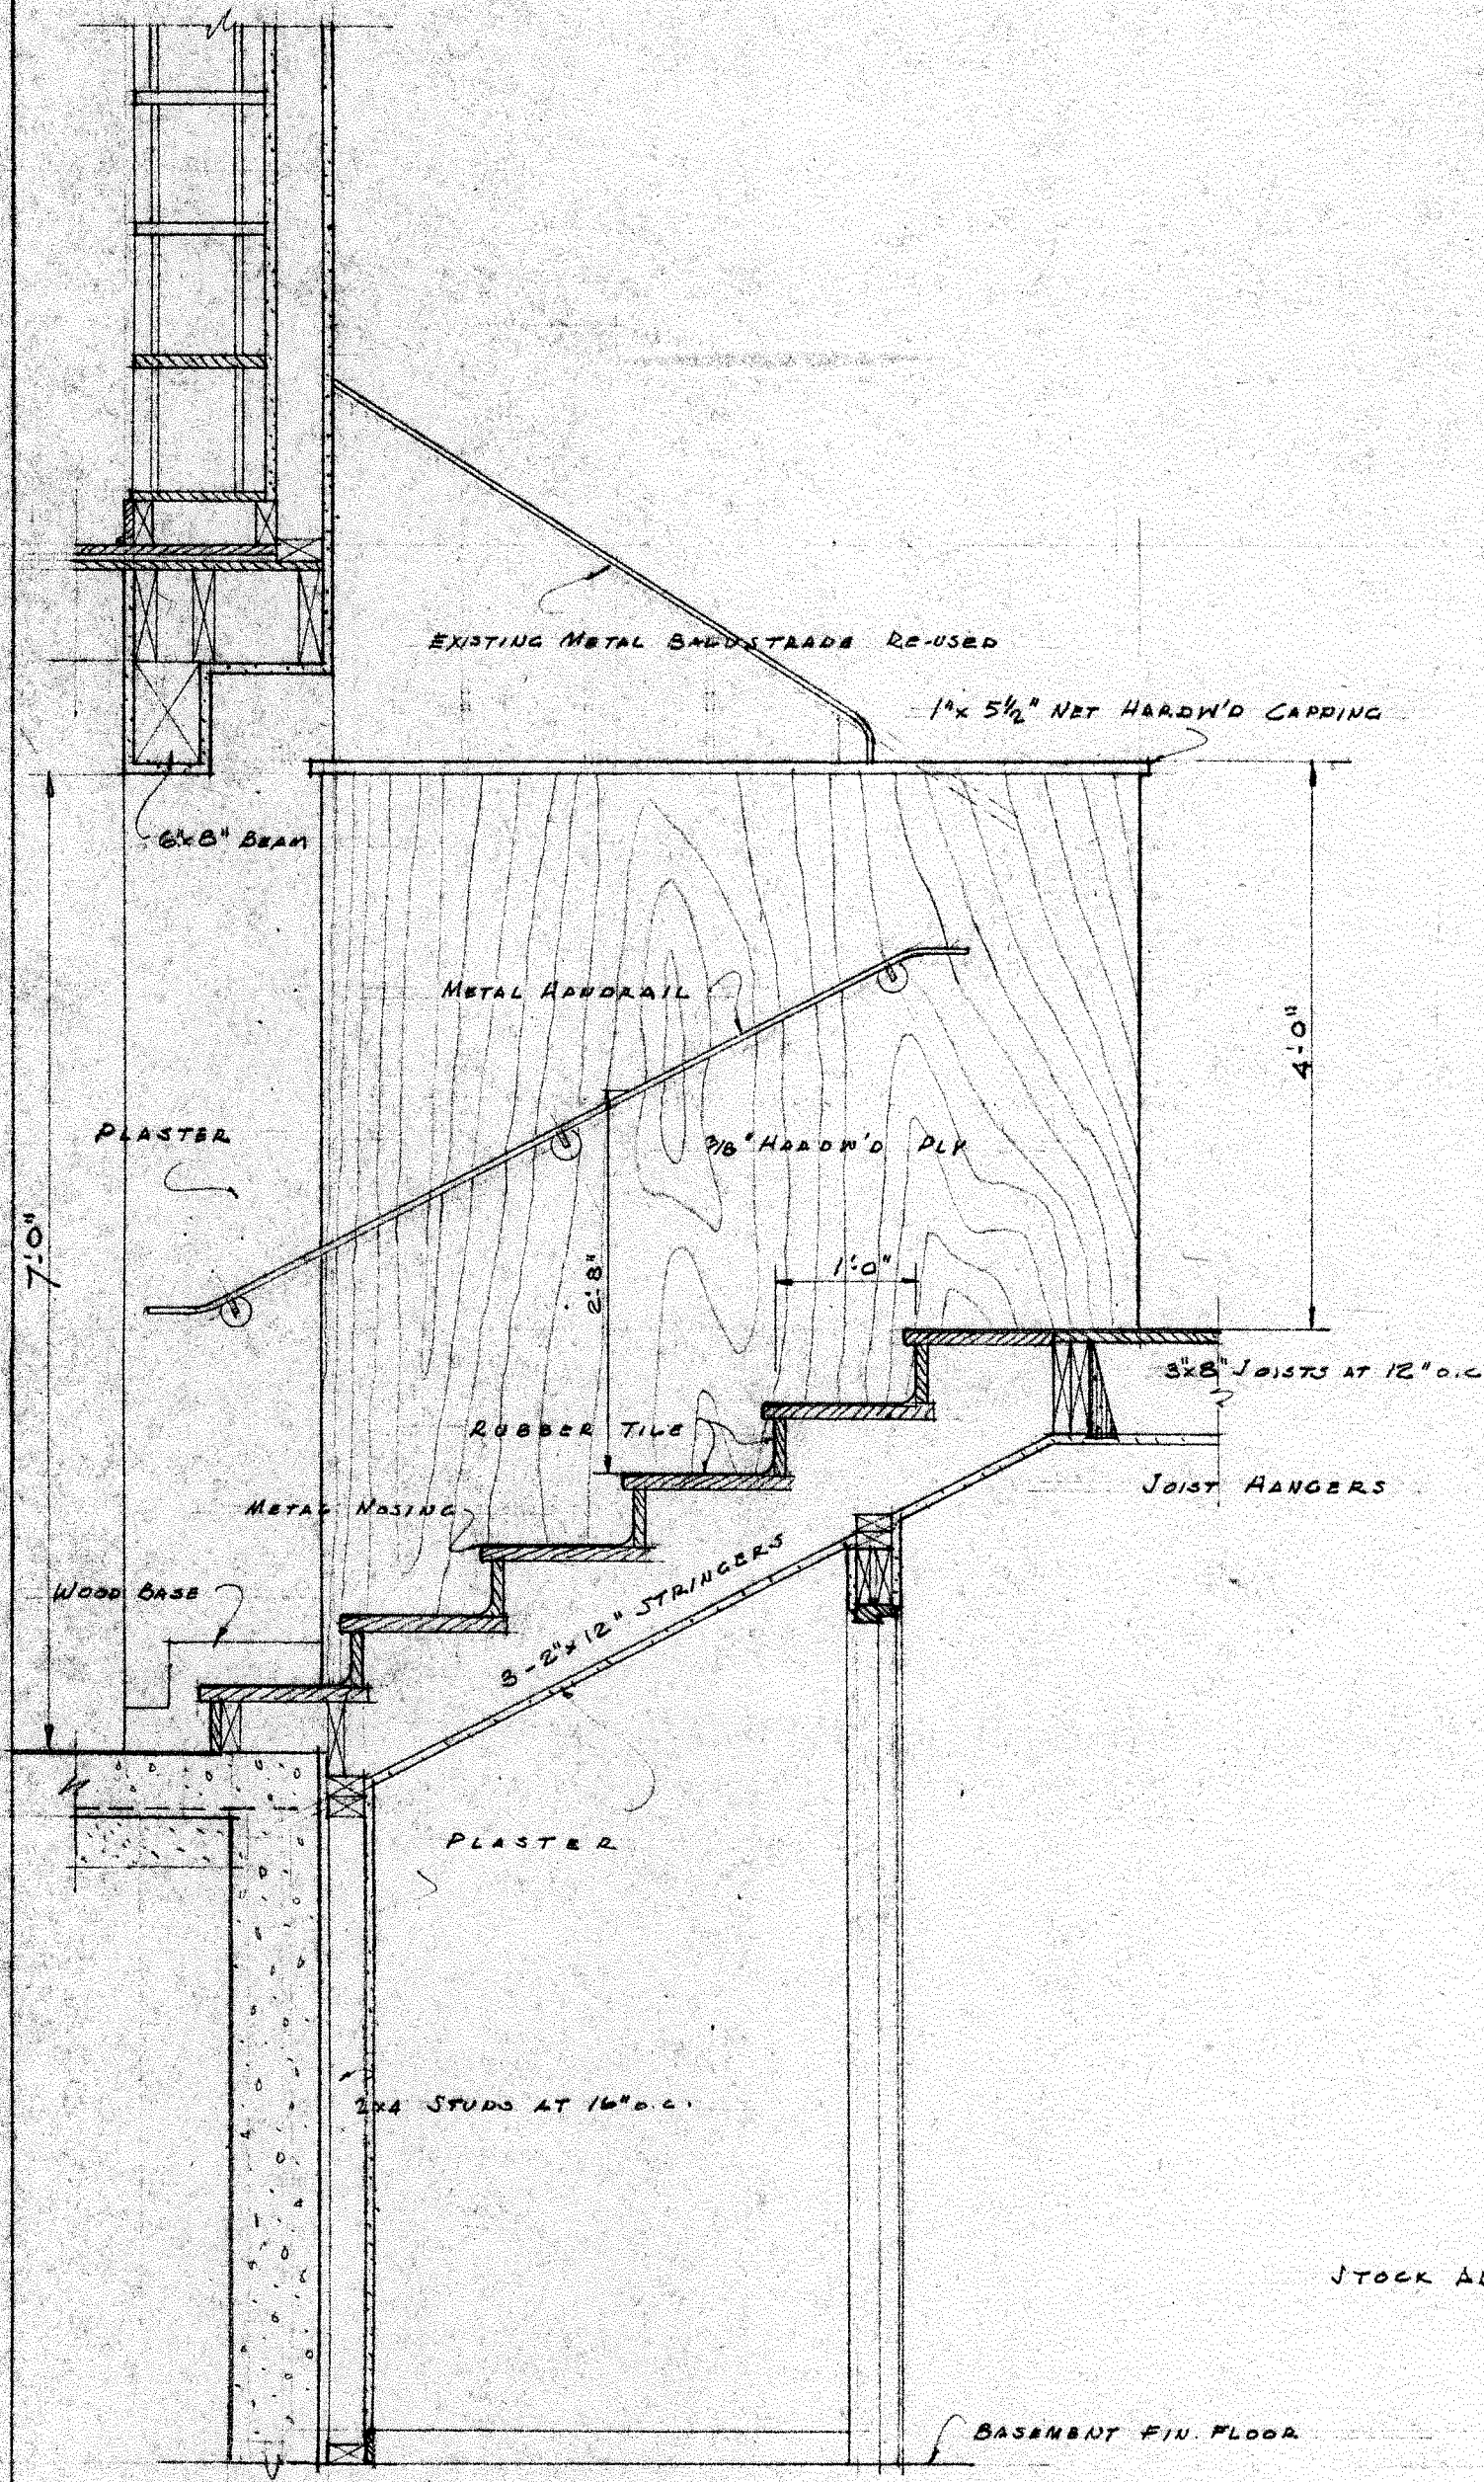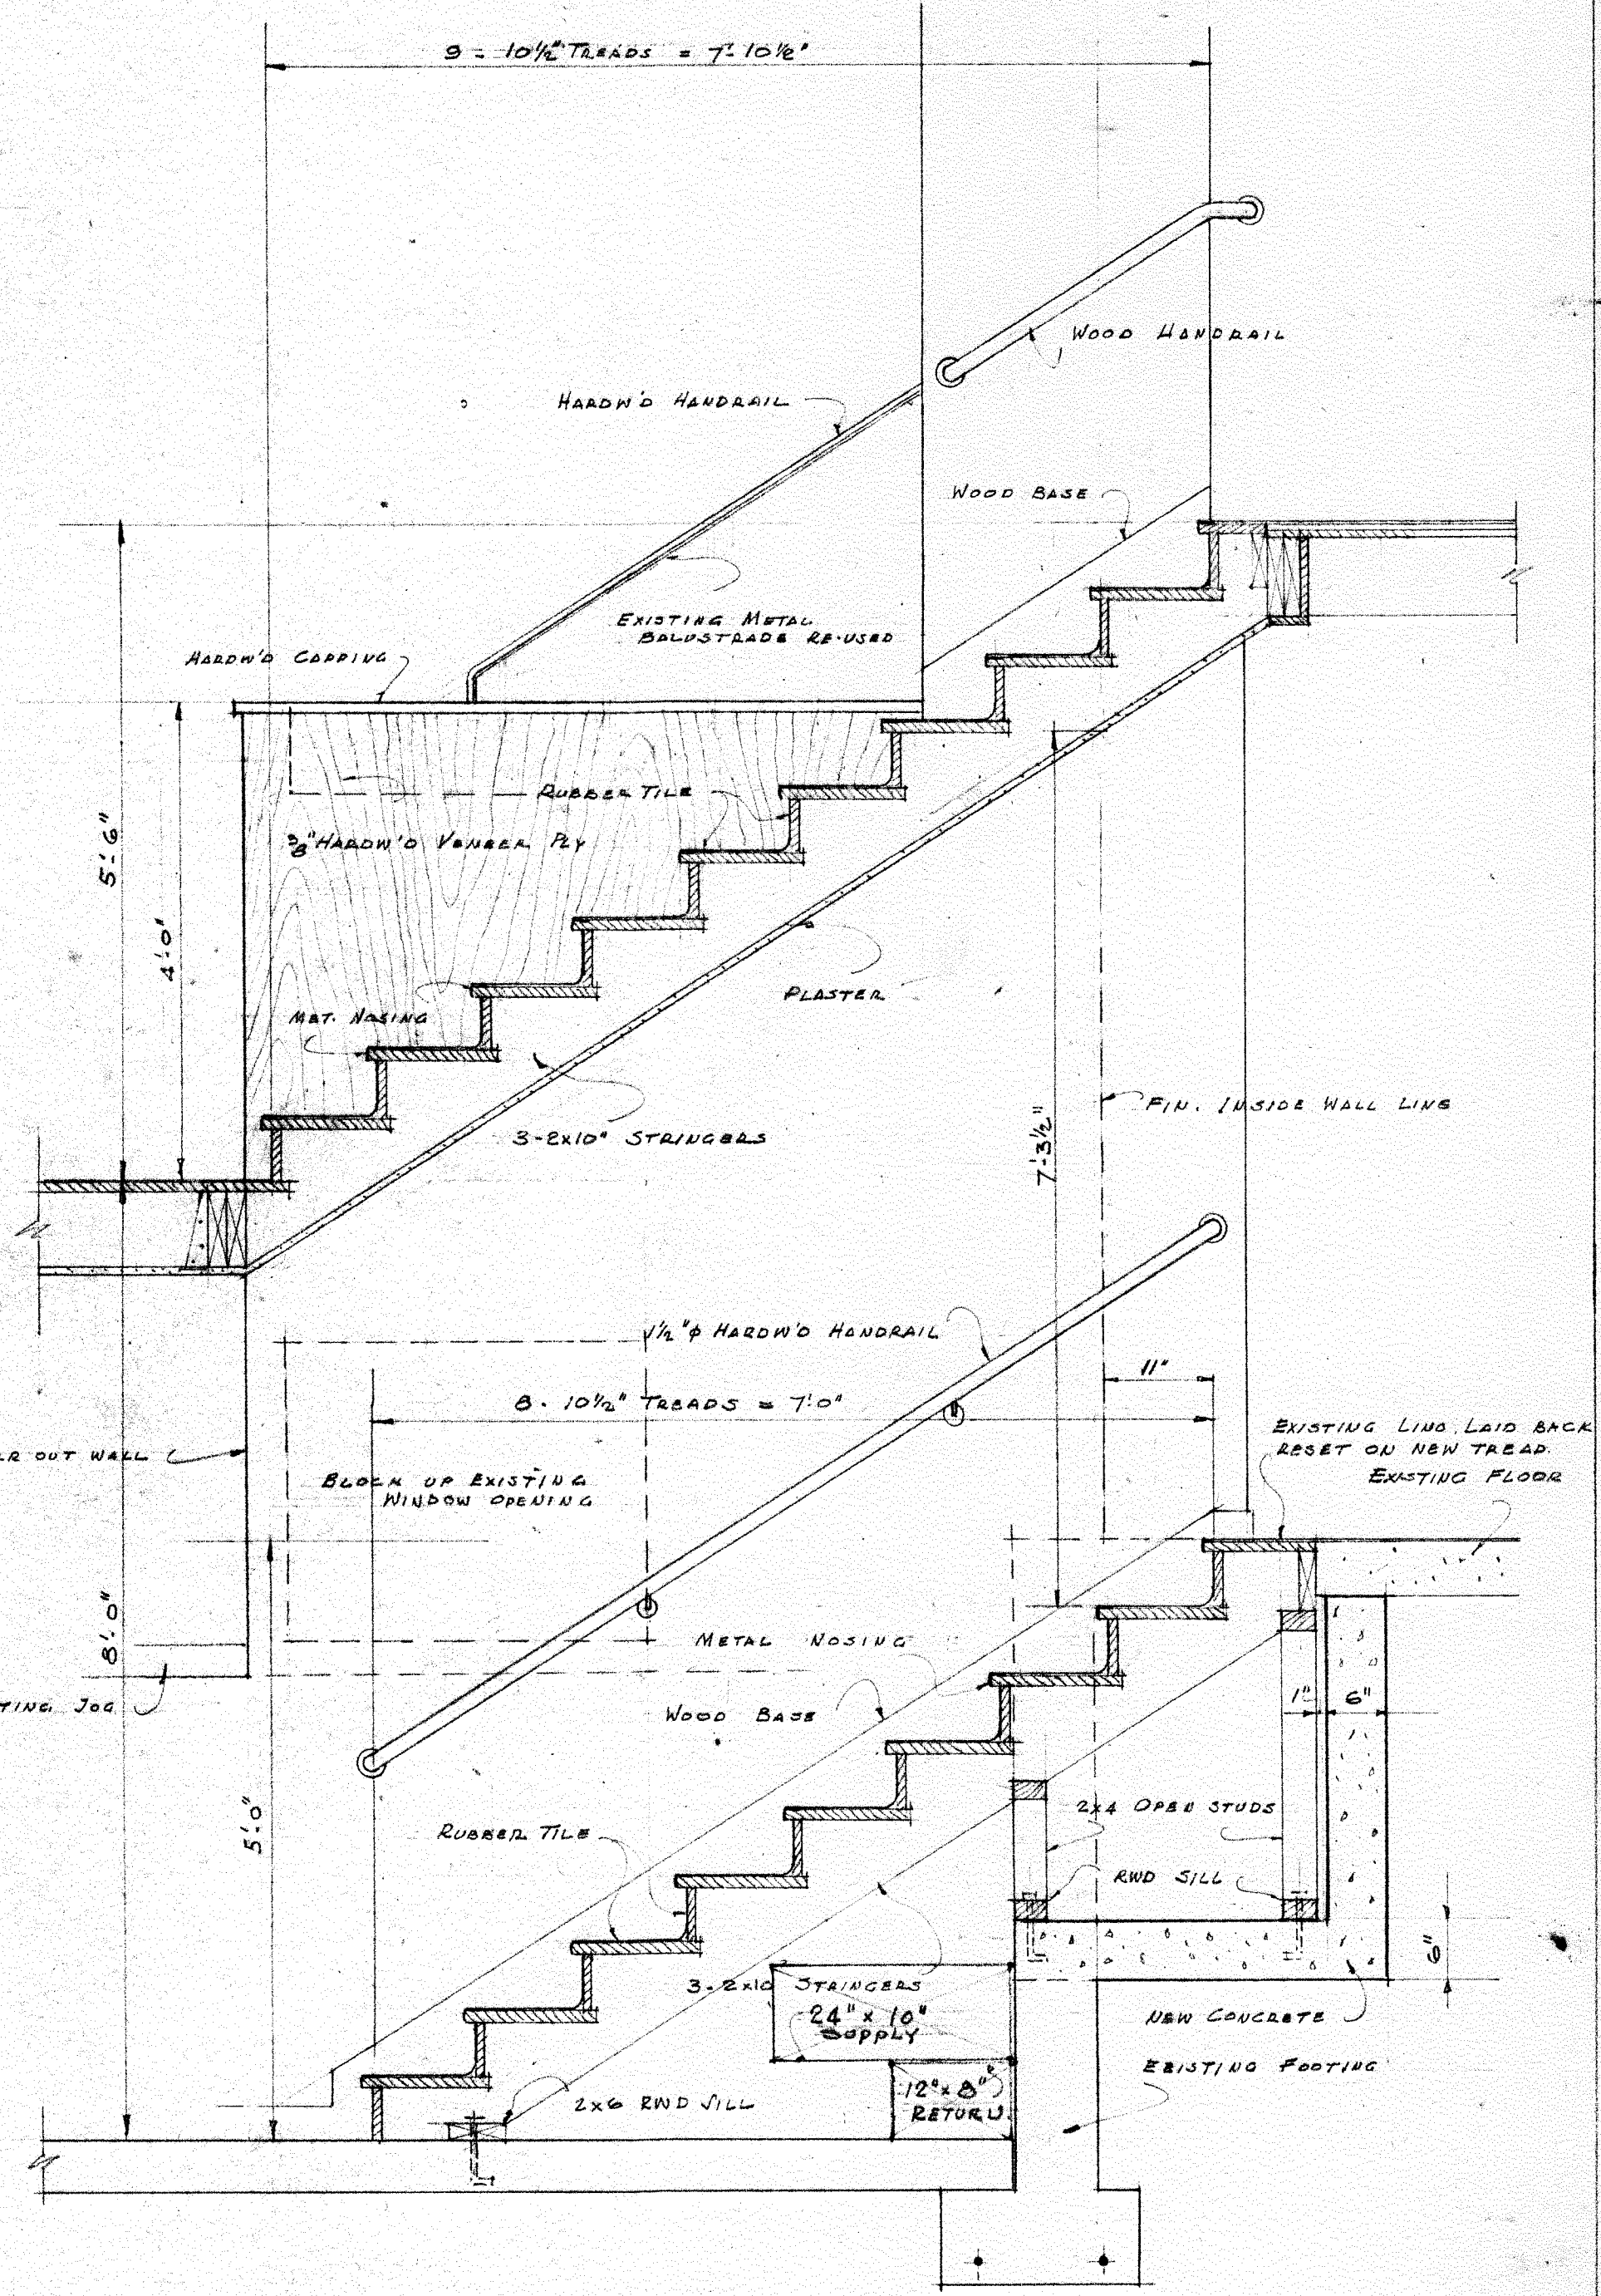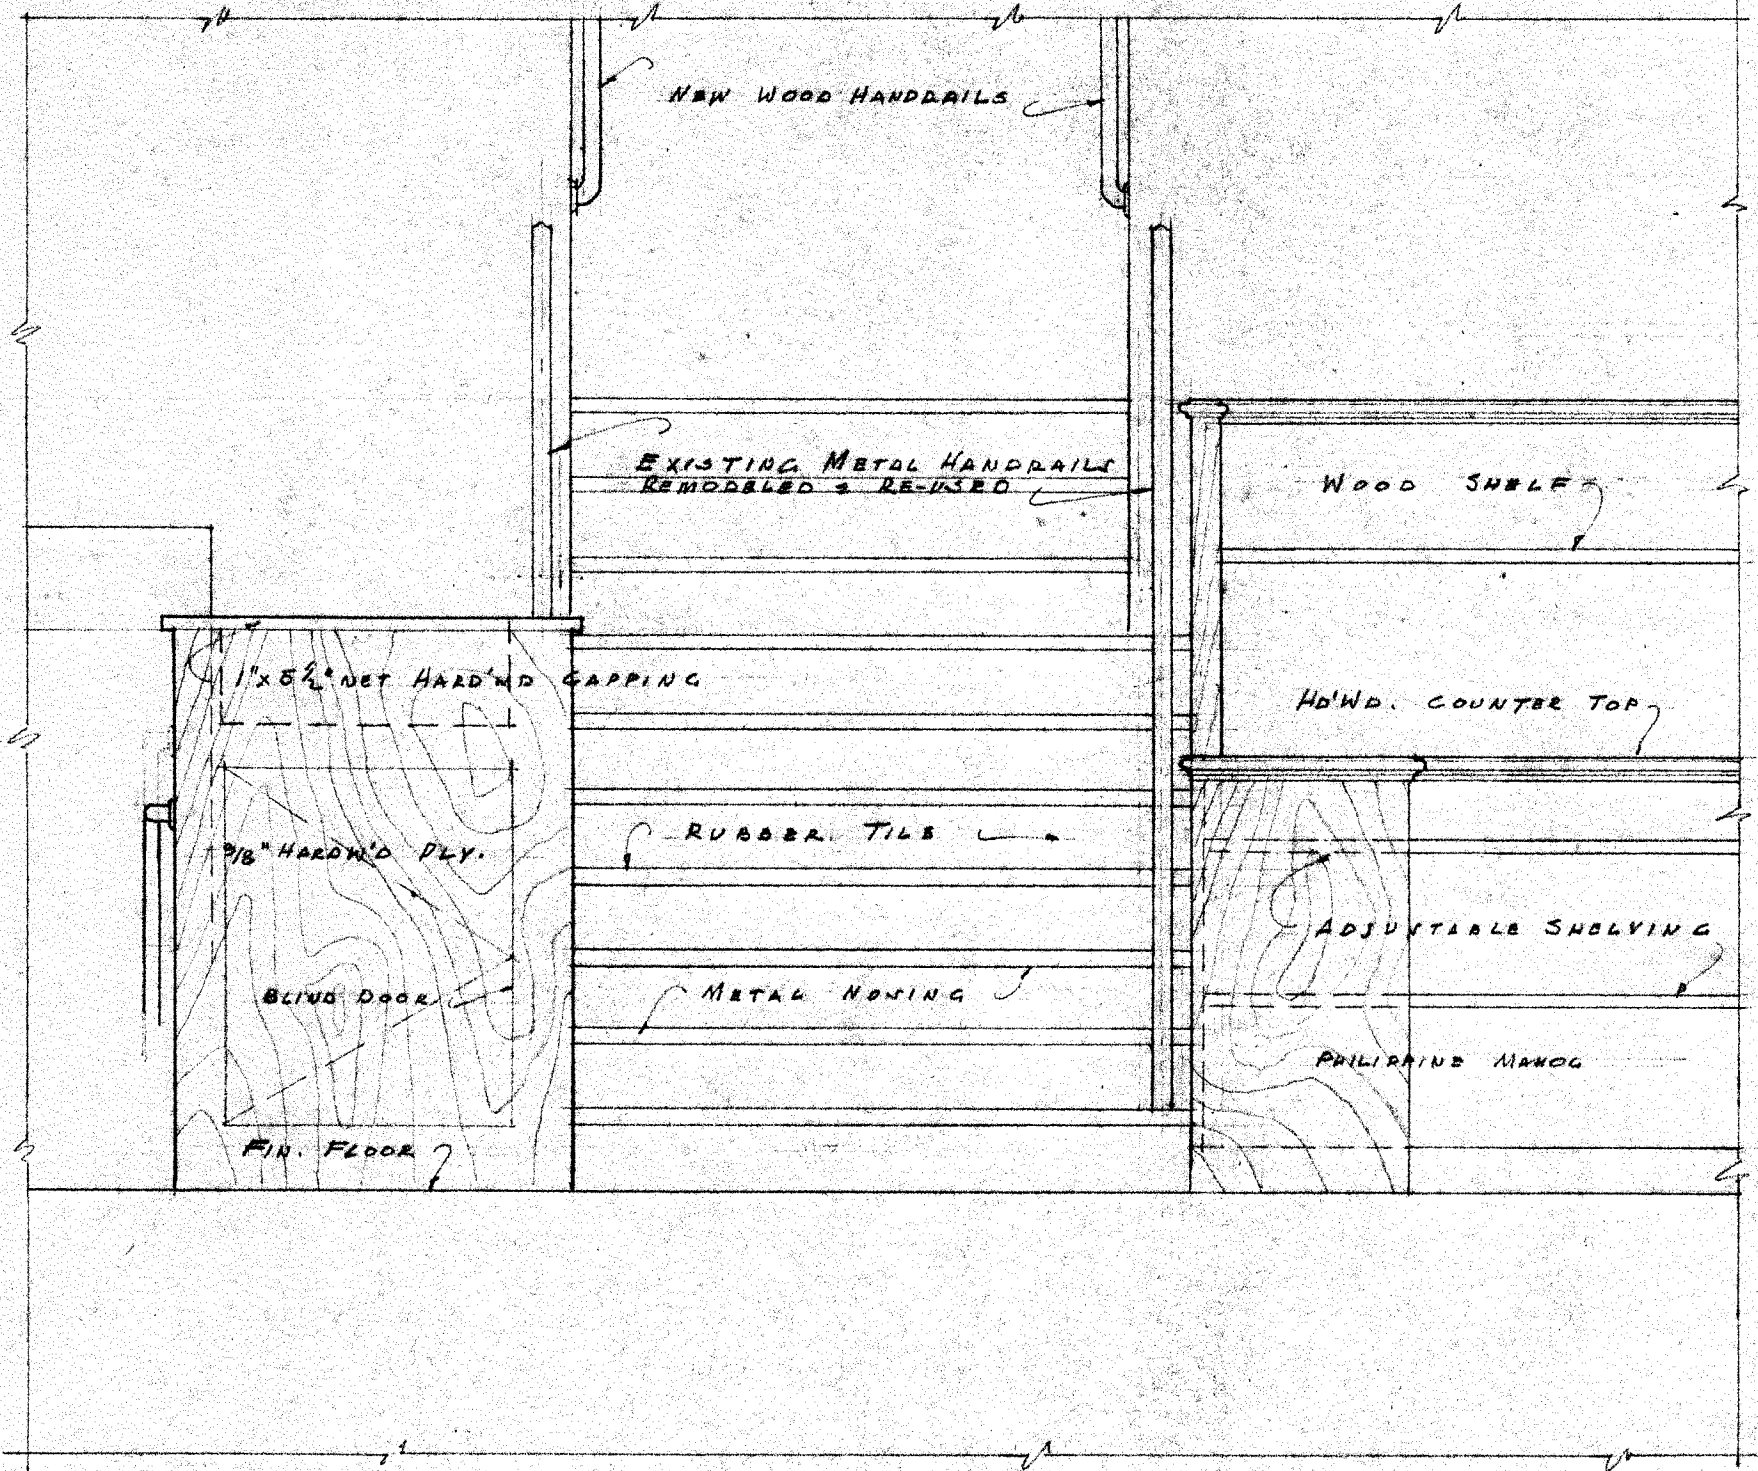



F.S.D. STAIR NOSING & COVE

SCALE 3/4" = 1'-0"


6	ALTERATIONS & ADDITIONS	JOB NO.	4820
5	HARRISON MEMORIAL	DRWG BY	SJS
4	CARMEL LIBRARY CALIFORNIA	CHK. BY	H.T.S.
3		SHEET	8
2	ROBERT R. JONES, ARCHITECT	OF	8
1	BOX 927 - CARMEL, CALIFORNIA - PHONE 347		
Date	By	Rev	
7/29/47			

 FIXTURE SCHEDULE

A	LEADER, MODEL "LRL-440" WITH 4-48" T12 FLUORESCENT LAMPS, MOUNTING PENDANTS & 1/4" x 8" REDWD. FASCIA.	READING ROOM: BOTTOMS OF FIXTURES 12'-6" ABOVE FIN. FL. CHILDREN'S ROOM: BOTTOMS OF FIXTURES 8'-0" ABOVE FIN. FL.
B	ALL-BRIGHT, MODEL "RUL-404" WITH LOUVER BOTTOM, 4-40 WATT 48" FLUORESCENT LAMPS, GLASS SIDE PANELS & MOUNTING PENDANTS.	LOBBY & REFERENCE ROOM: BOTTOMS OF FIXTURES 9'-0" ABOVE FIN. FL.
C	ALL-BRIGHT, "XUG-296" - WITH FLUORESCENT TUBES	CEILING MOUNTED: 
D	ALL-BRIGHT, "XUG-272" - WITH FLUORESCENT TUBES.	SAME
E	LEADER, MODEL "NHT-280" RECESSED TROFFER, 2-96" SLIMLINE TUBES, MOULDED PLASTIC LOUVERS	SAME
F	LEADER, MODEL "NHT-280" RECESSED TROFFER, 2-72" SLIMLINE TUBES, MOULDED PLASTIC LOUVERS.	SAME
G	LEADER, MODEL "NHT-280" RECESSED TROFFER, 1-96" SLIMLINE TUBE, MOULDED PLASTIC LOUVERS.	SAME
H	LEADER, MODEL "TS-240", 3-40-WATT, 48" LAMPS, MOULDED PLASTIC LOUVERS	SAME
J	ALL-BRIGHT, MODEL "RUL-1002" WITH LOUVER BOTTOM, 2-40 WATT 48" FLUORESCENT TUBES & MOUNTING PENDANTS.	BOTTOMS OF FIXTURES 9'-0" ABOVE FIN. FLOOR.

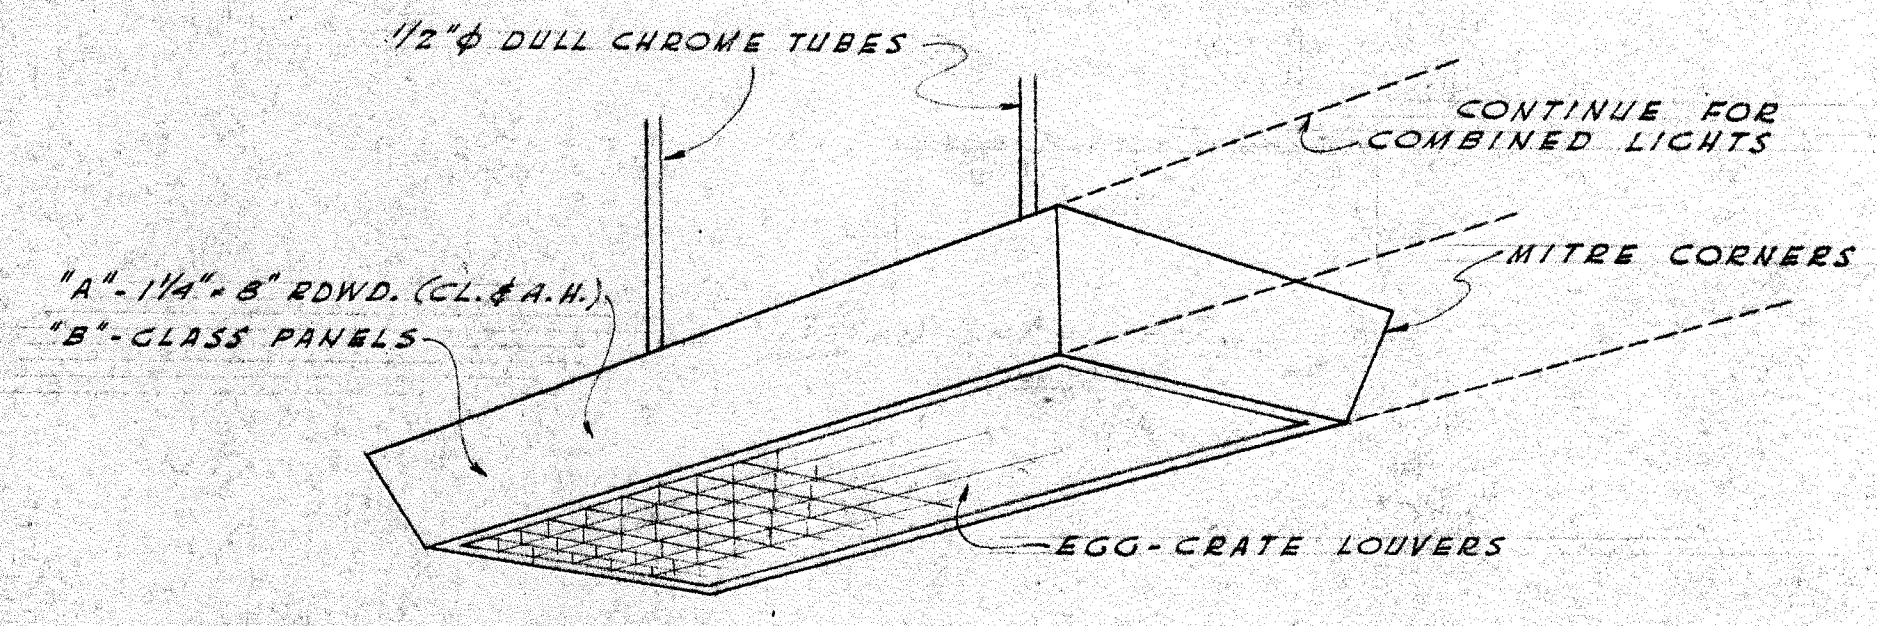

PERSPECTIVE SKETCH OF FIXTURE

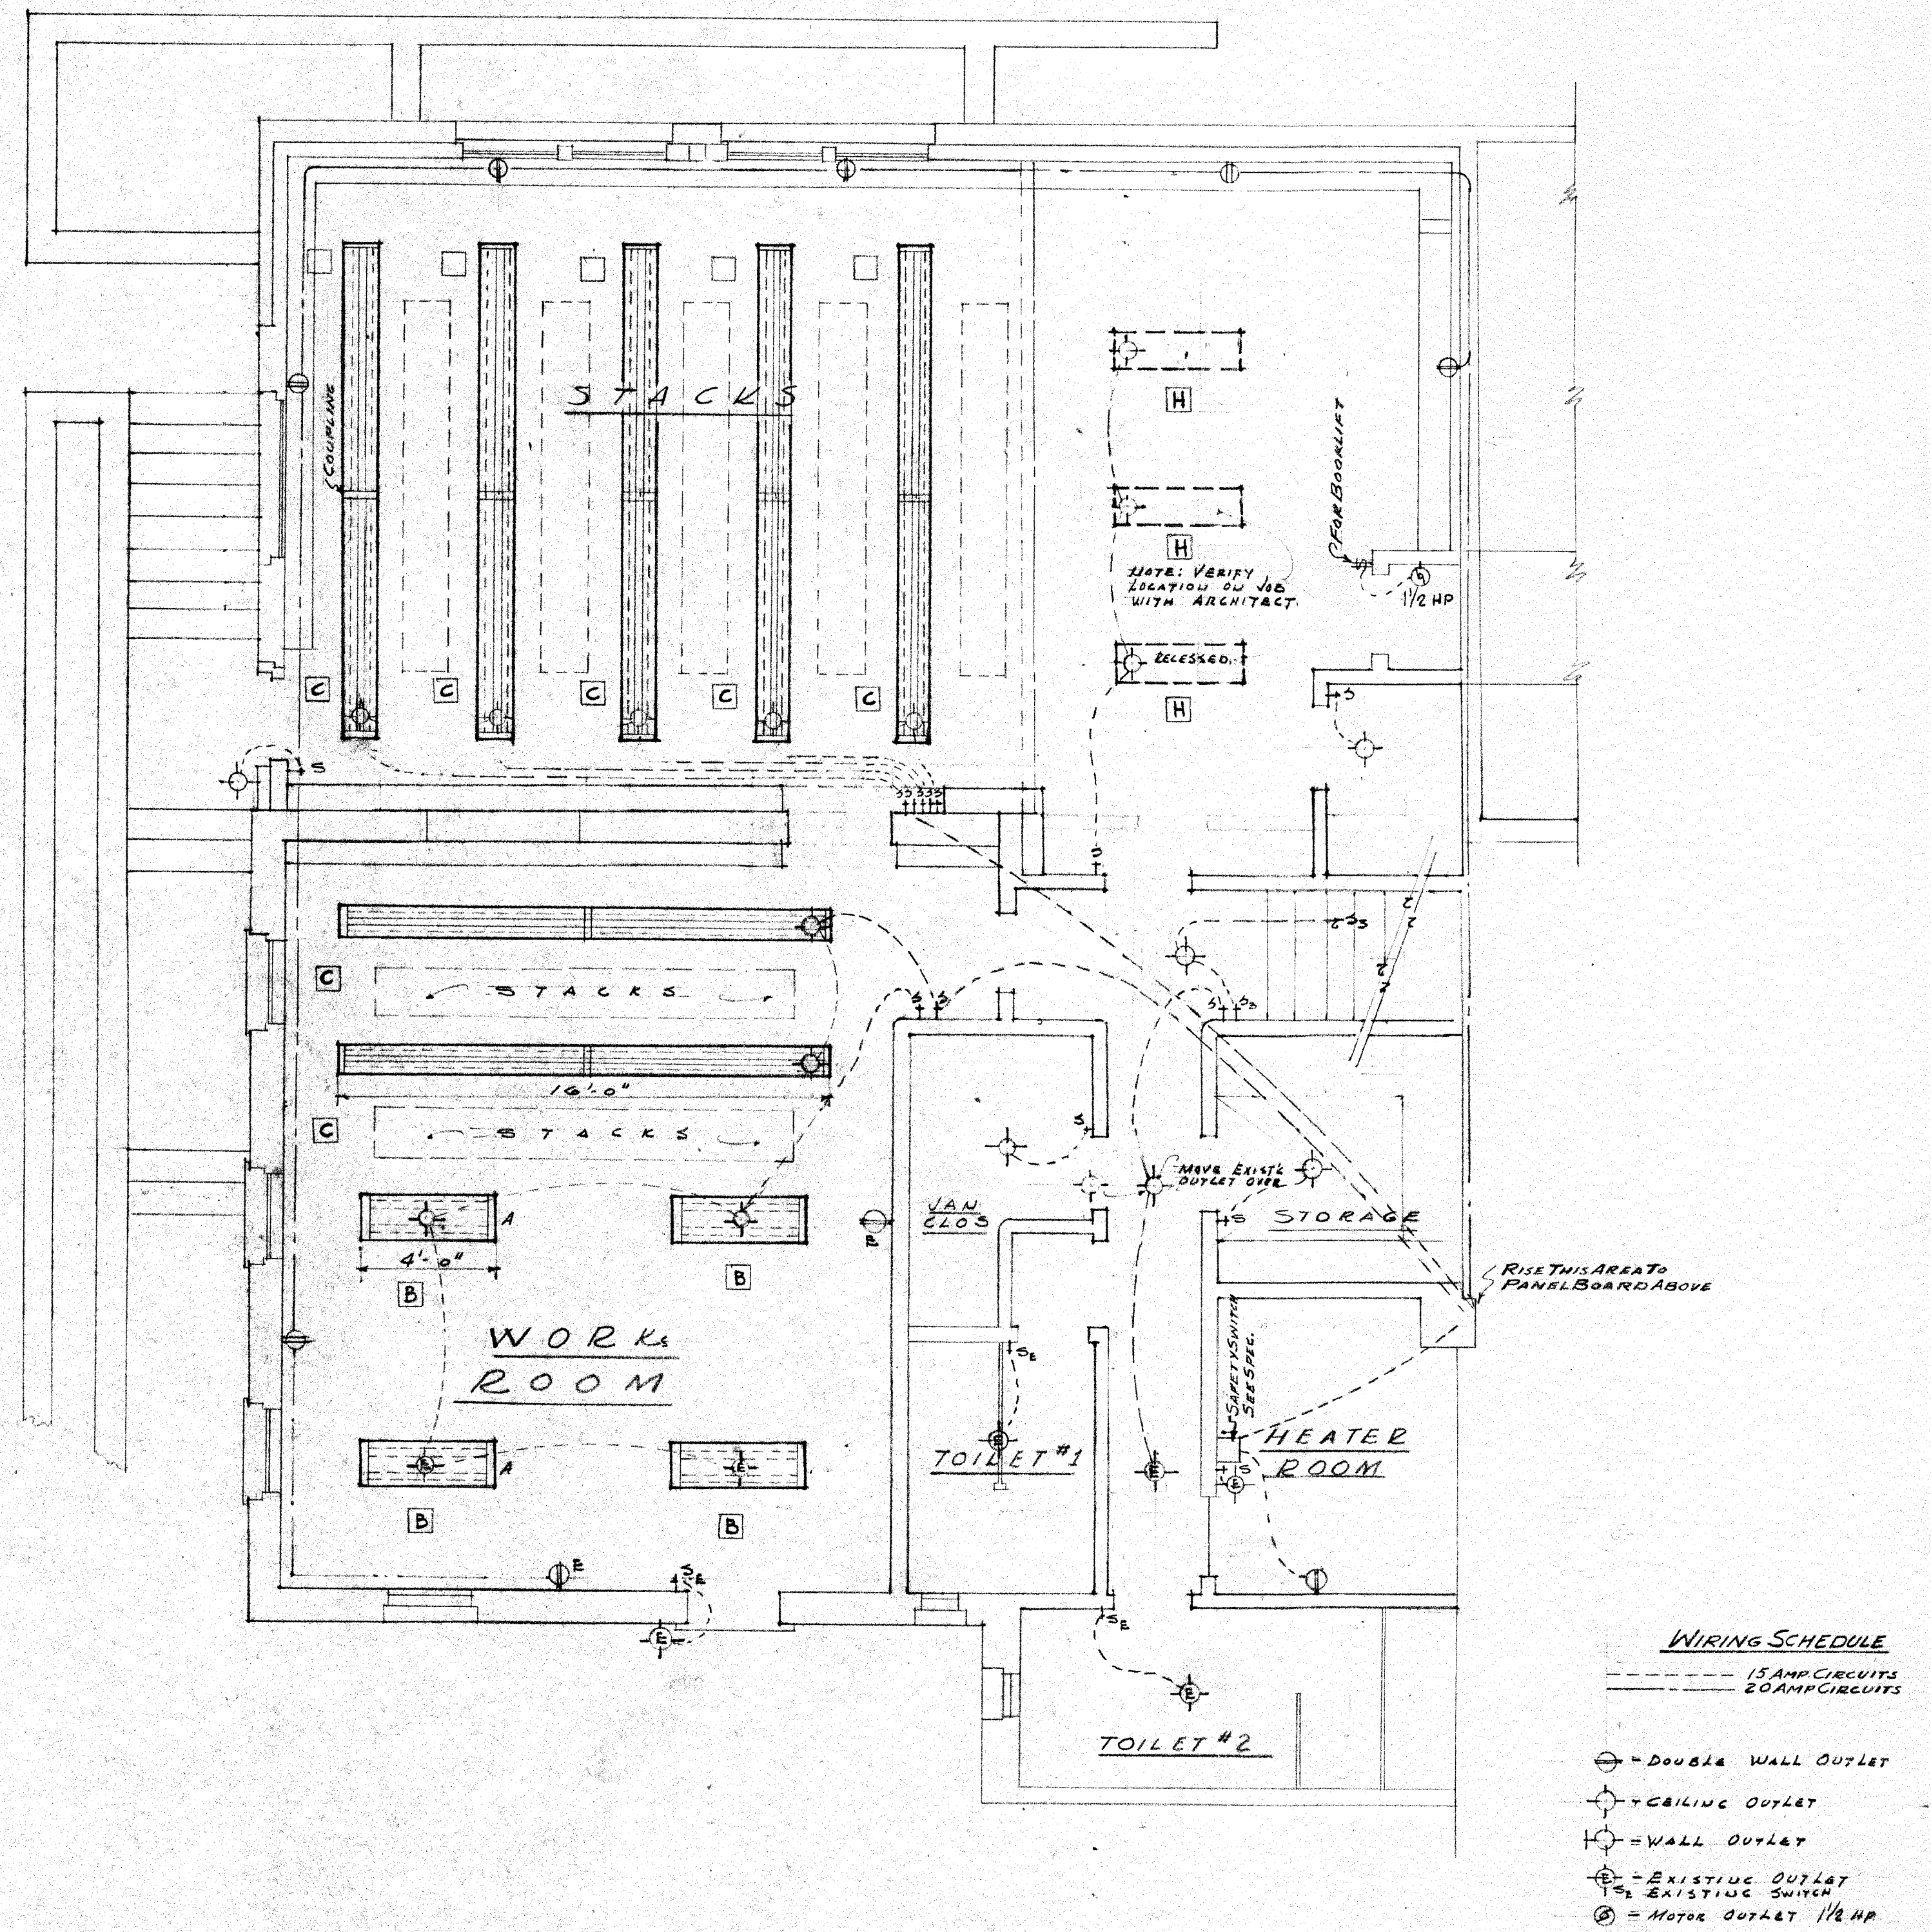

WIRING SCHEDULE


--- 15 AMP CIRCUITS
--- 20 AMP CIRCUITS

- = DOUBLE WALL OUTLET
- = CEILING OUTLET
- = WALL OUTLET
- = EXISTING OUTLET
- = EXISTING SWITCH
- = MOTOR OUTLET 1/2 HP


BASEMENT PLAN SCALE 1/4" = 1'-0"

NOTE: EXISTING OUTLETS & SWITCHES MARKED "E" ARE SHOWN FOR INFORMATION AND ARE TO REMAIN.


6	WIRING & LIGHTING LAYOUT	JOB NO.	4820
5	HARRISON MEMORIAL LIBRARY	DRWG BY	W.M.
4	CARMEL CALIF.	CHK. BY	RT.S.
3		SHEET	E-1
2	ROBERT R. JONES, ARCHITECT	OF 2	
1	BOX 927 - CARMEL, CALIFORNIA - PHONE 347		
Date	By	Rev	
7/29/49			

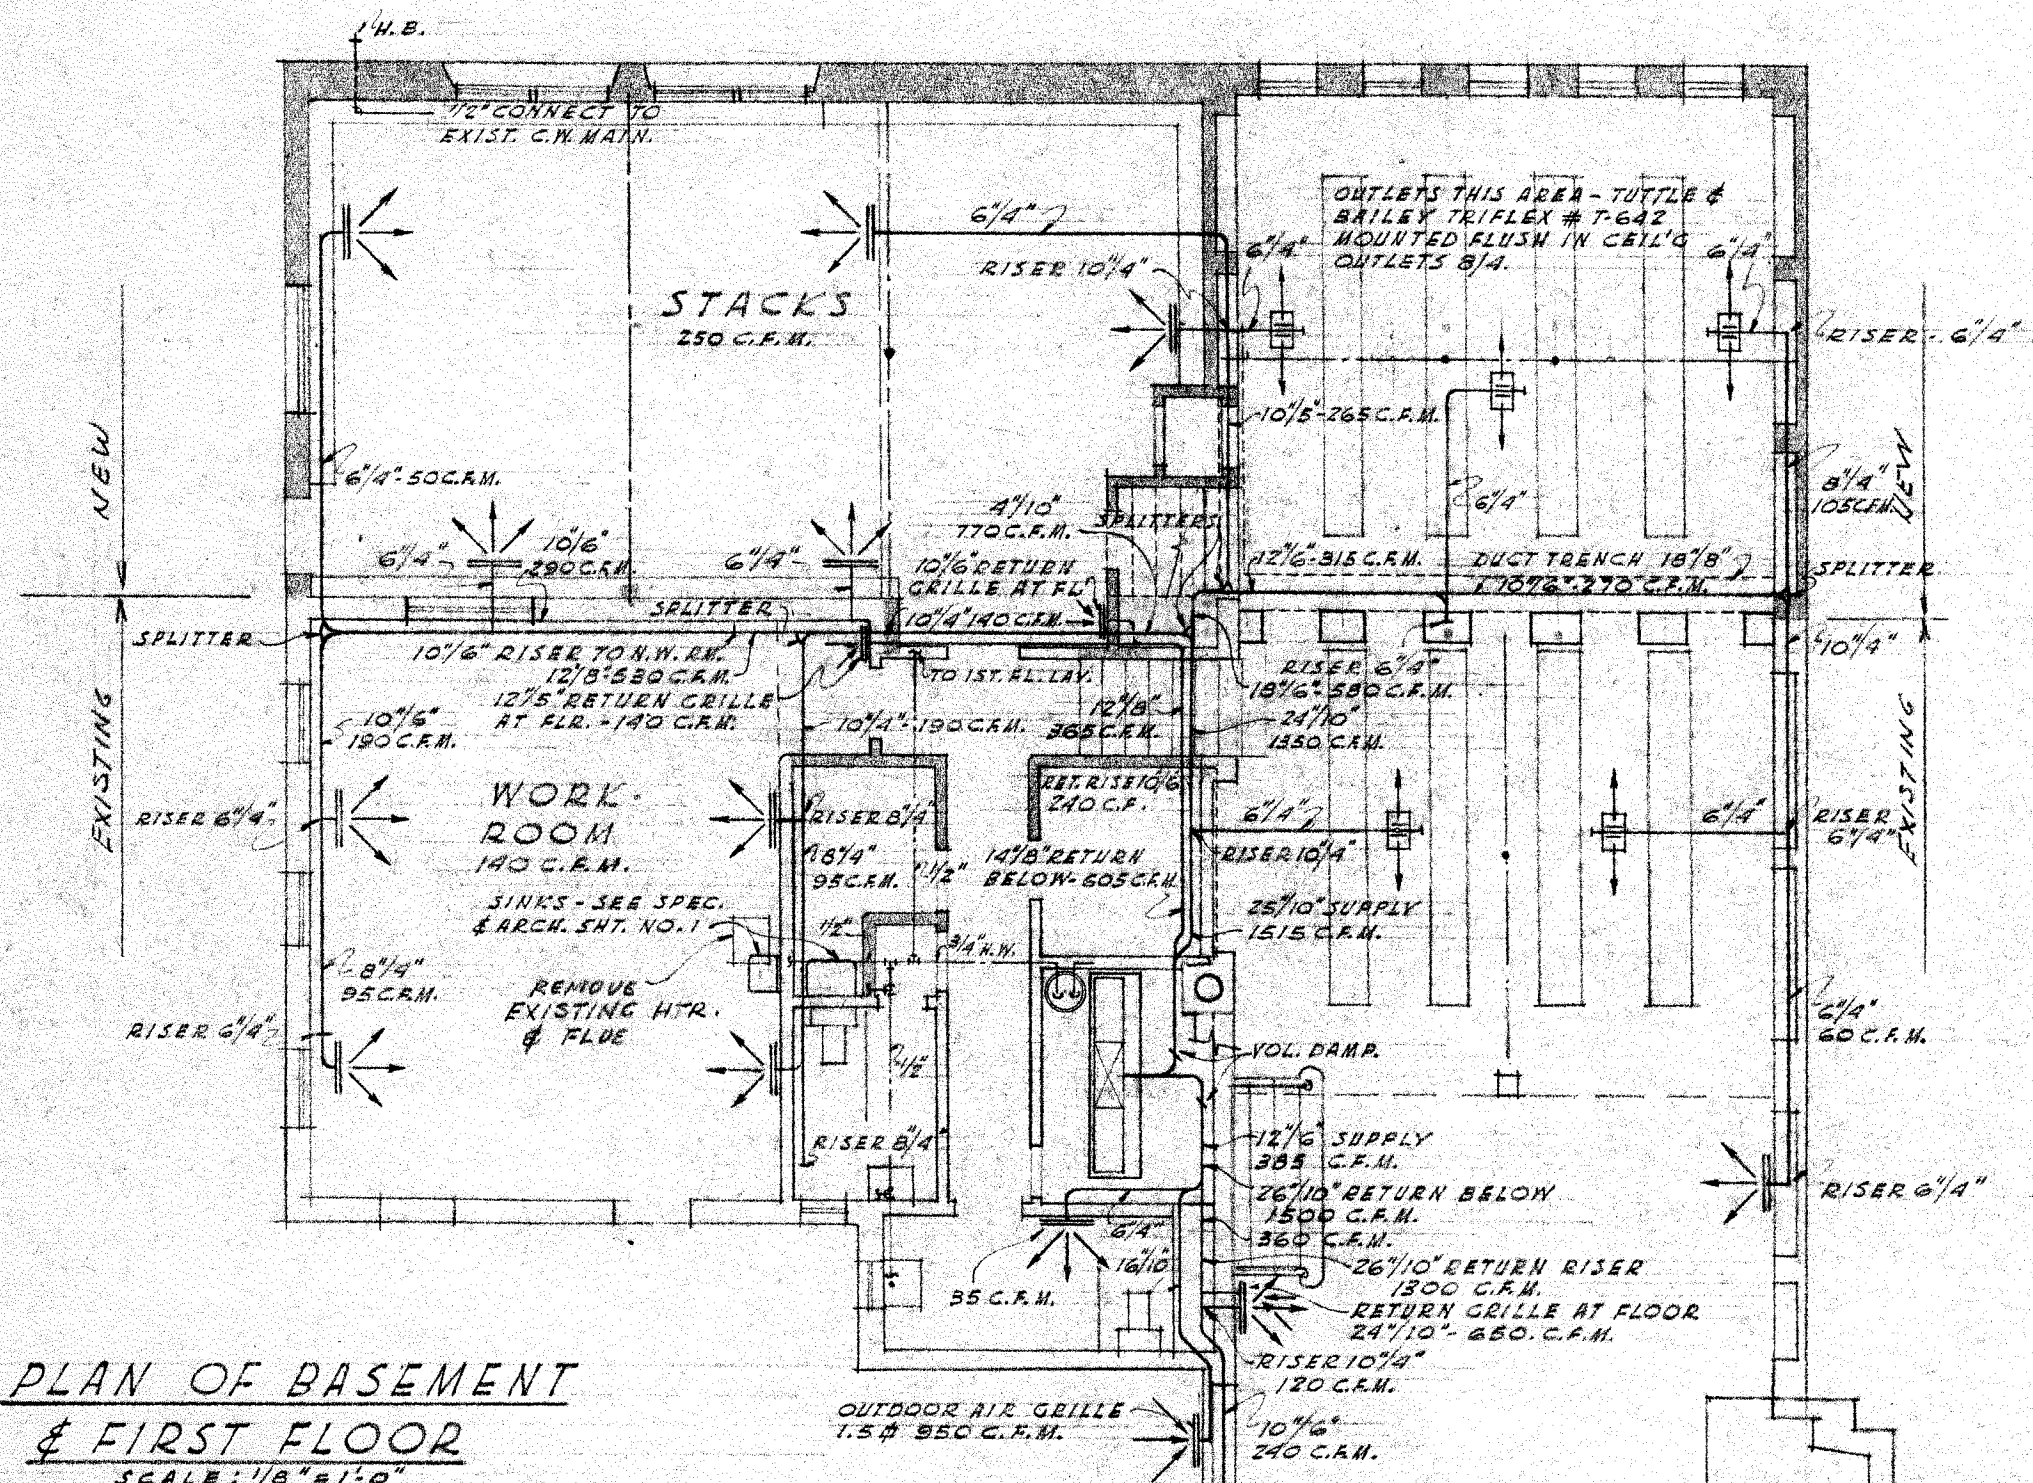


PLAN OF BASEMENT & FIRST FLOOR
SCALE: 1/8" = 1'-0"

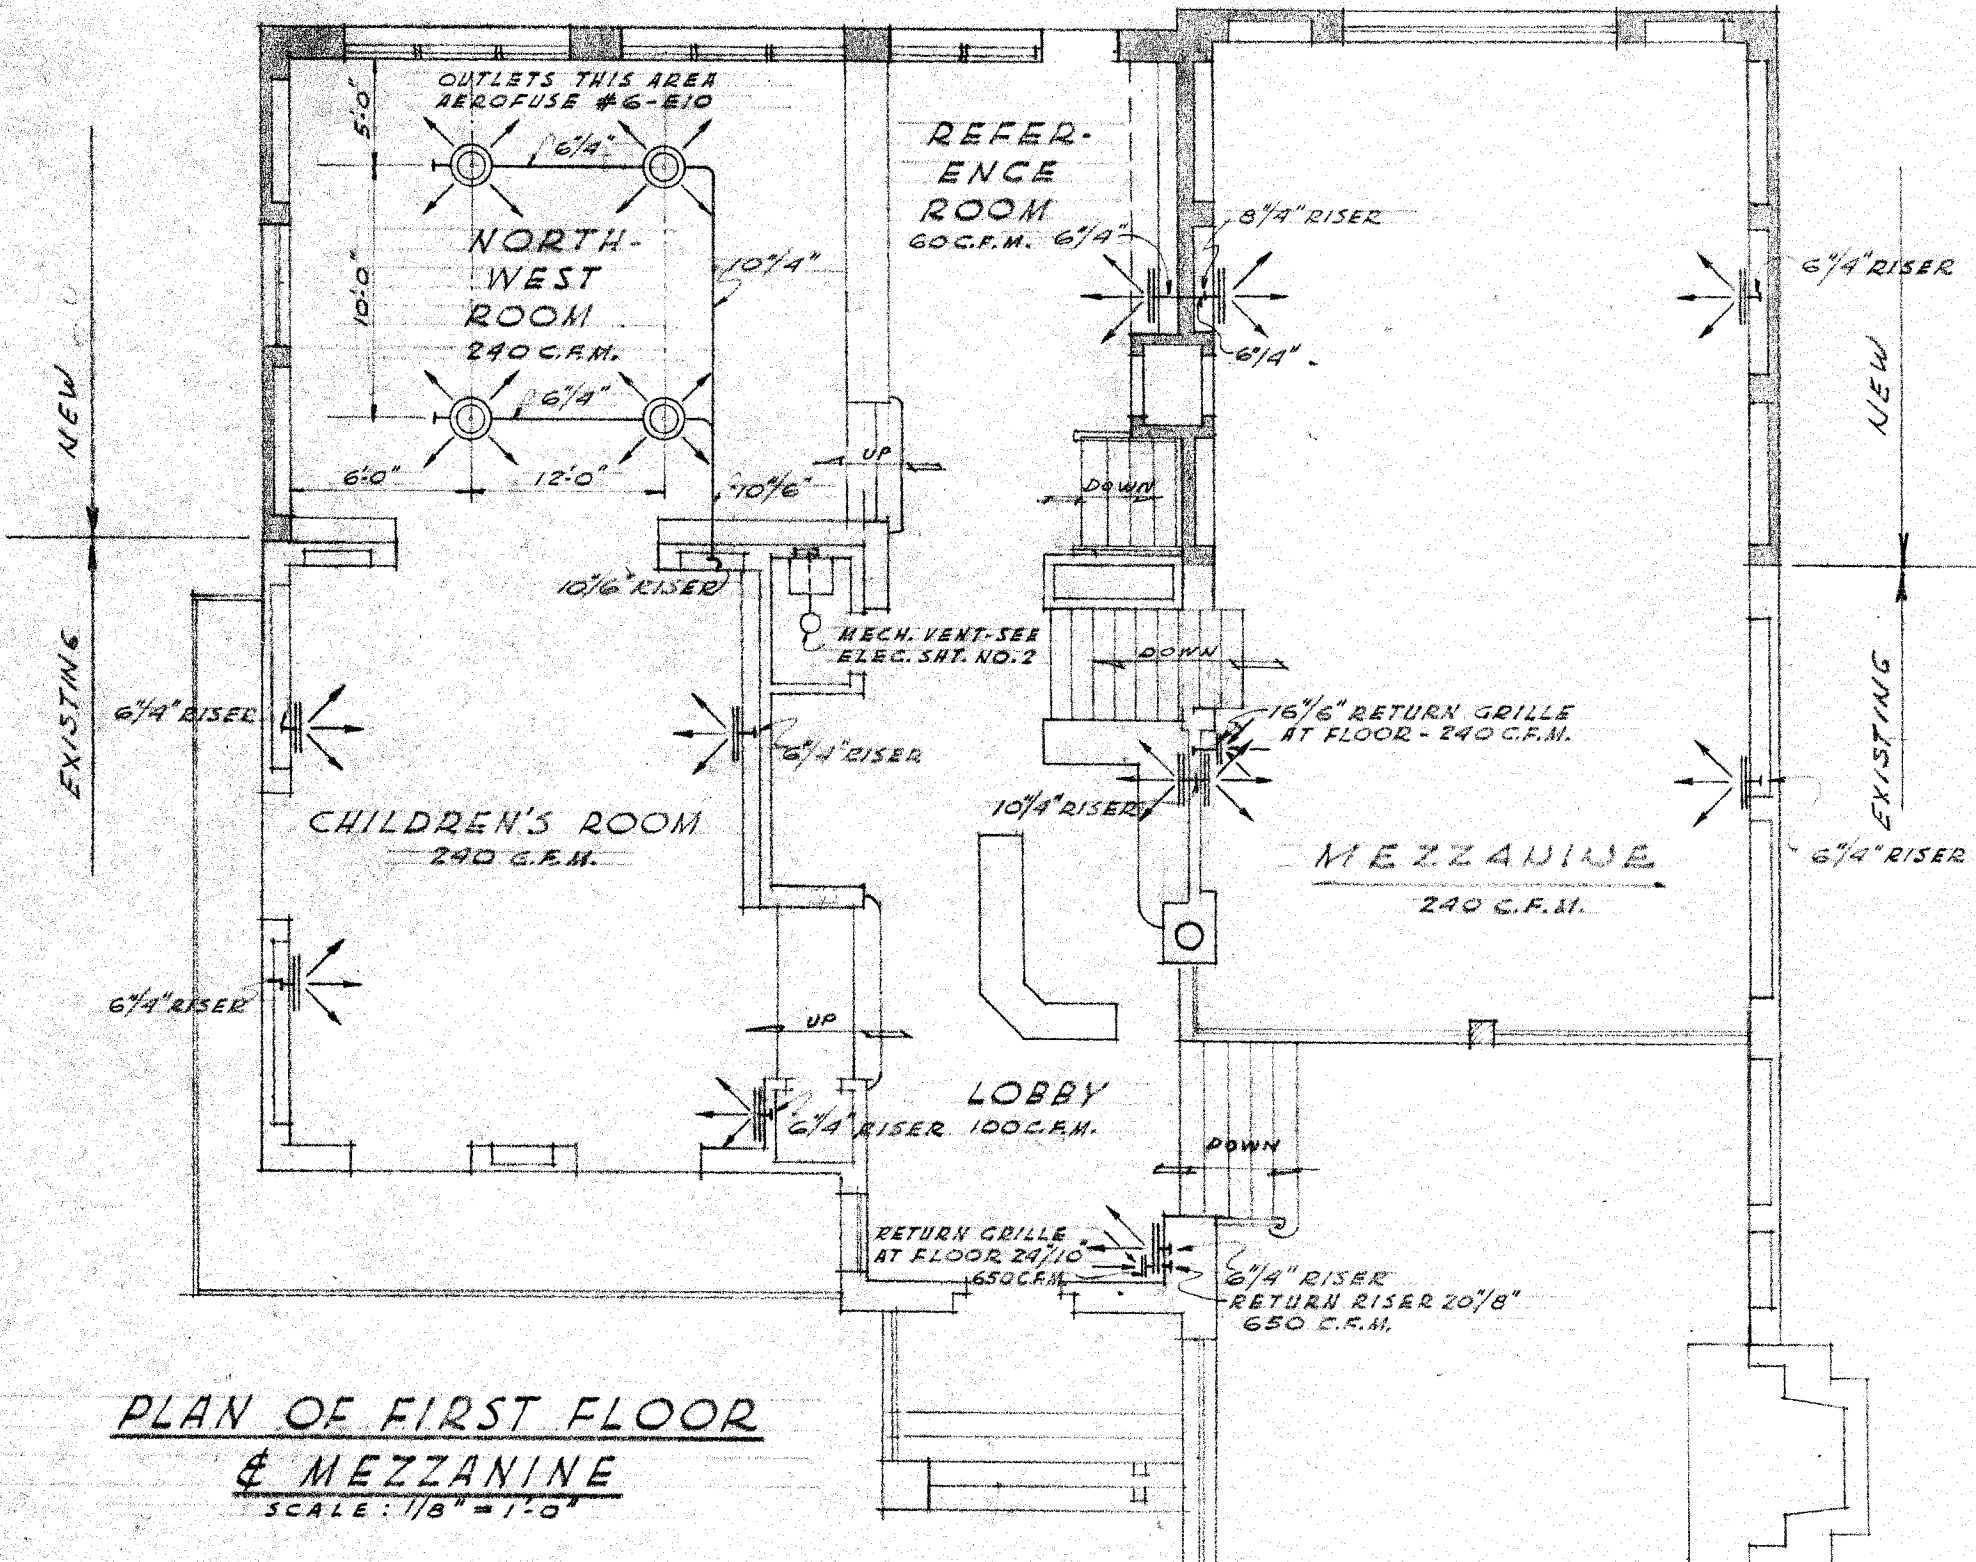

PLAN OF FIRST FLOOR & MEZZANINE
SCALE: 1/8" = 1'-0"

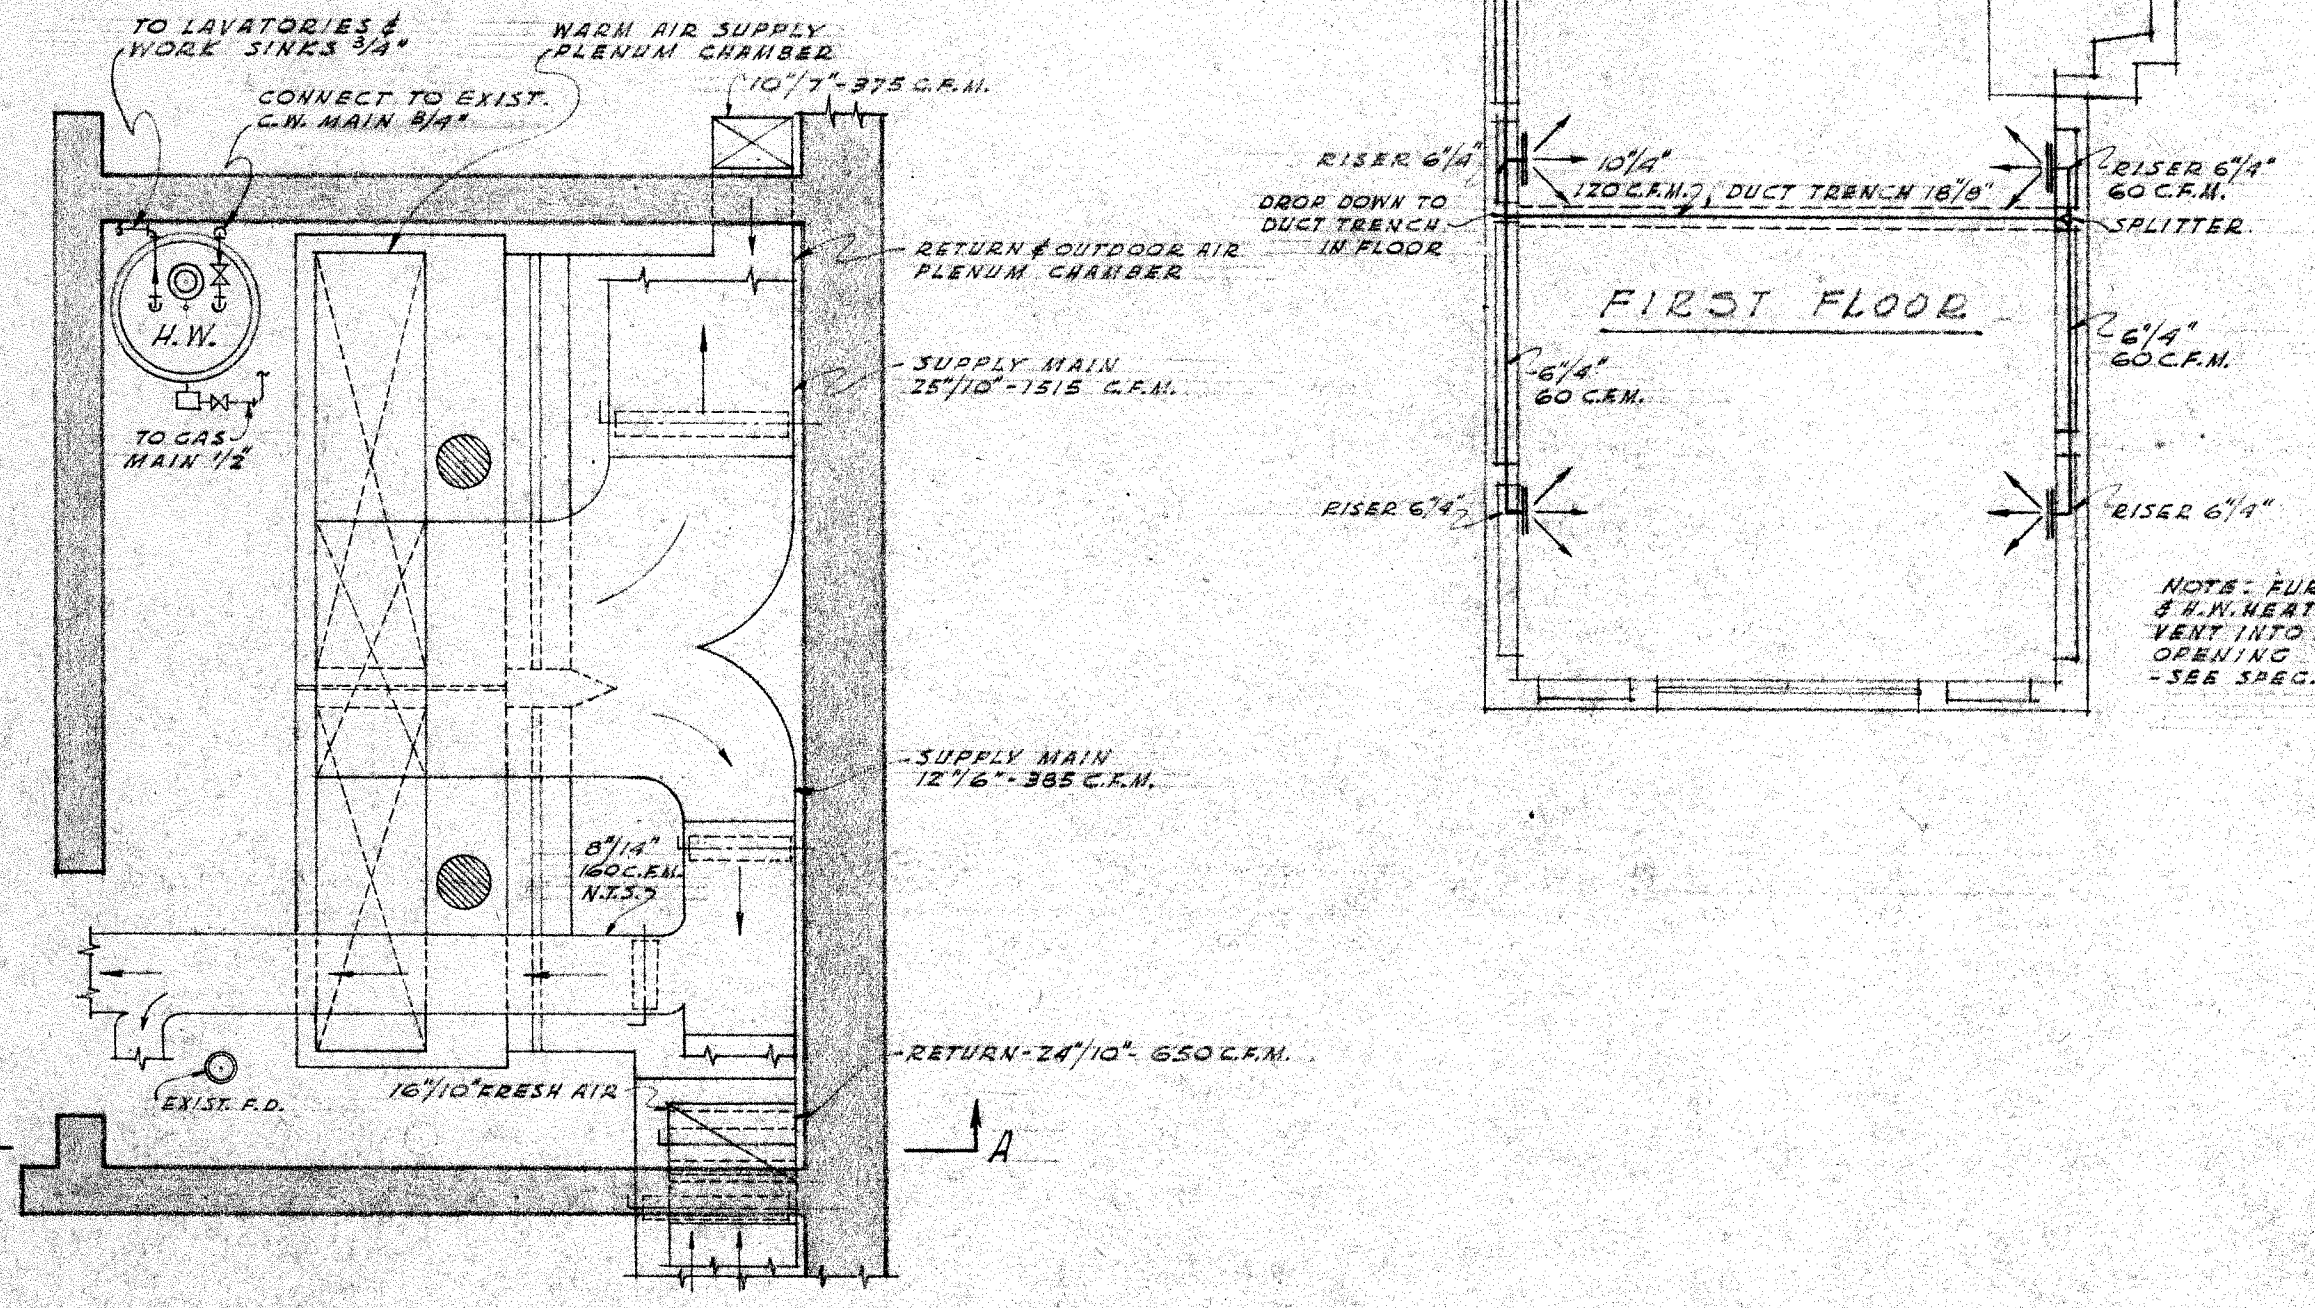

DETAIL OF FURNACE ROOM
SCALE: 1/2" = 1'-0"

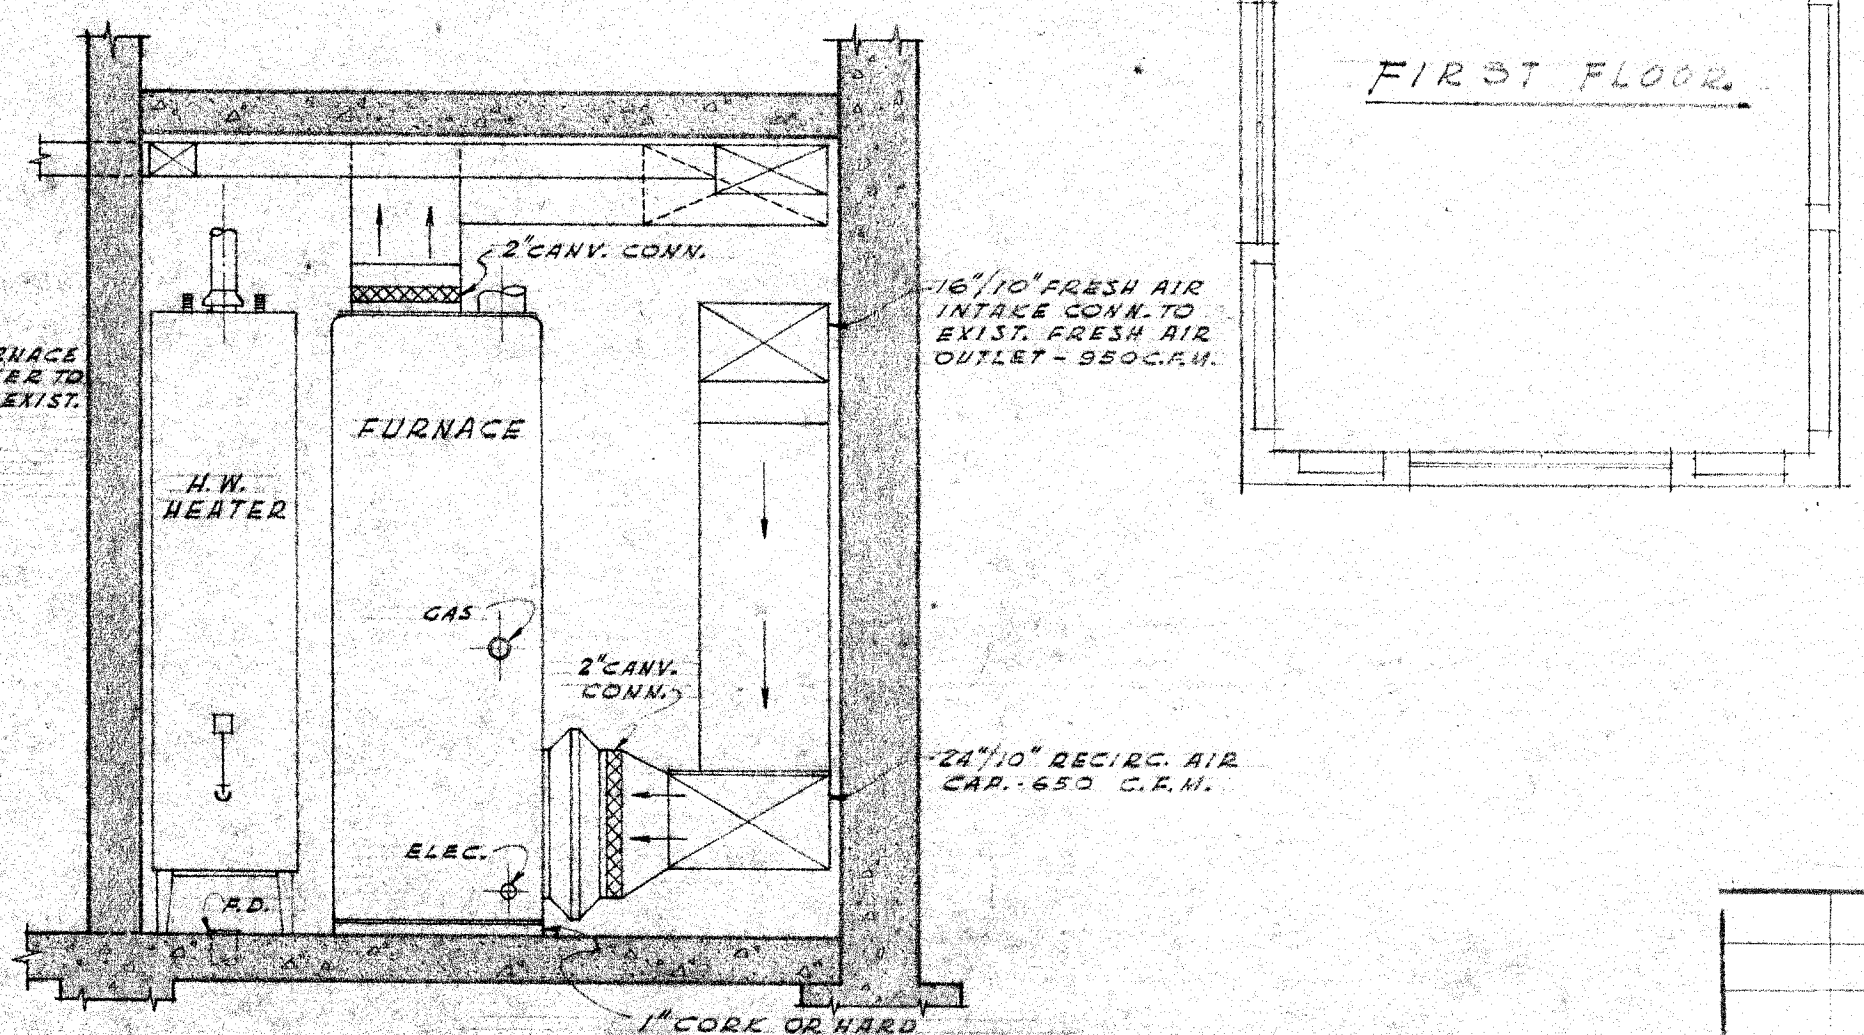

SECTION 'A-A'
SCALE: 1/2" = 1'-0"

6	ALTERATIONS & ADDITIONS	JOB NO. 4320
5	HARRISON MEMORIAL	DRWG BY S.J.S.
4	LIBRARY CALIF	CHK. BY H.T.B.
3		
2	ROBERT R. JONES, ARCHITECT	
1	BOX 927 - CARMEL, CALIFORNIA - PHONE 547	
Date	By	Rev.
7/29/49	Issued	