



NOTE: STONE WALL TO REMAIN. EXISTING FOOTING BELOW FIN. ABSEAWAY SLAB.

SIXTH AVE.

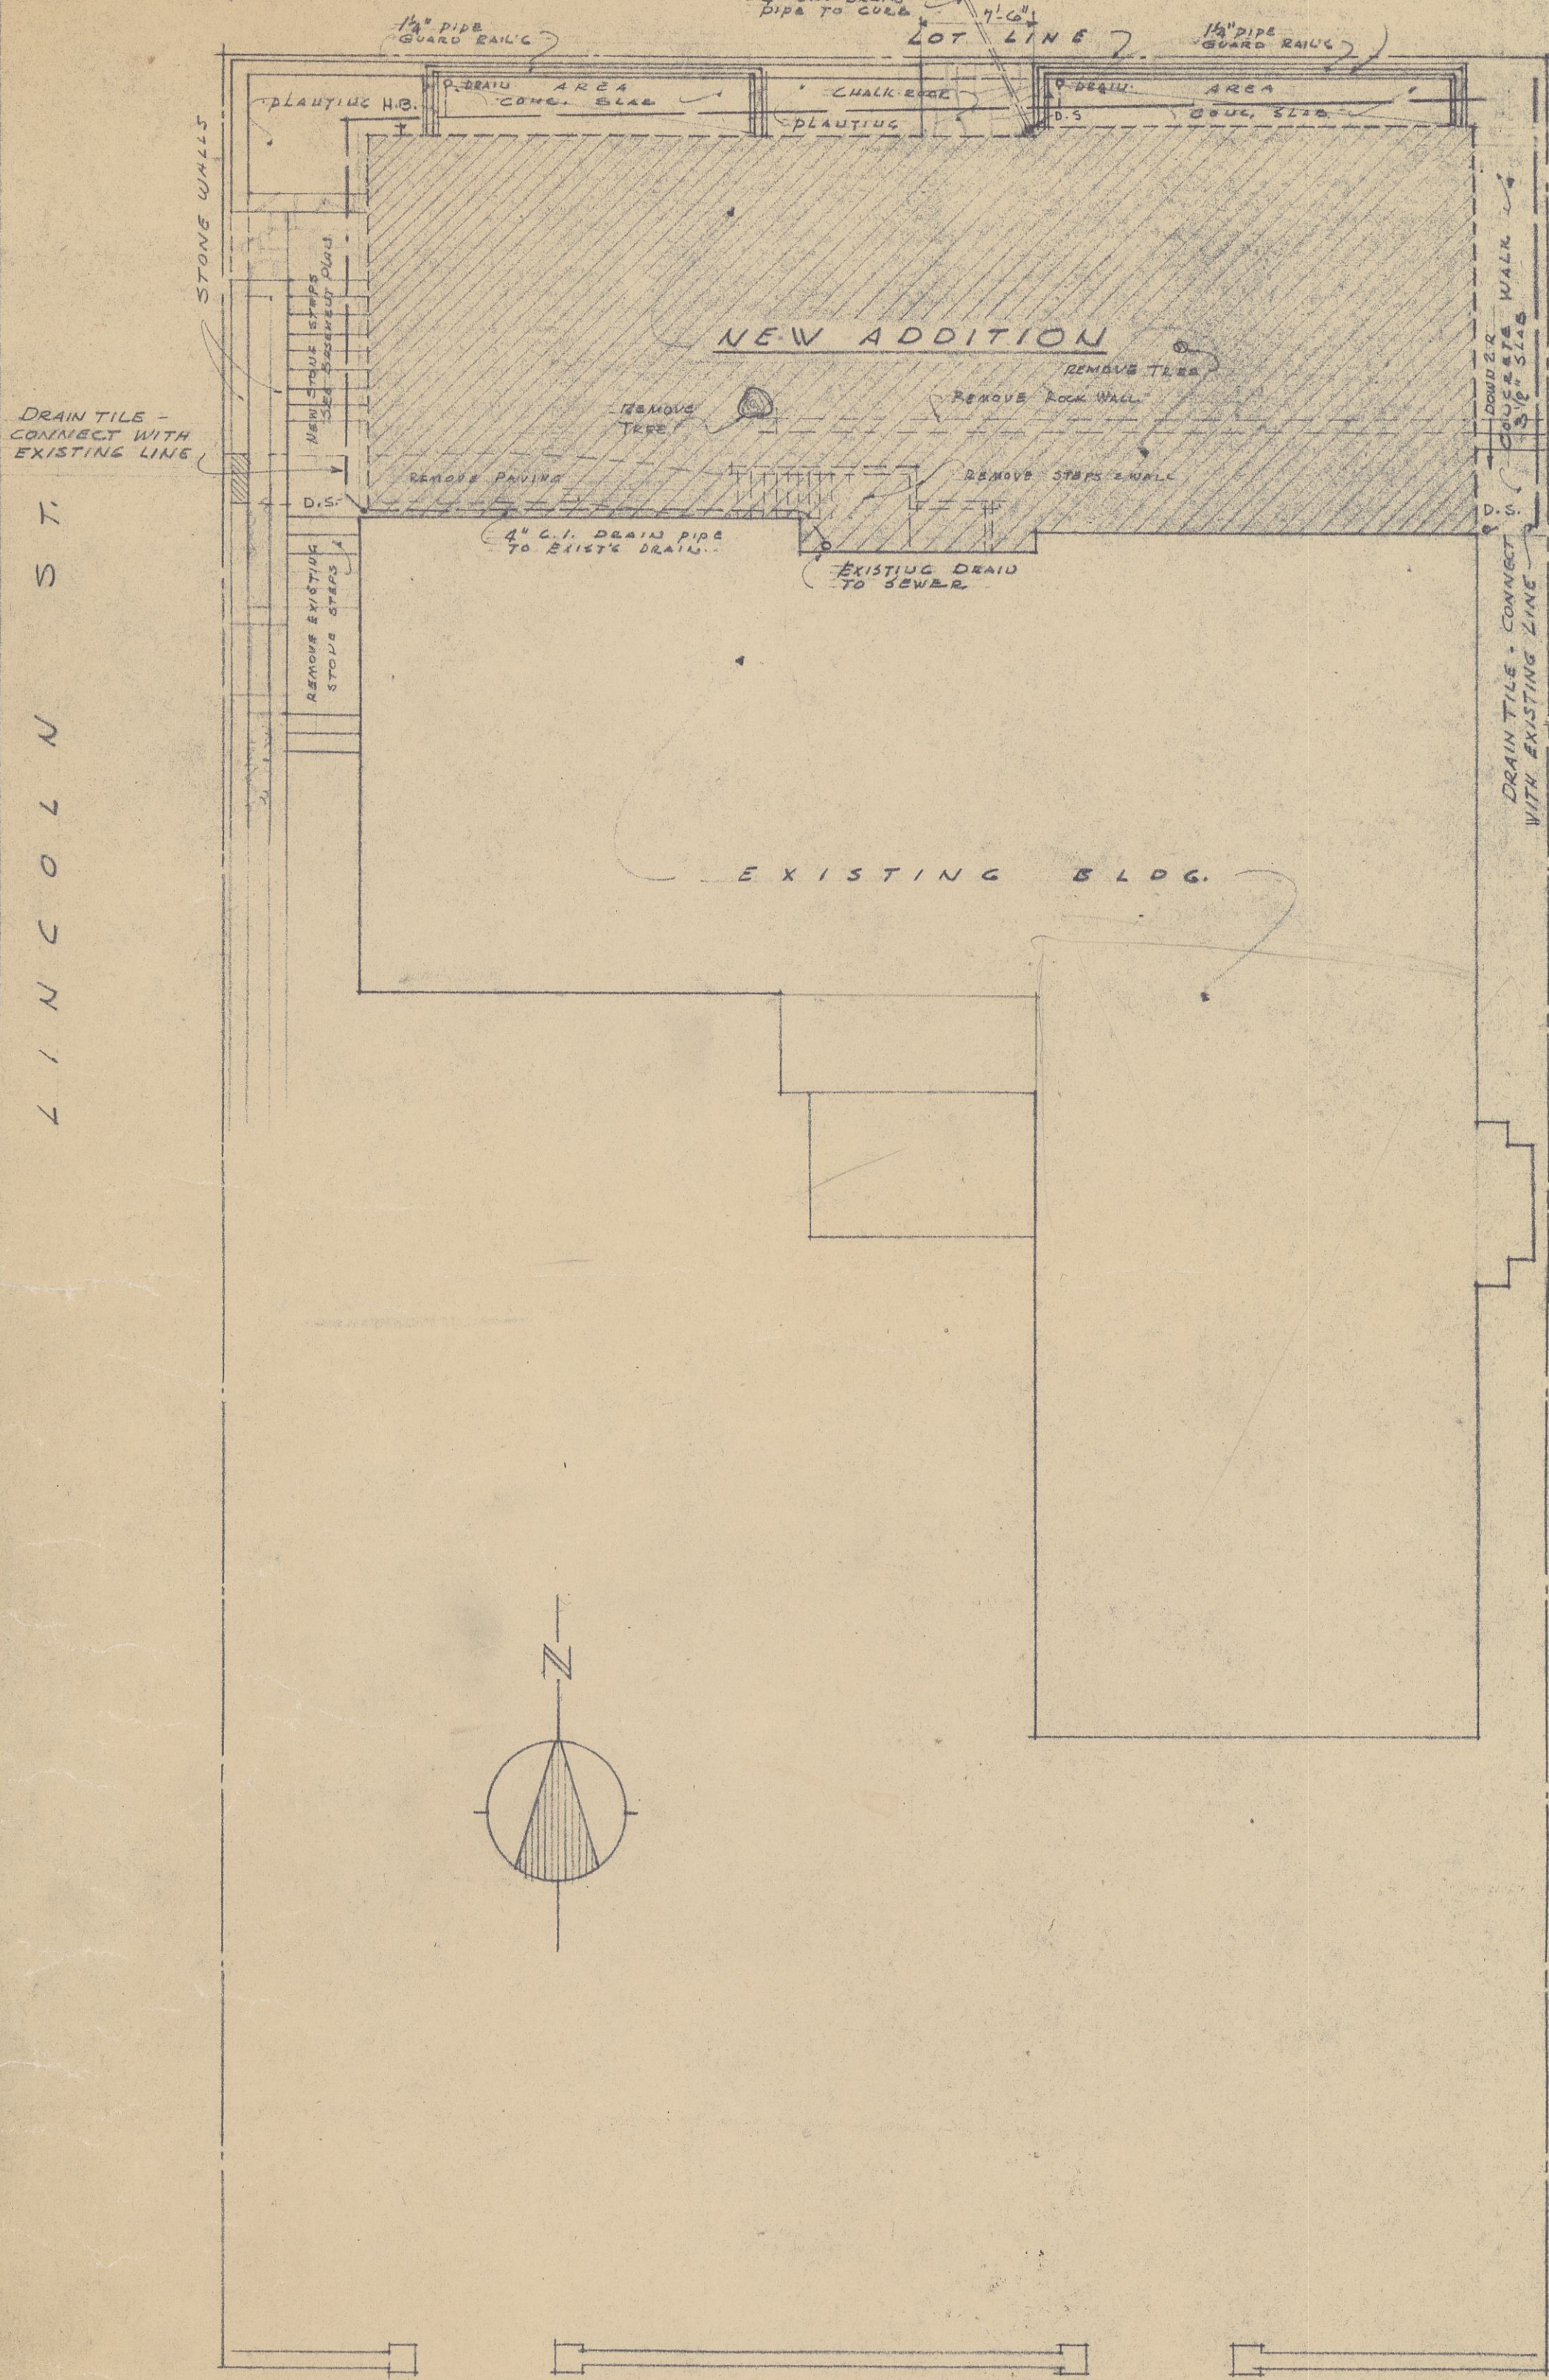

OCEAN AVE.
PLOT PLAN
SCALE 1/8" = 1'-0"

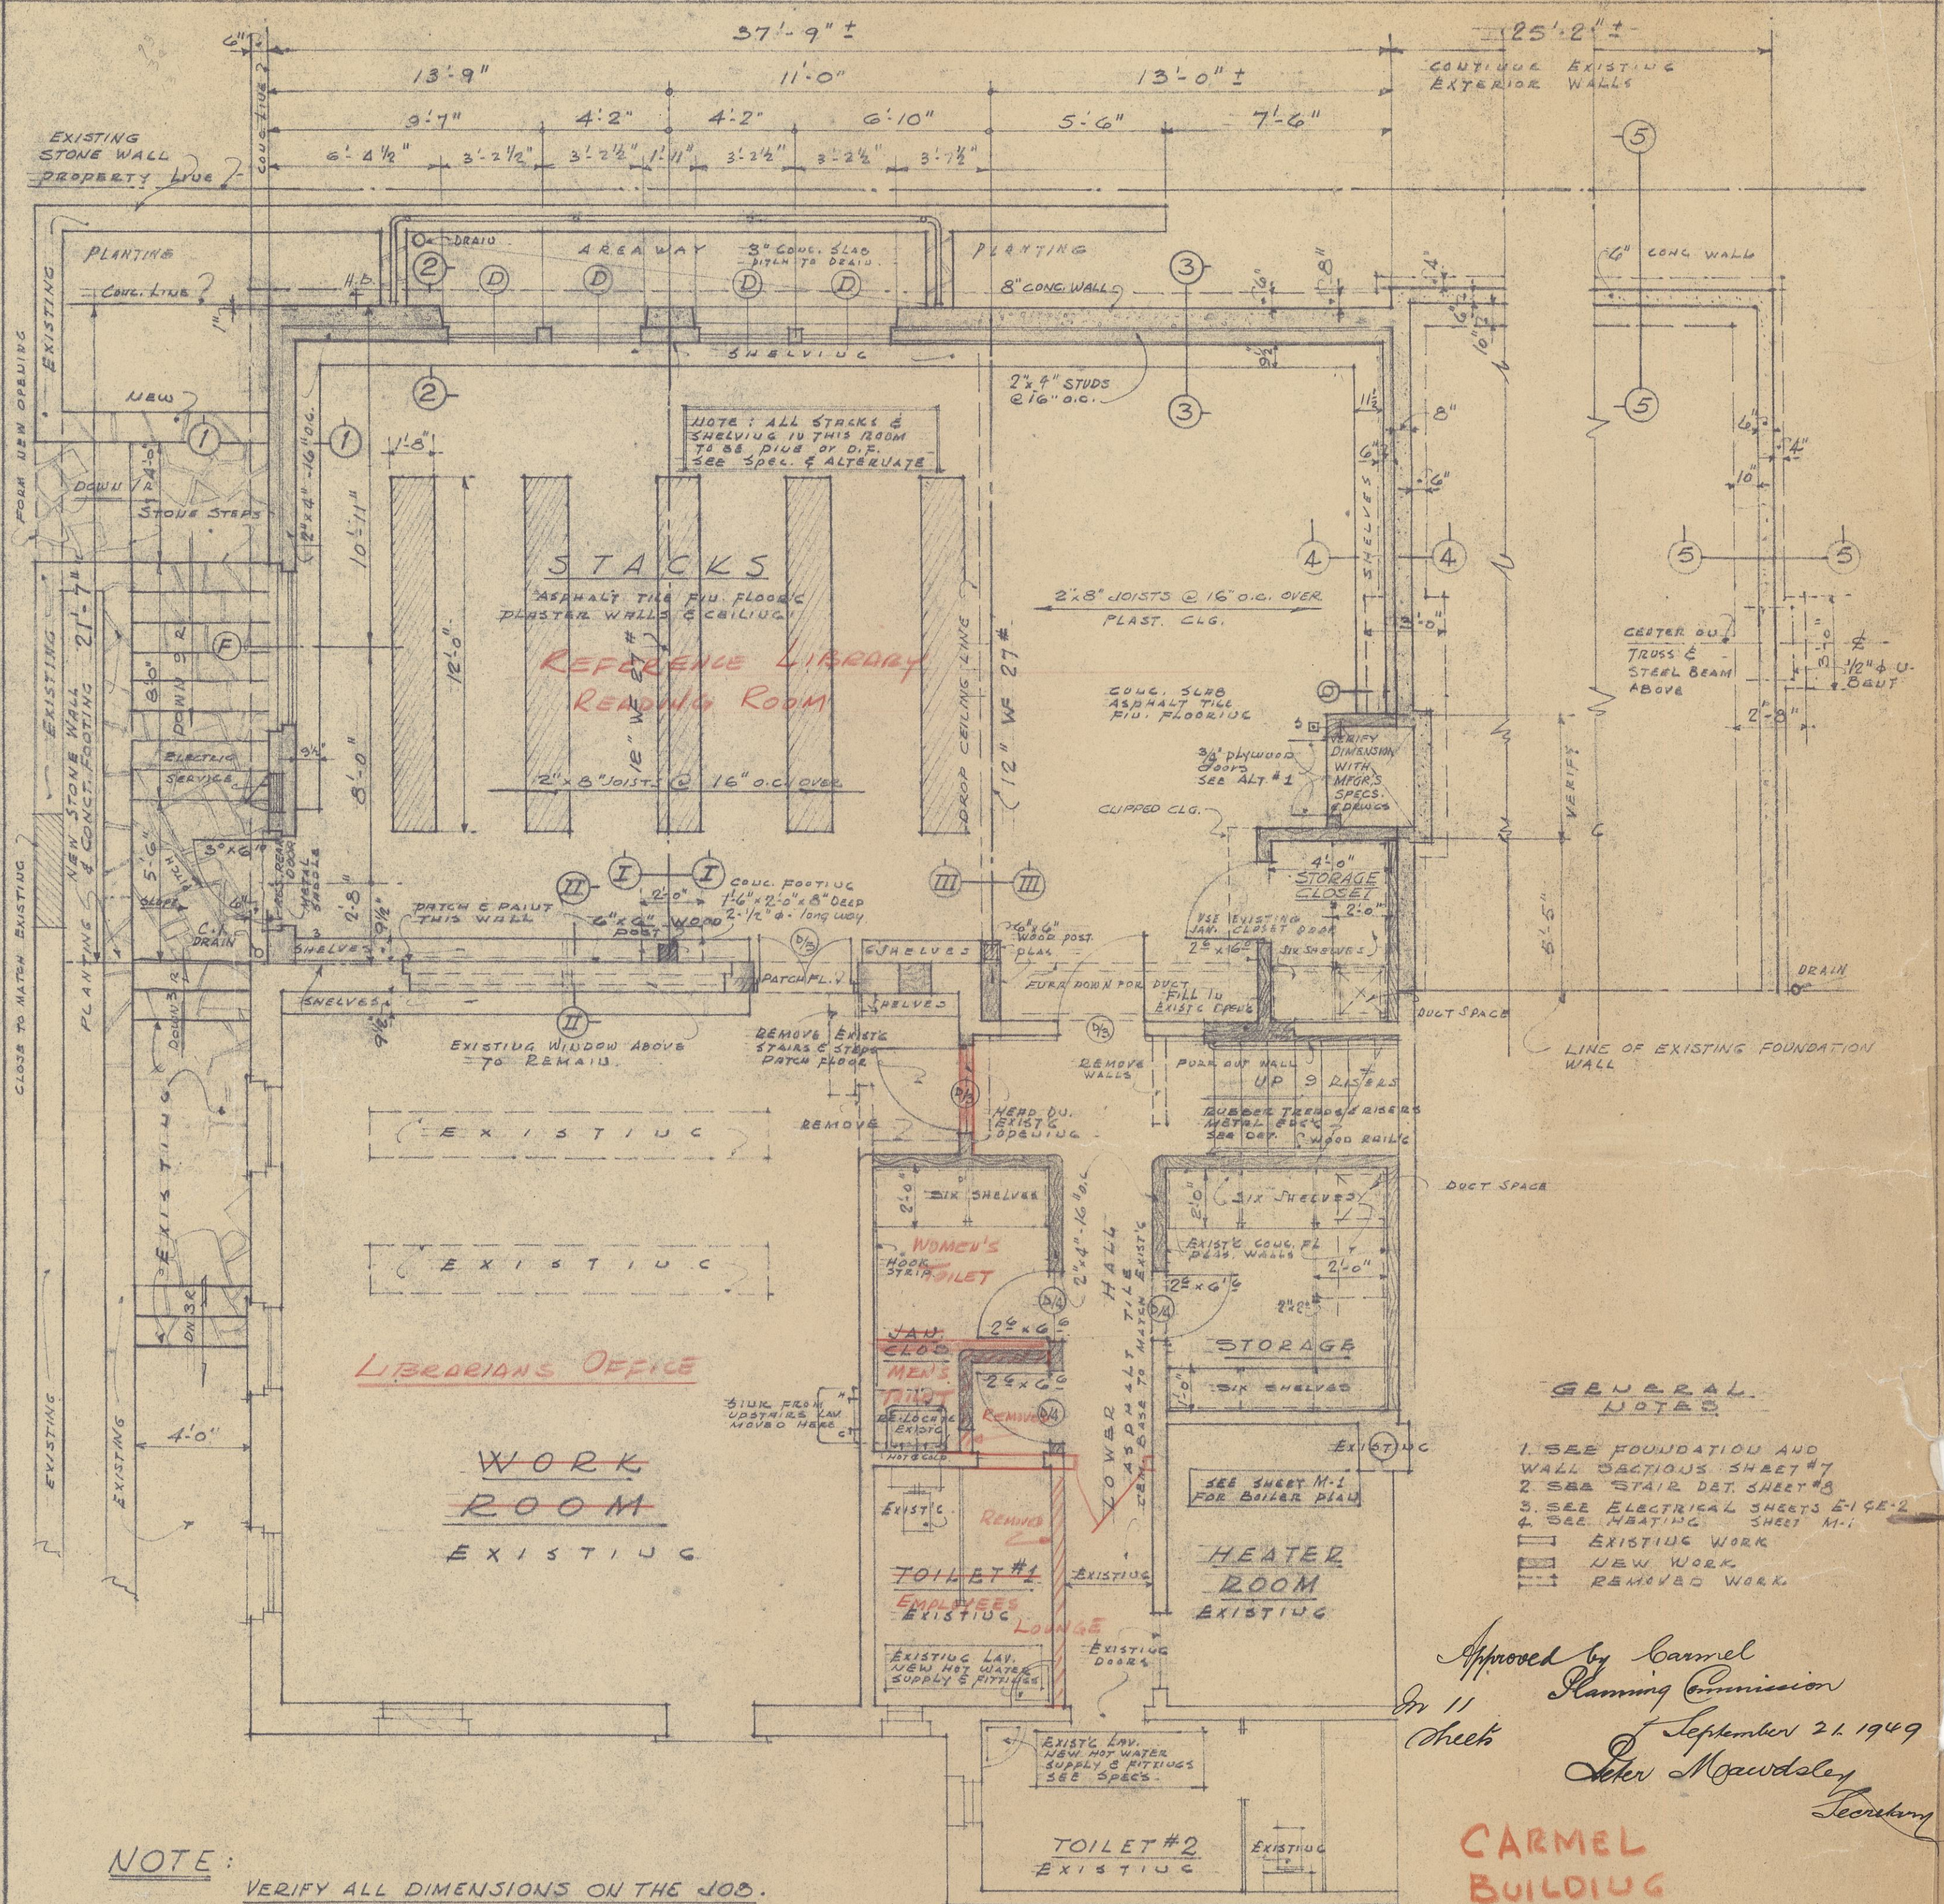

NOTE: VERIFY ALL DIMENSIONS ON THE JOB. WHERE CONDITIONS SHOWN BY UNCOVERING OF EXISTING WORK DO NOT PERMIT DETAILS AS DRAWN, CONSULT ARCHITECT.


BASEMENT PLAN
SCALE 1/4" = 1'-0"

Approved by Carmel Planning Commission
On 11/21/49
Check
Walter Mowbray Secretary


CARMEL BUILDING INSPECTOR

SET NO. 6

8	ALTERATIONS & ADDITIONS	HSB NO. 4820
7	HARRISON MEMORIAL LIBRARY	DRWG. 5-4-5
6	CARMEL, CALIF.	CH. BY HTS
5	ROBERT R. JONES, ARCHITECT	SHEET 1
4	BOX 927 - CARMEL, CALIFORNIA - PHONE 327	DATE 7/29/49
3	PLOT PLAN - BASEMENT PLAN	1 OF 8

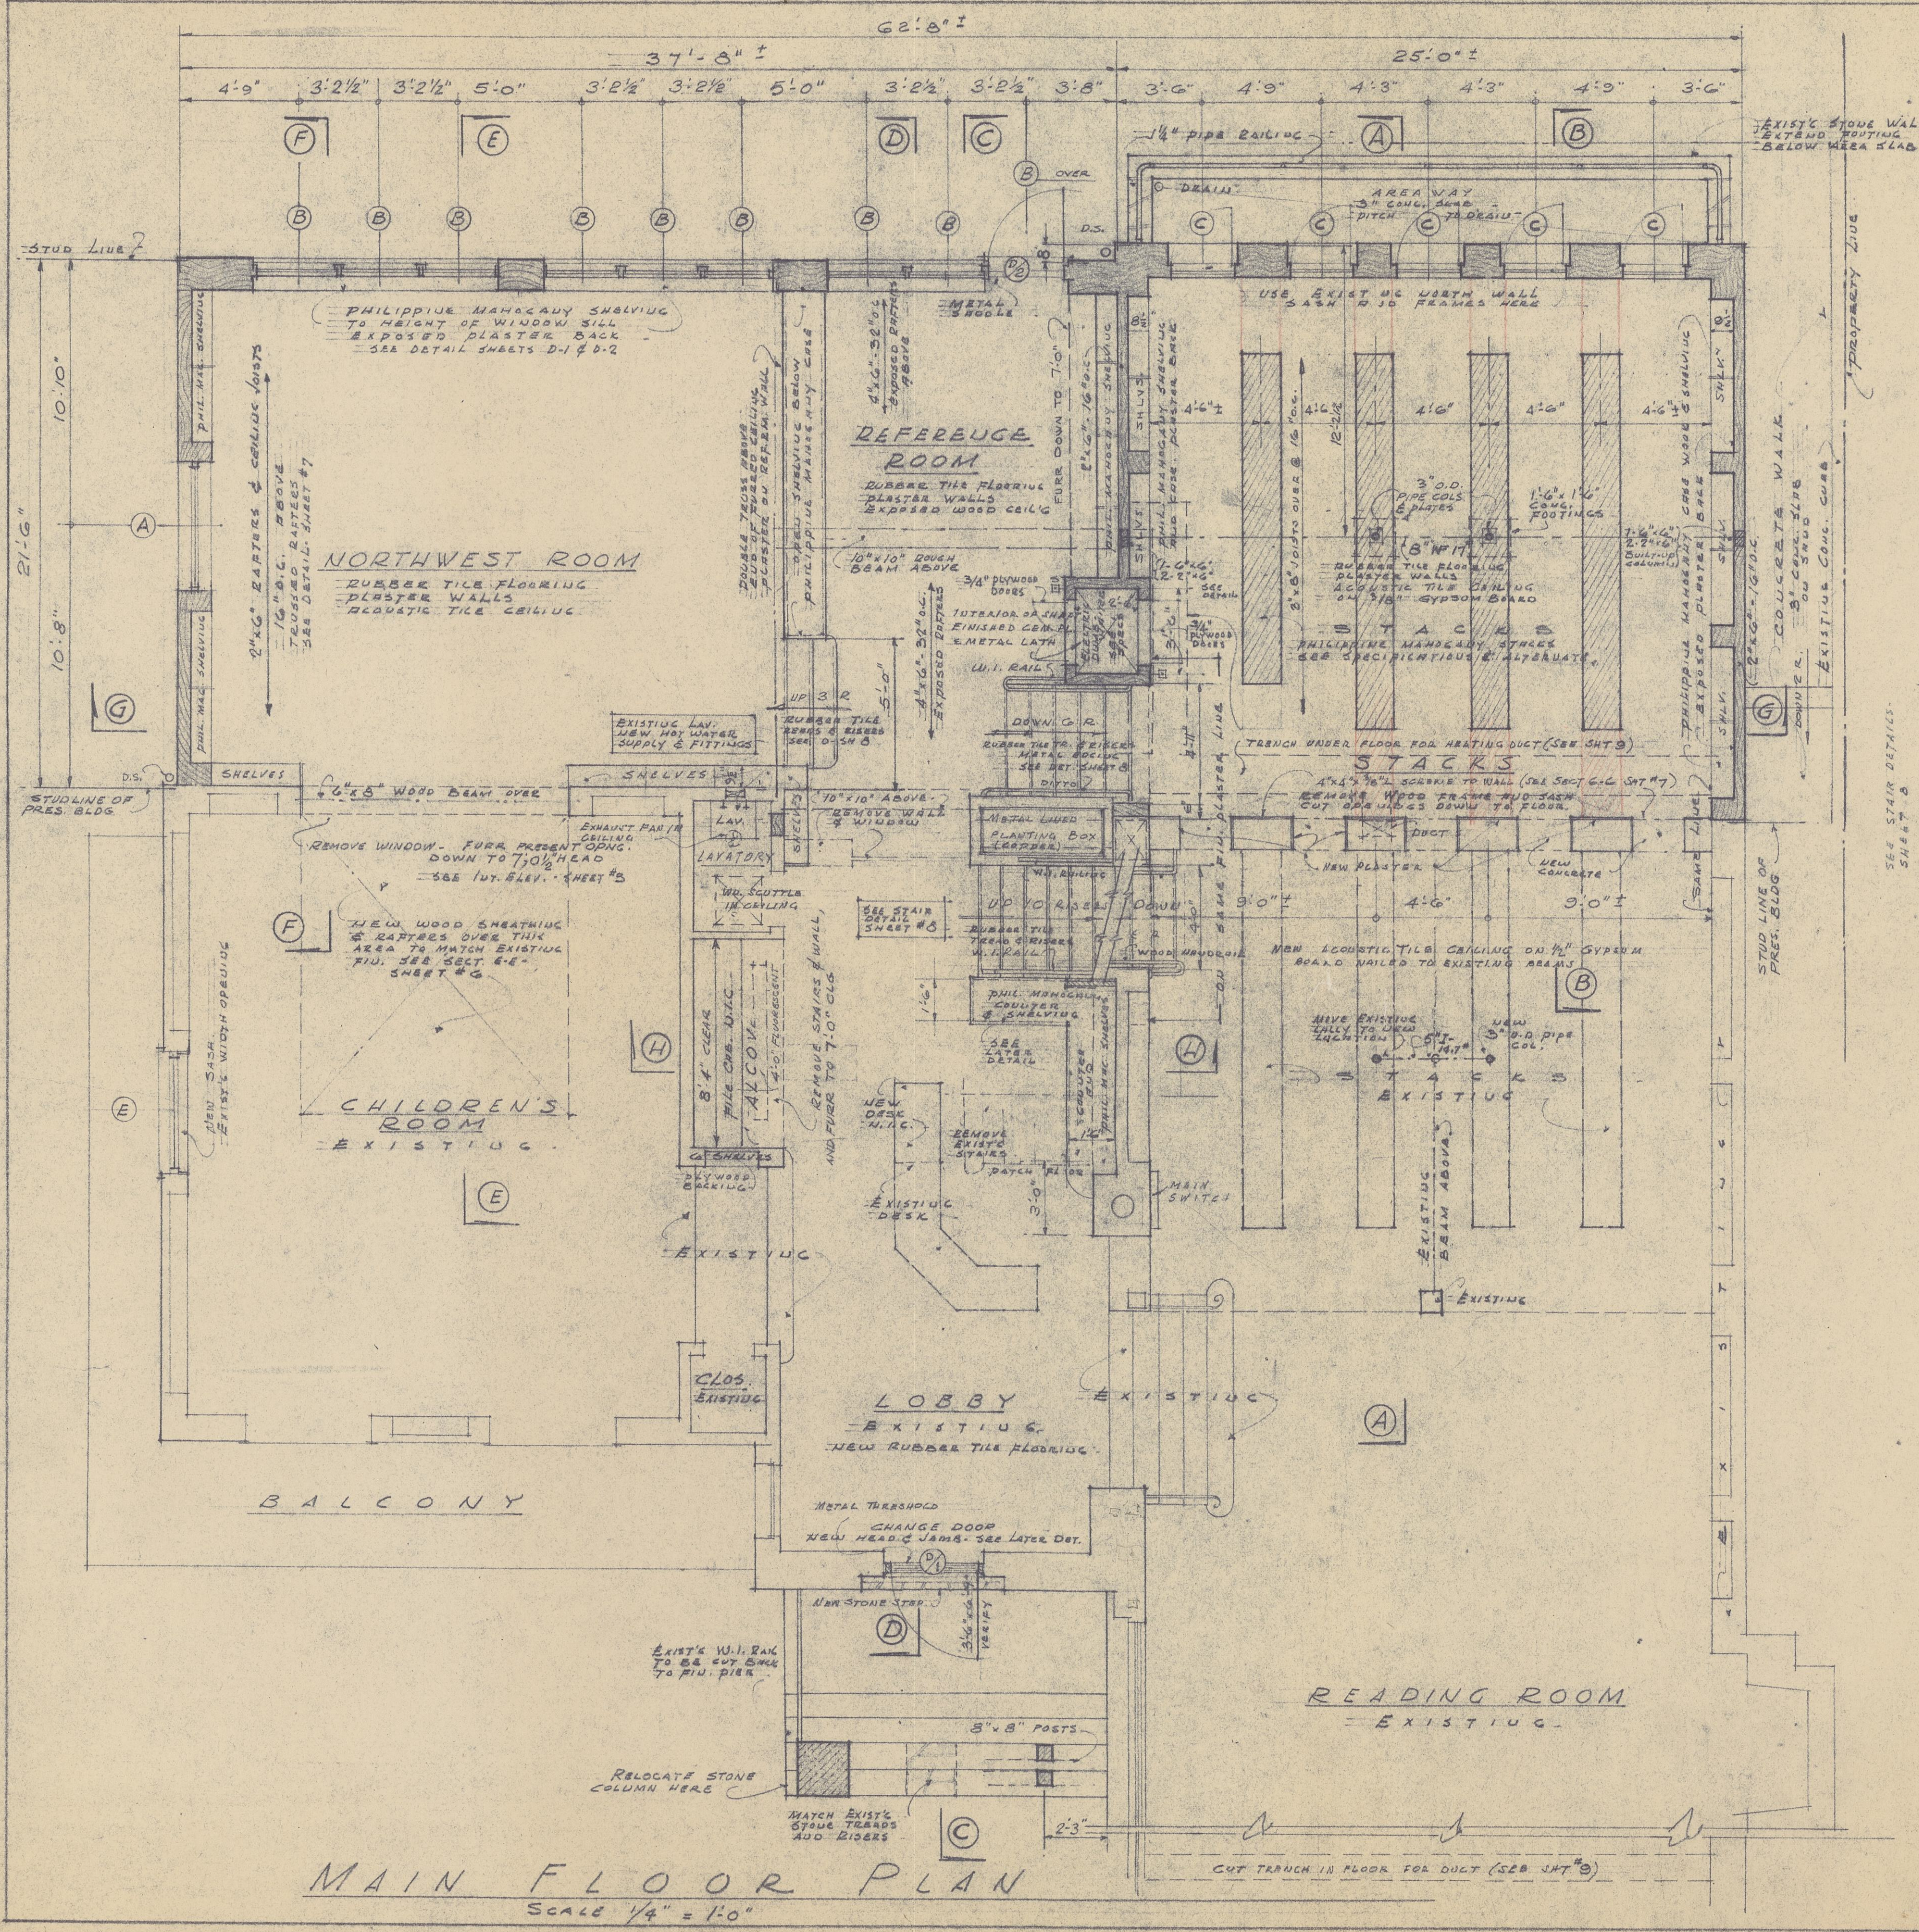


MAIN FLOOR PLAN
Scale 1/4" = 1'-0"

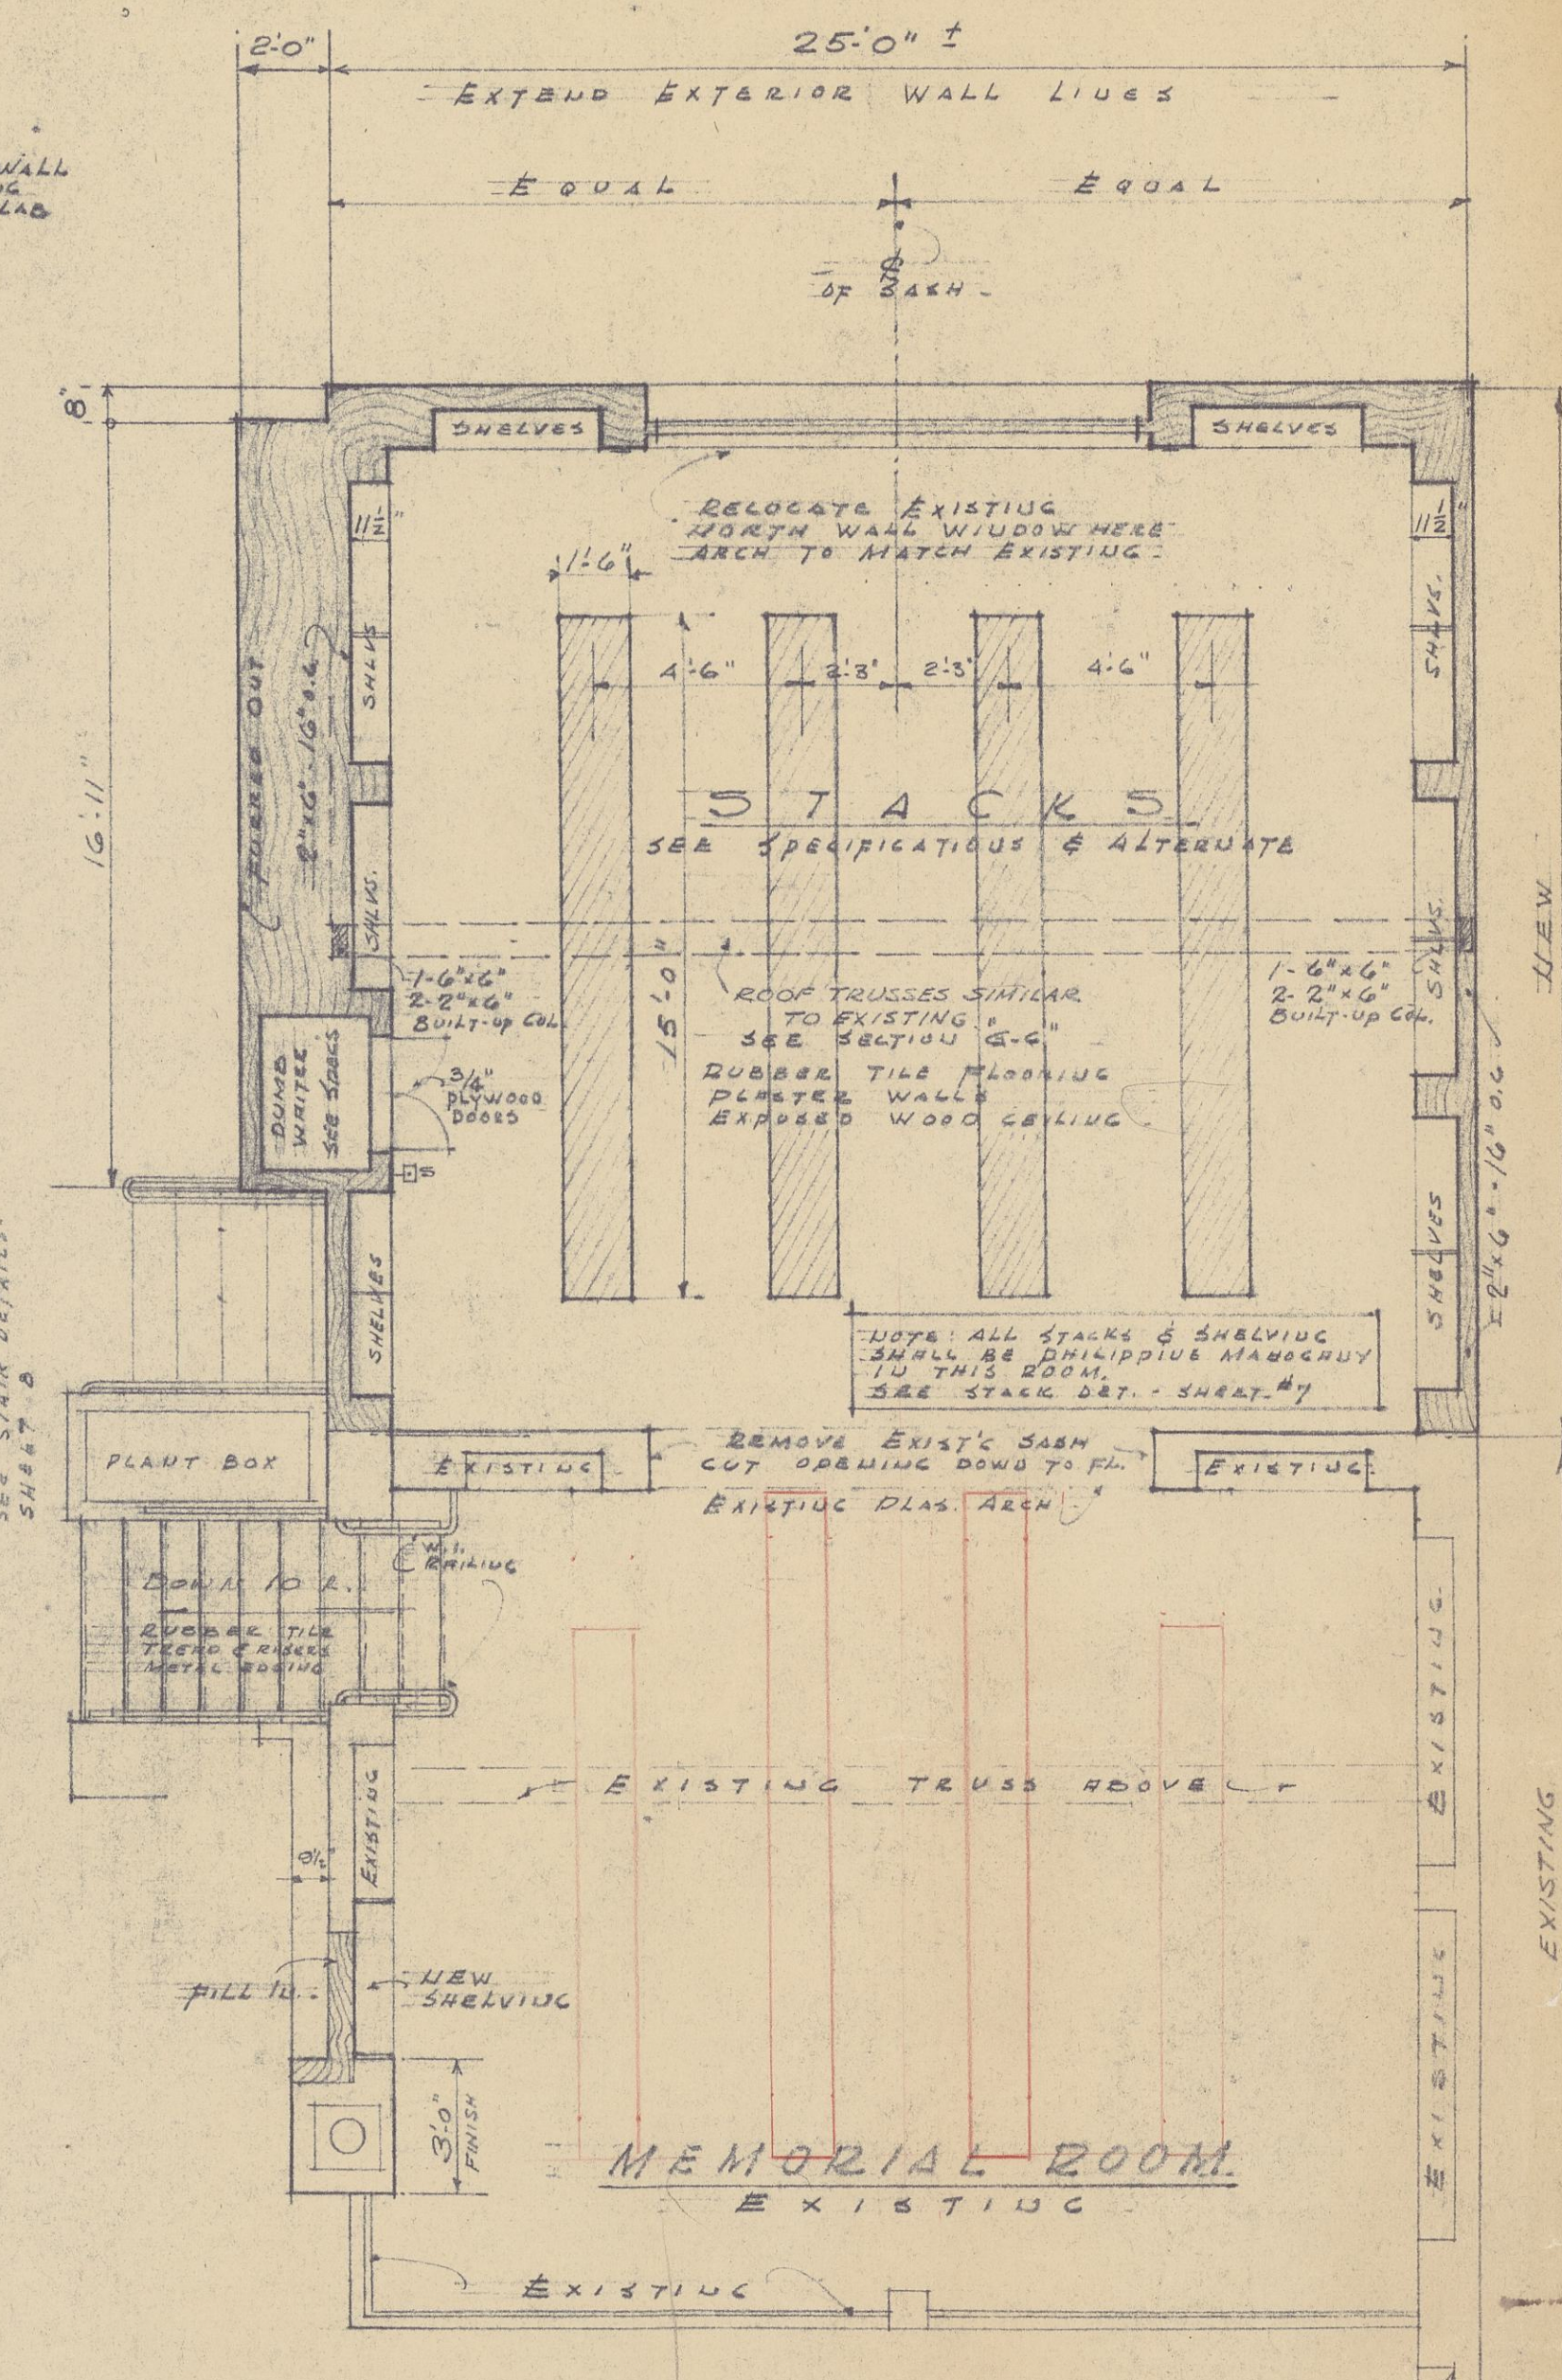


UPPER FLOOR PLAN
Scale 1/4" = 1'-0"

- NOTES:**
1. INTERIOR & EXTERIOR PLASTER FINISH TO MATCH EXISTING.
 2. RUBBER TILE ON ALL NEW MAIN FL., UPPER FL. & LOBBY FLOORS.
 3. OPEN CEILING TO MATCH EXISTING IN SIZE & SPACING OF MEMBERS, BUT UNSURFACED OR RESAWN FINISH SHALL BE USED INSTEAD OF ADZED FINISH AS IN EXISTING.
 4. SEE DETAIL SHEETS D-1, D-2 & D-3 FOR F.S.O. TRIM & DOOR & WINDOW SECTIONS.
 5. NEW WORK
 6. EXISTING WORK
 7. WORK REMOVED
 8. ALTERNATE #1 - STACKS

6	ALTERATIONS & ADDITIONS	JOB NO. 4820
5	HARRISON MEMORIAL	DRAWN BY S.J.S.
4	LIBRARY	CHEK BY H.T.S.
3	CARMEL, CALIF.	SHEET 2
2	ROBERT R. JONES, ARCHITECT	OF 8
1	BOX 927 - CARMEL, CALIFORNIA - PHONE 347.	
	MAIN FLOOR PLAN	
	UPPER FLOOR PLAN	
Date: 7/29/49	By: [Signature]	Issued: [Signature]

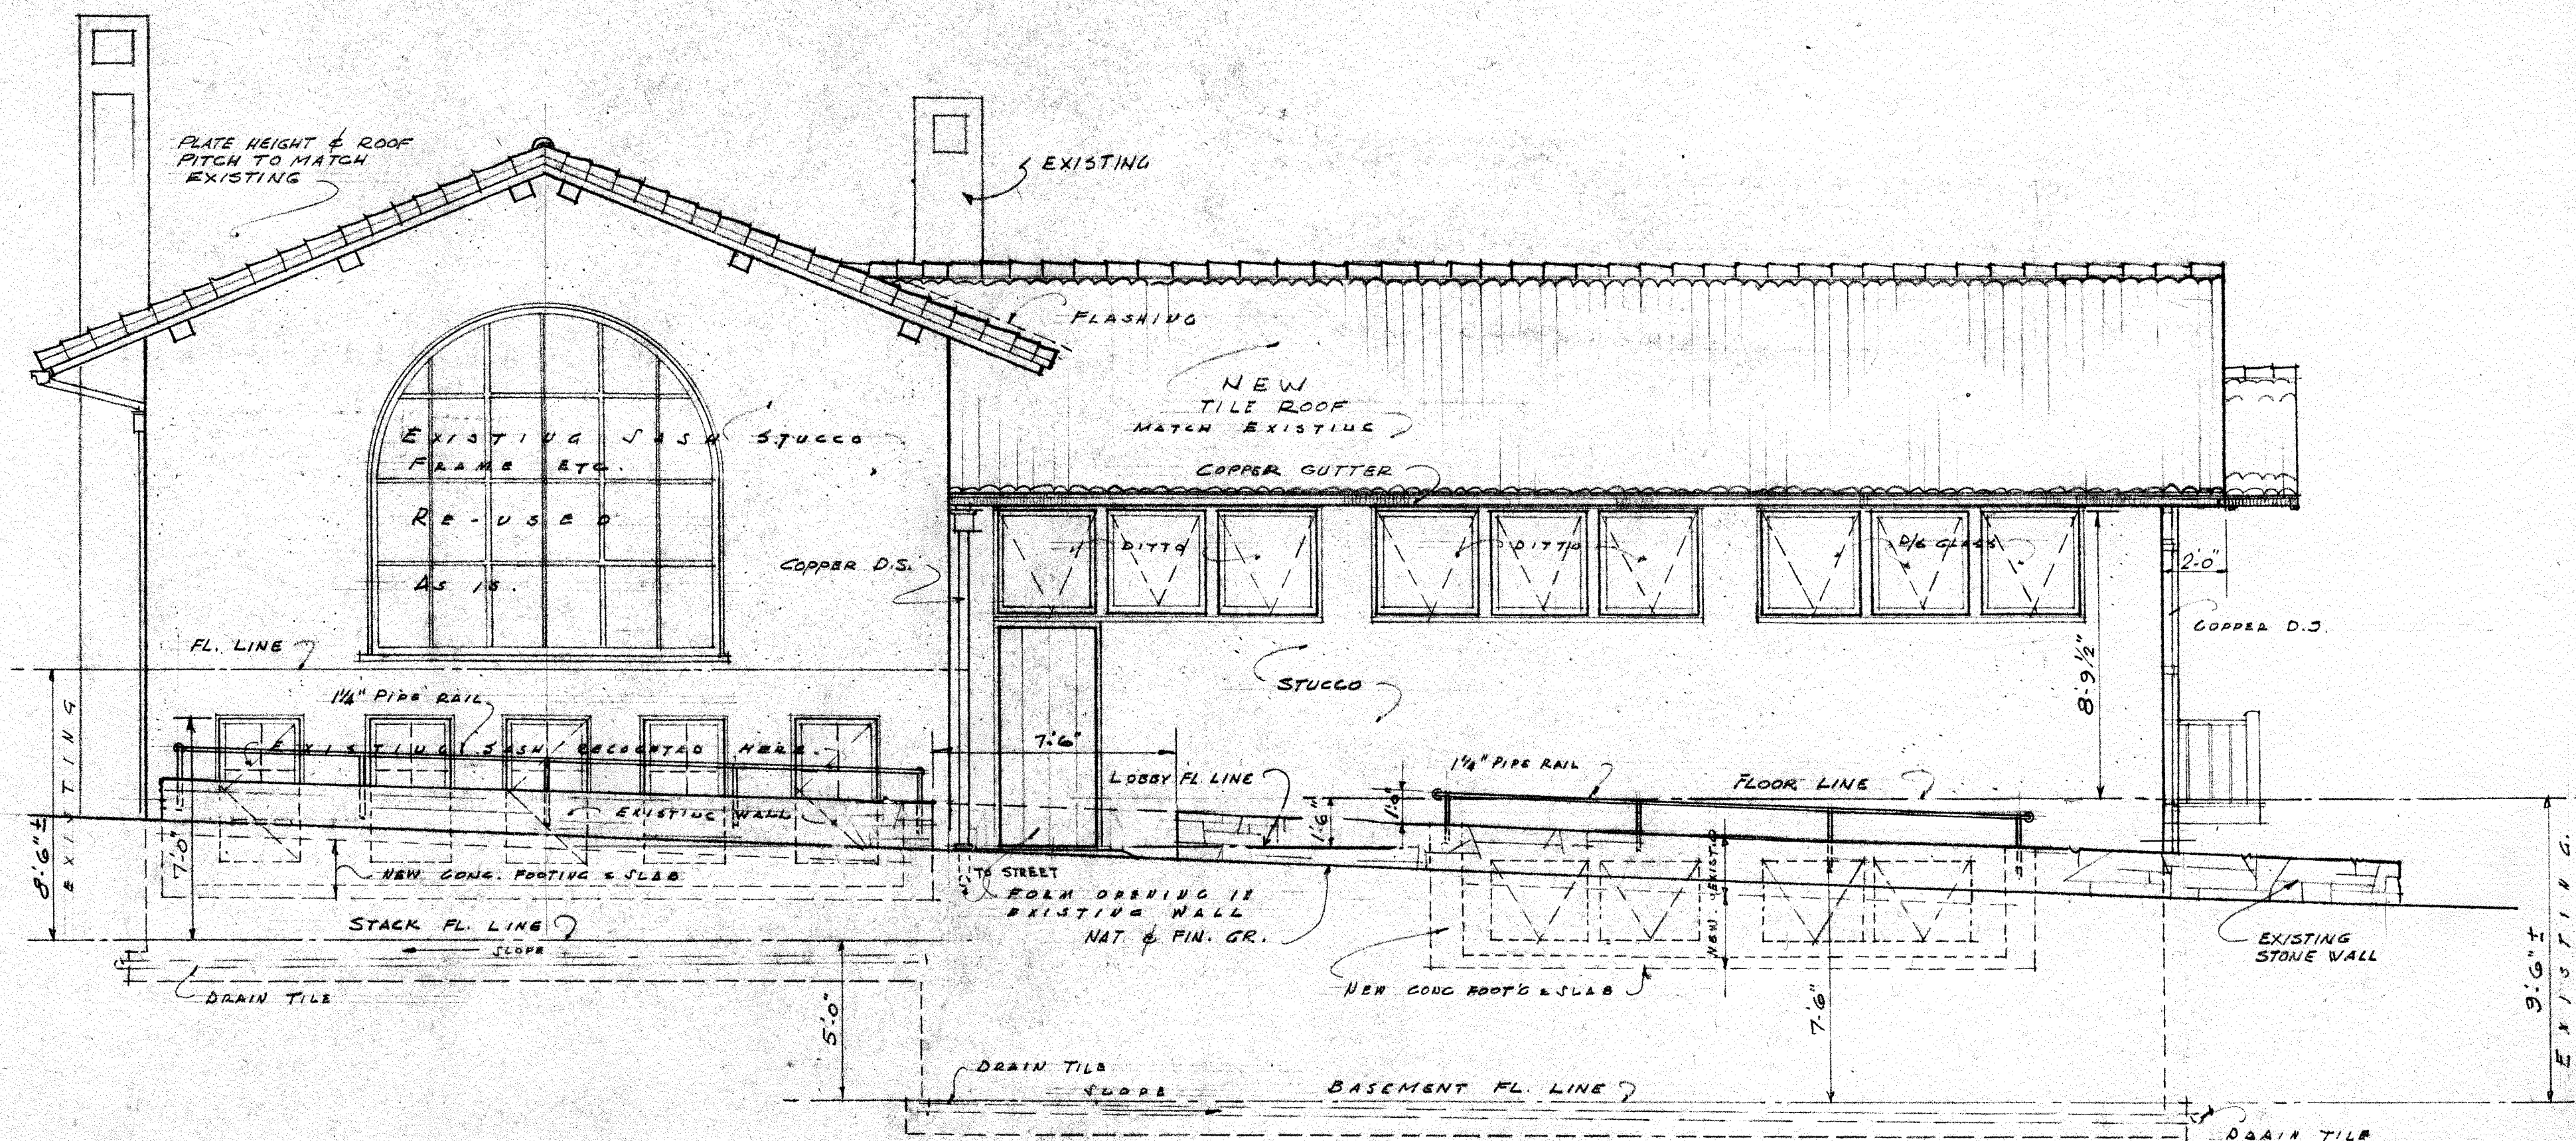


NORTH (SIXTH AVE.)

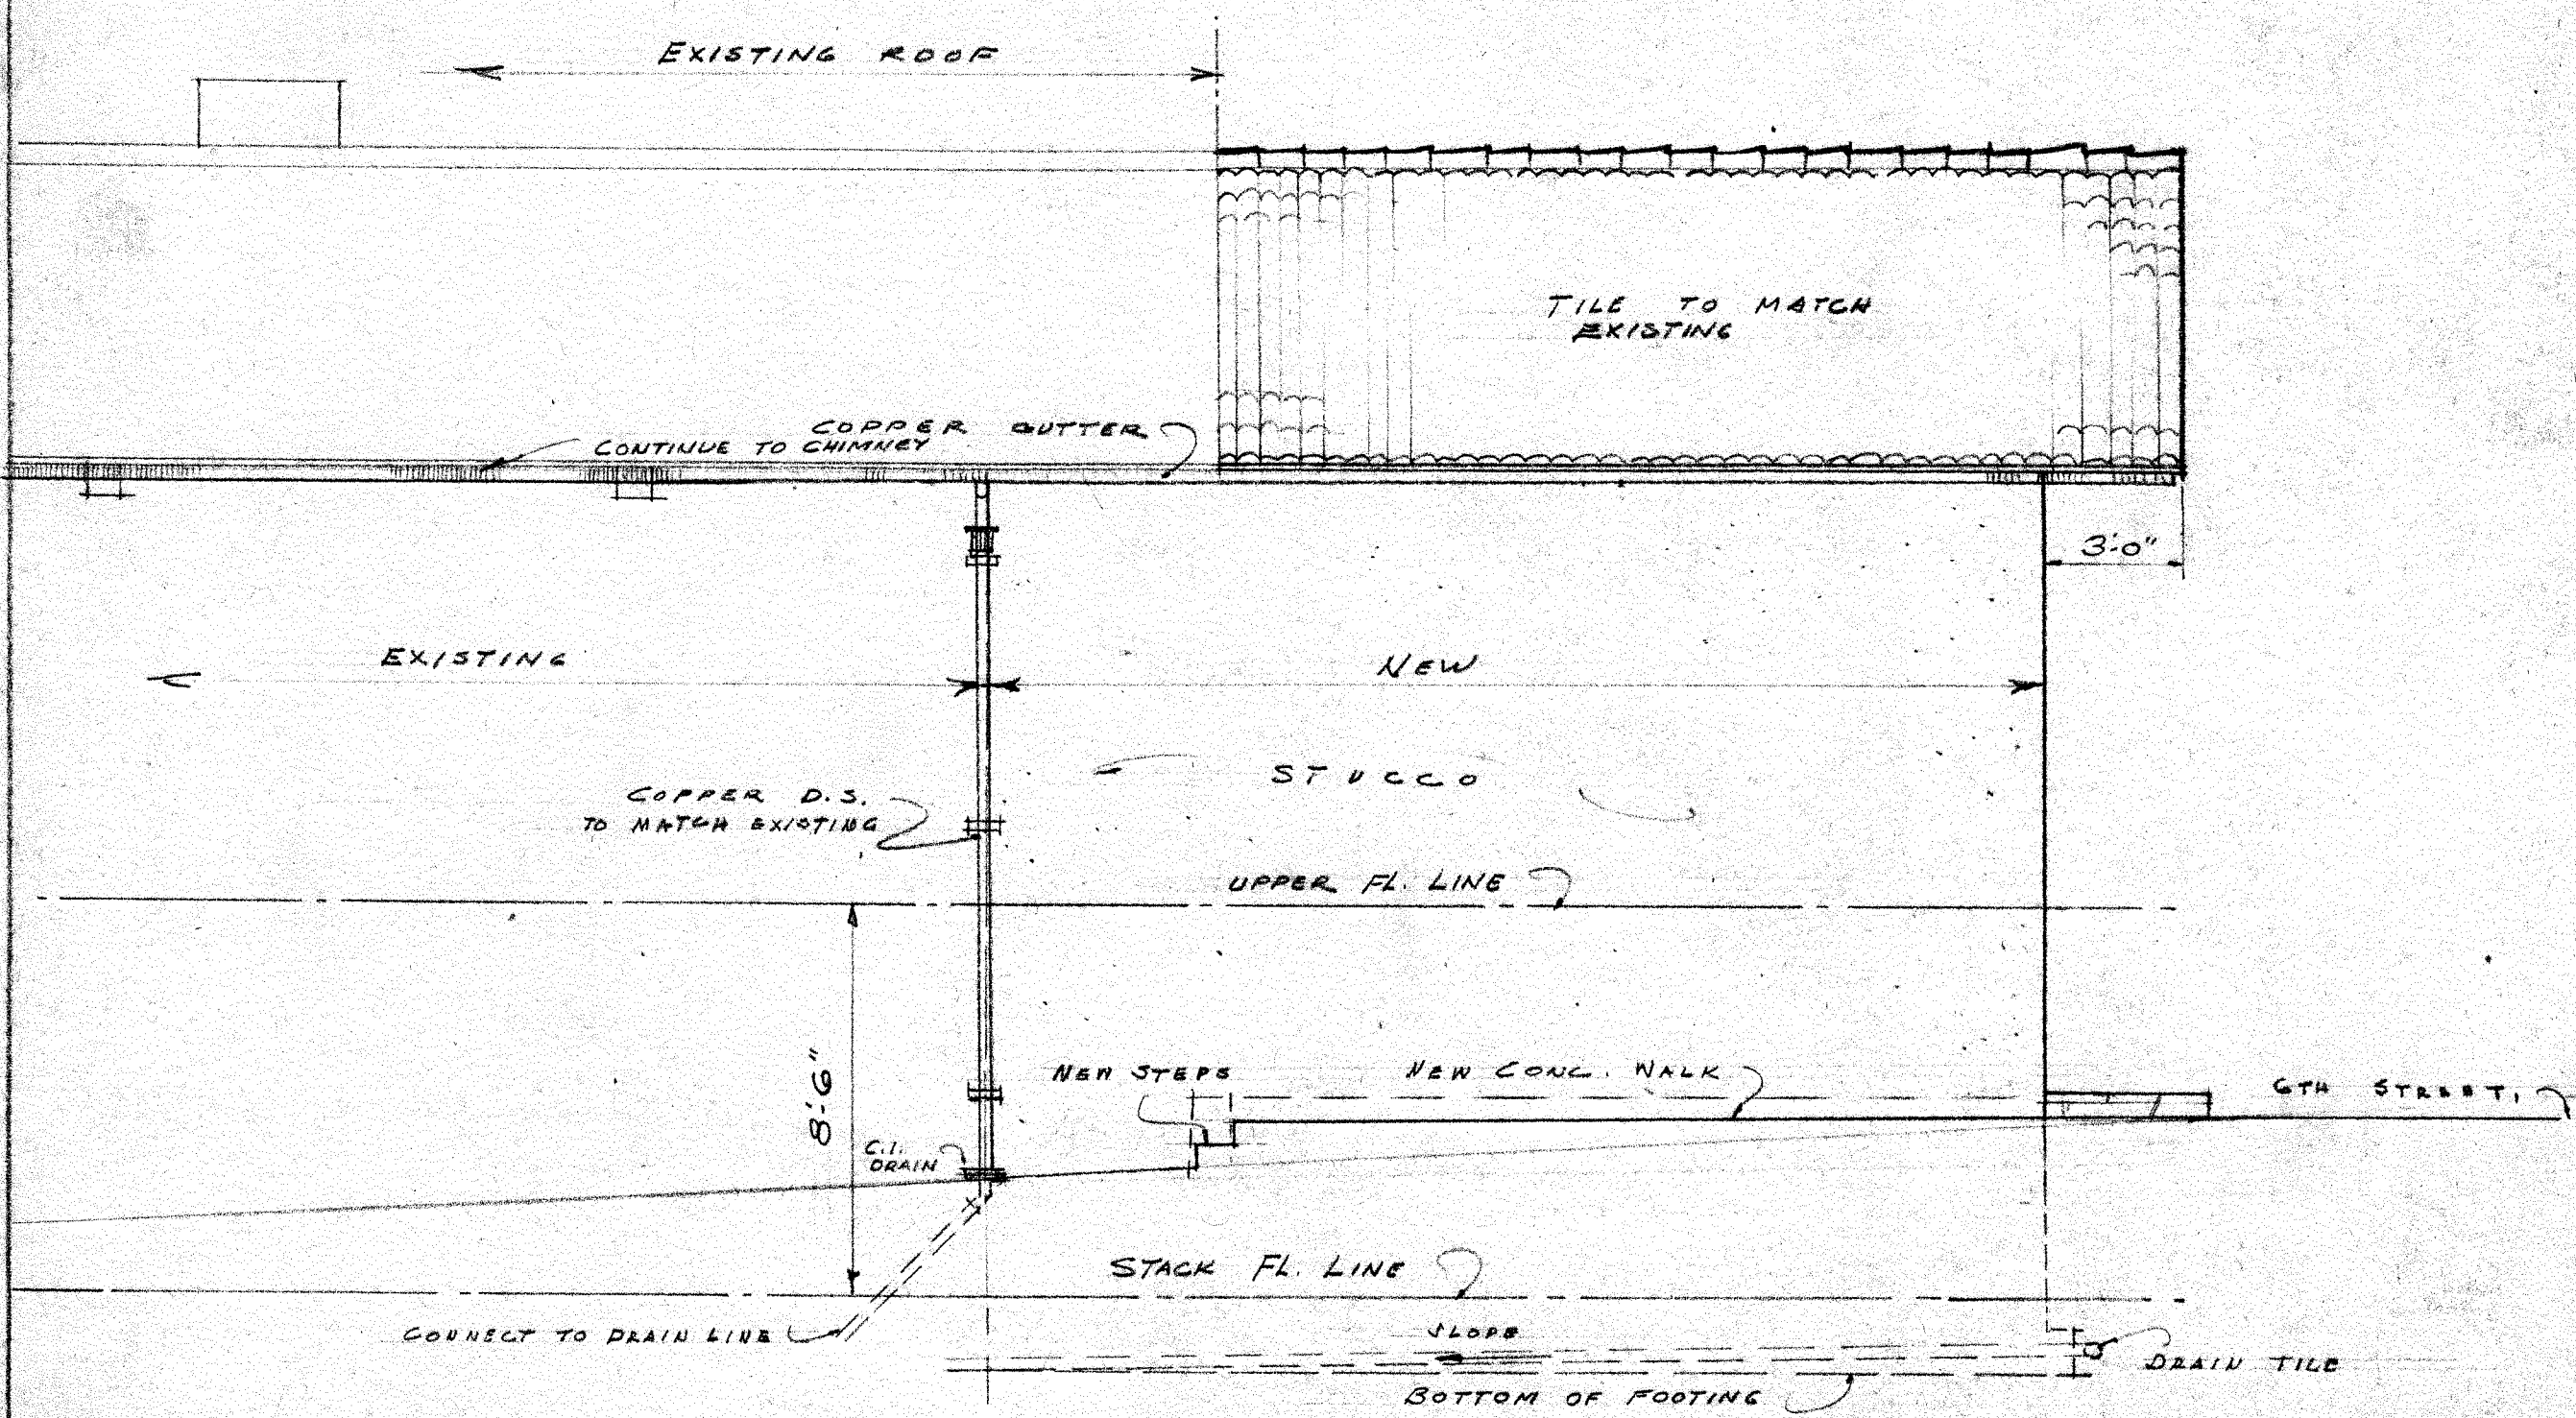


EAST


6	ALTERATIONS & ADDITIONS	JOB NO. 4820
5	HARRISON MEMORIAL	DRWG BY S.W.S.
4	LIBRARY	CHK BY HTS
3	CARMEL CALIF	SHEET 4
2	ROBERT R. JONES, ARCHITECT	OF 8
1	BOX 927 - CARMEL, CALIFORNIA - PHONE 347	
Date	By	Issued
7/29/49		

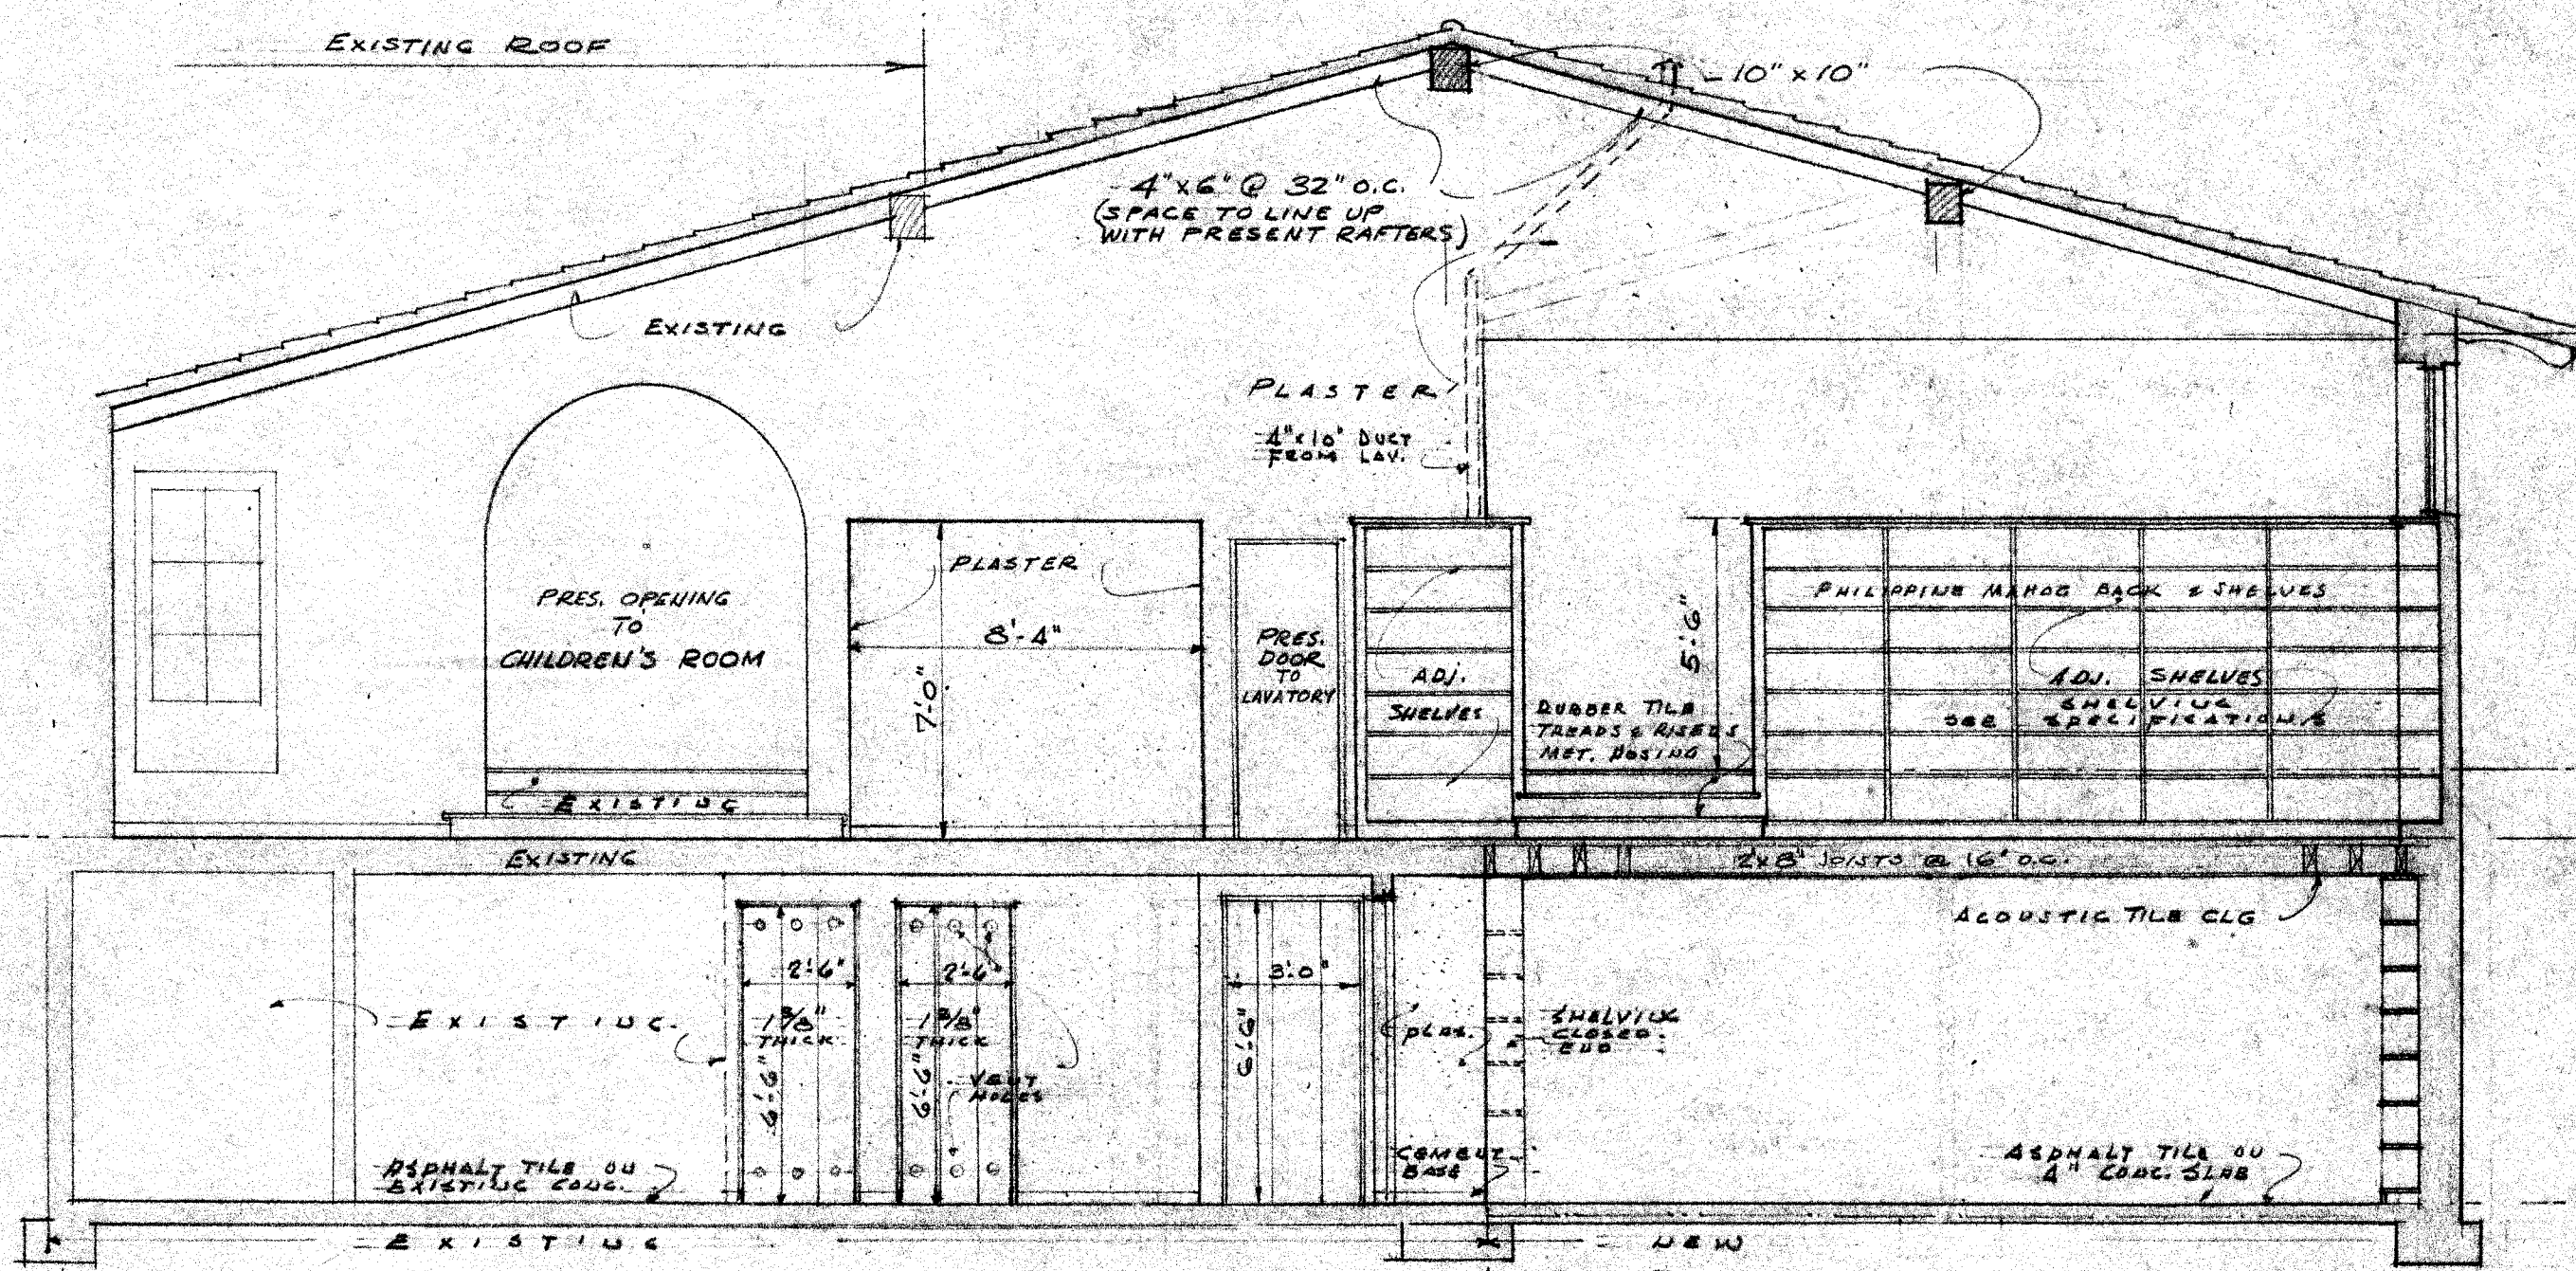


SECTION D-D
LOOKING WEST

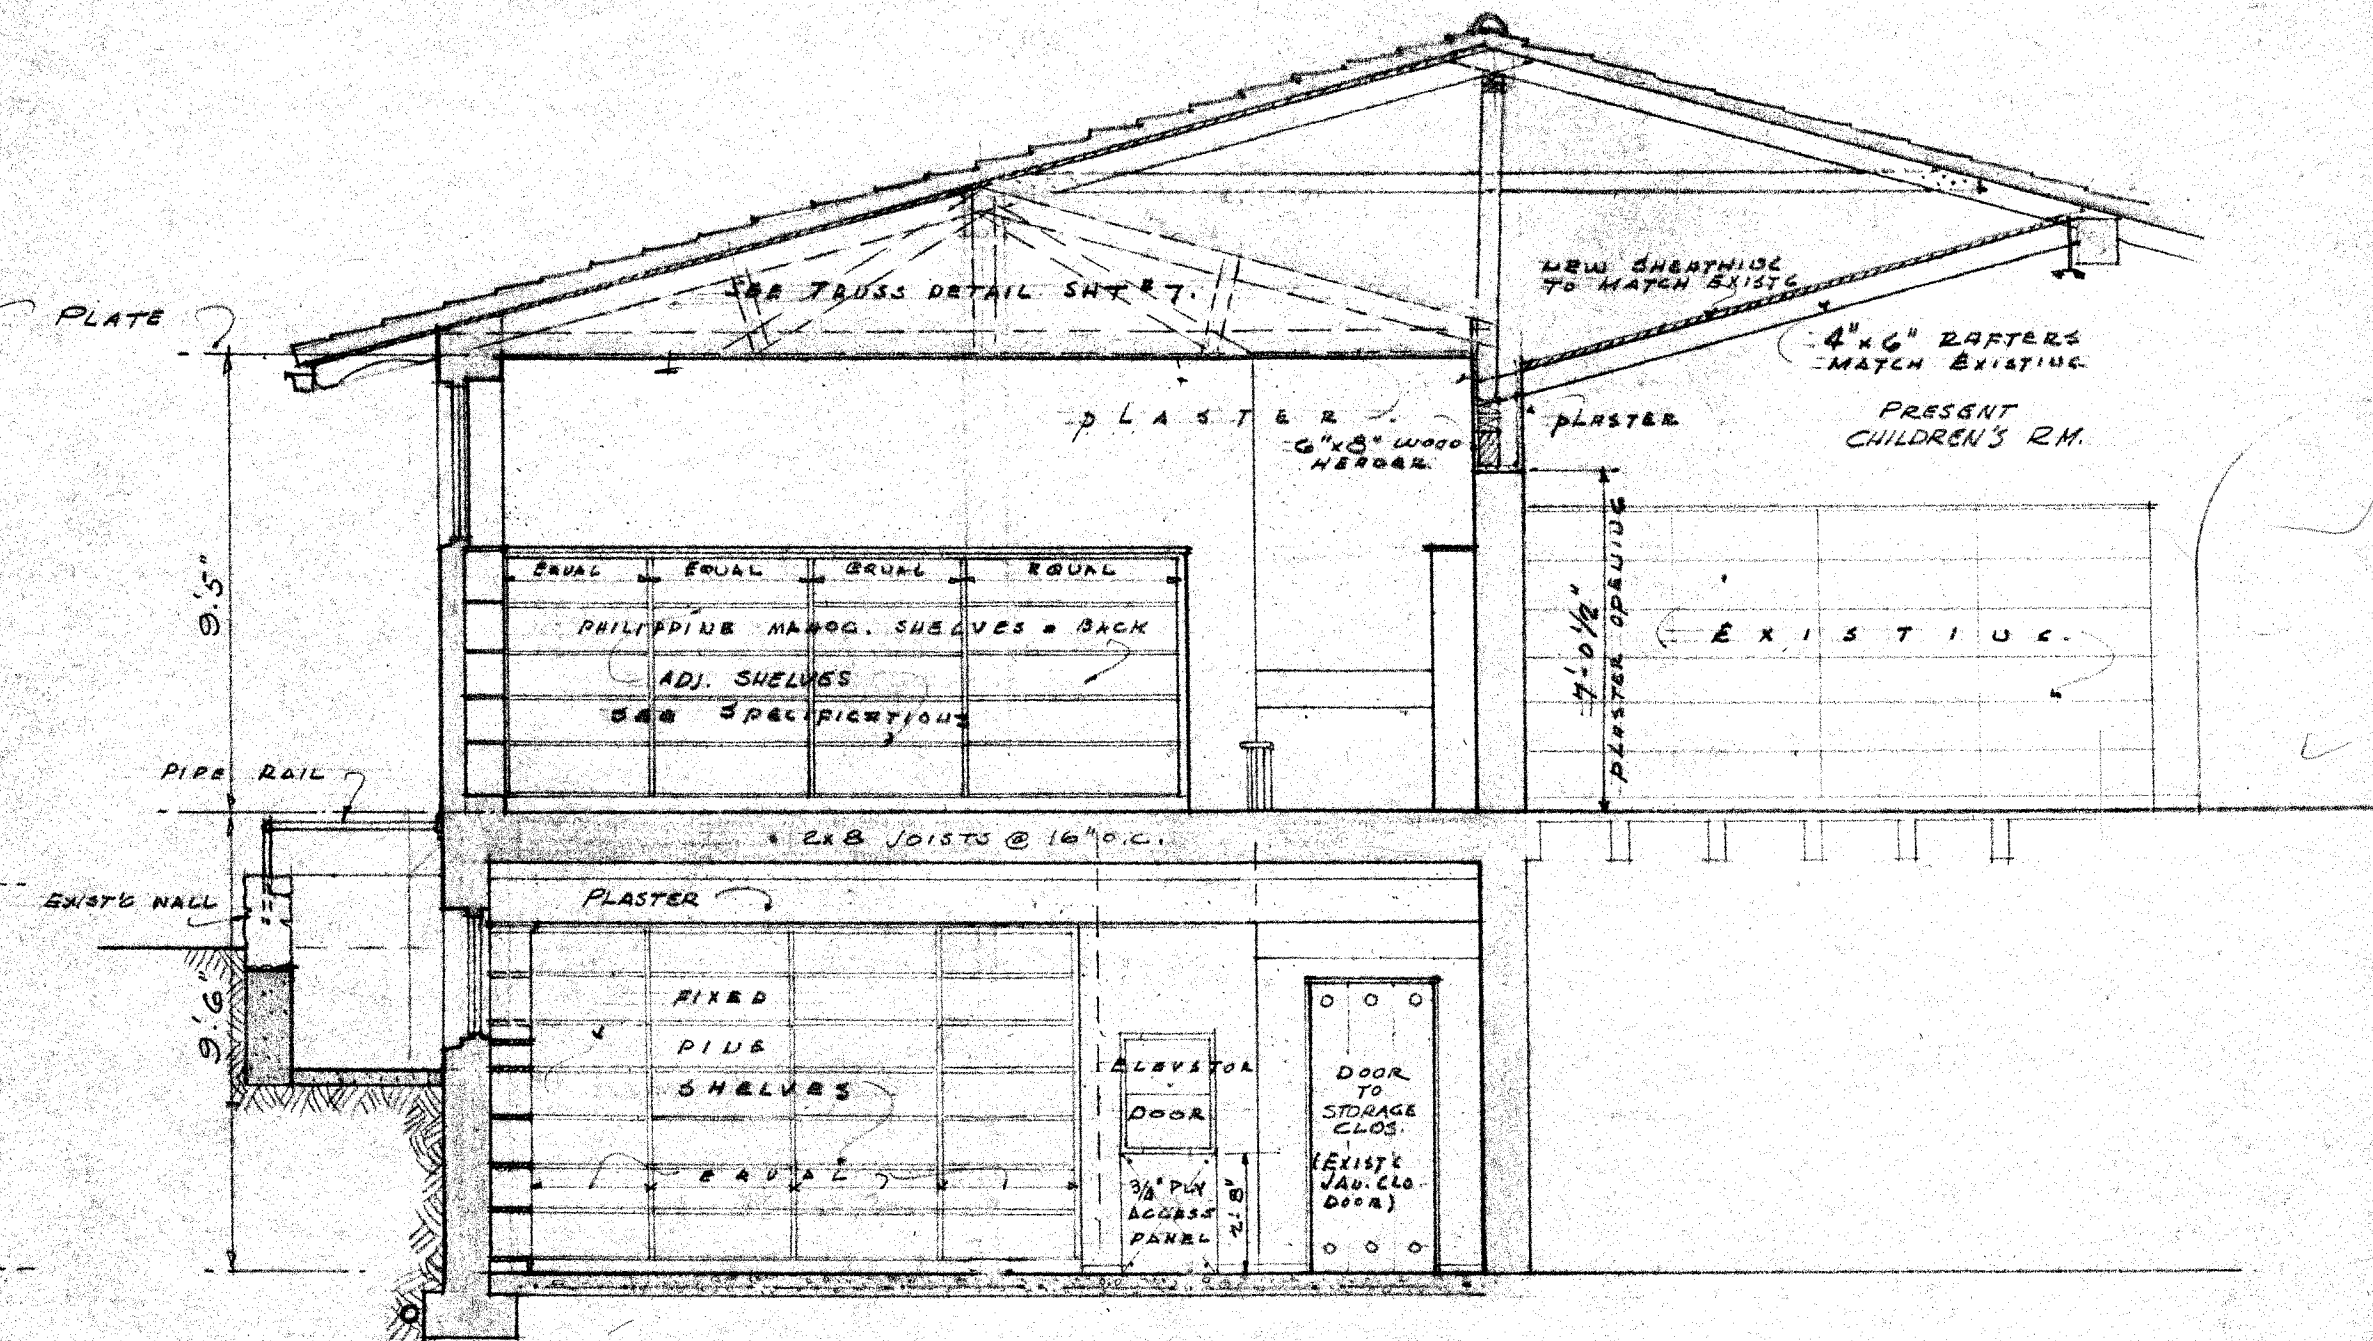


SECTION E-E
LOOKING EAST

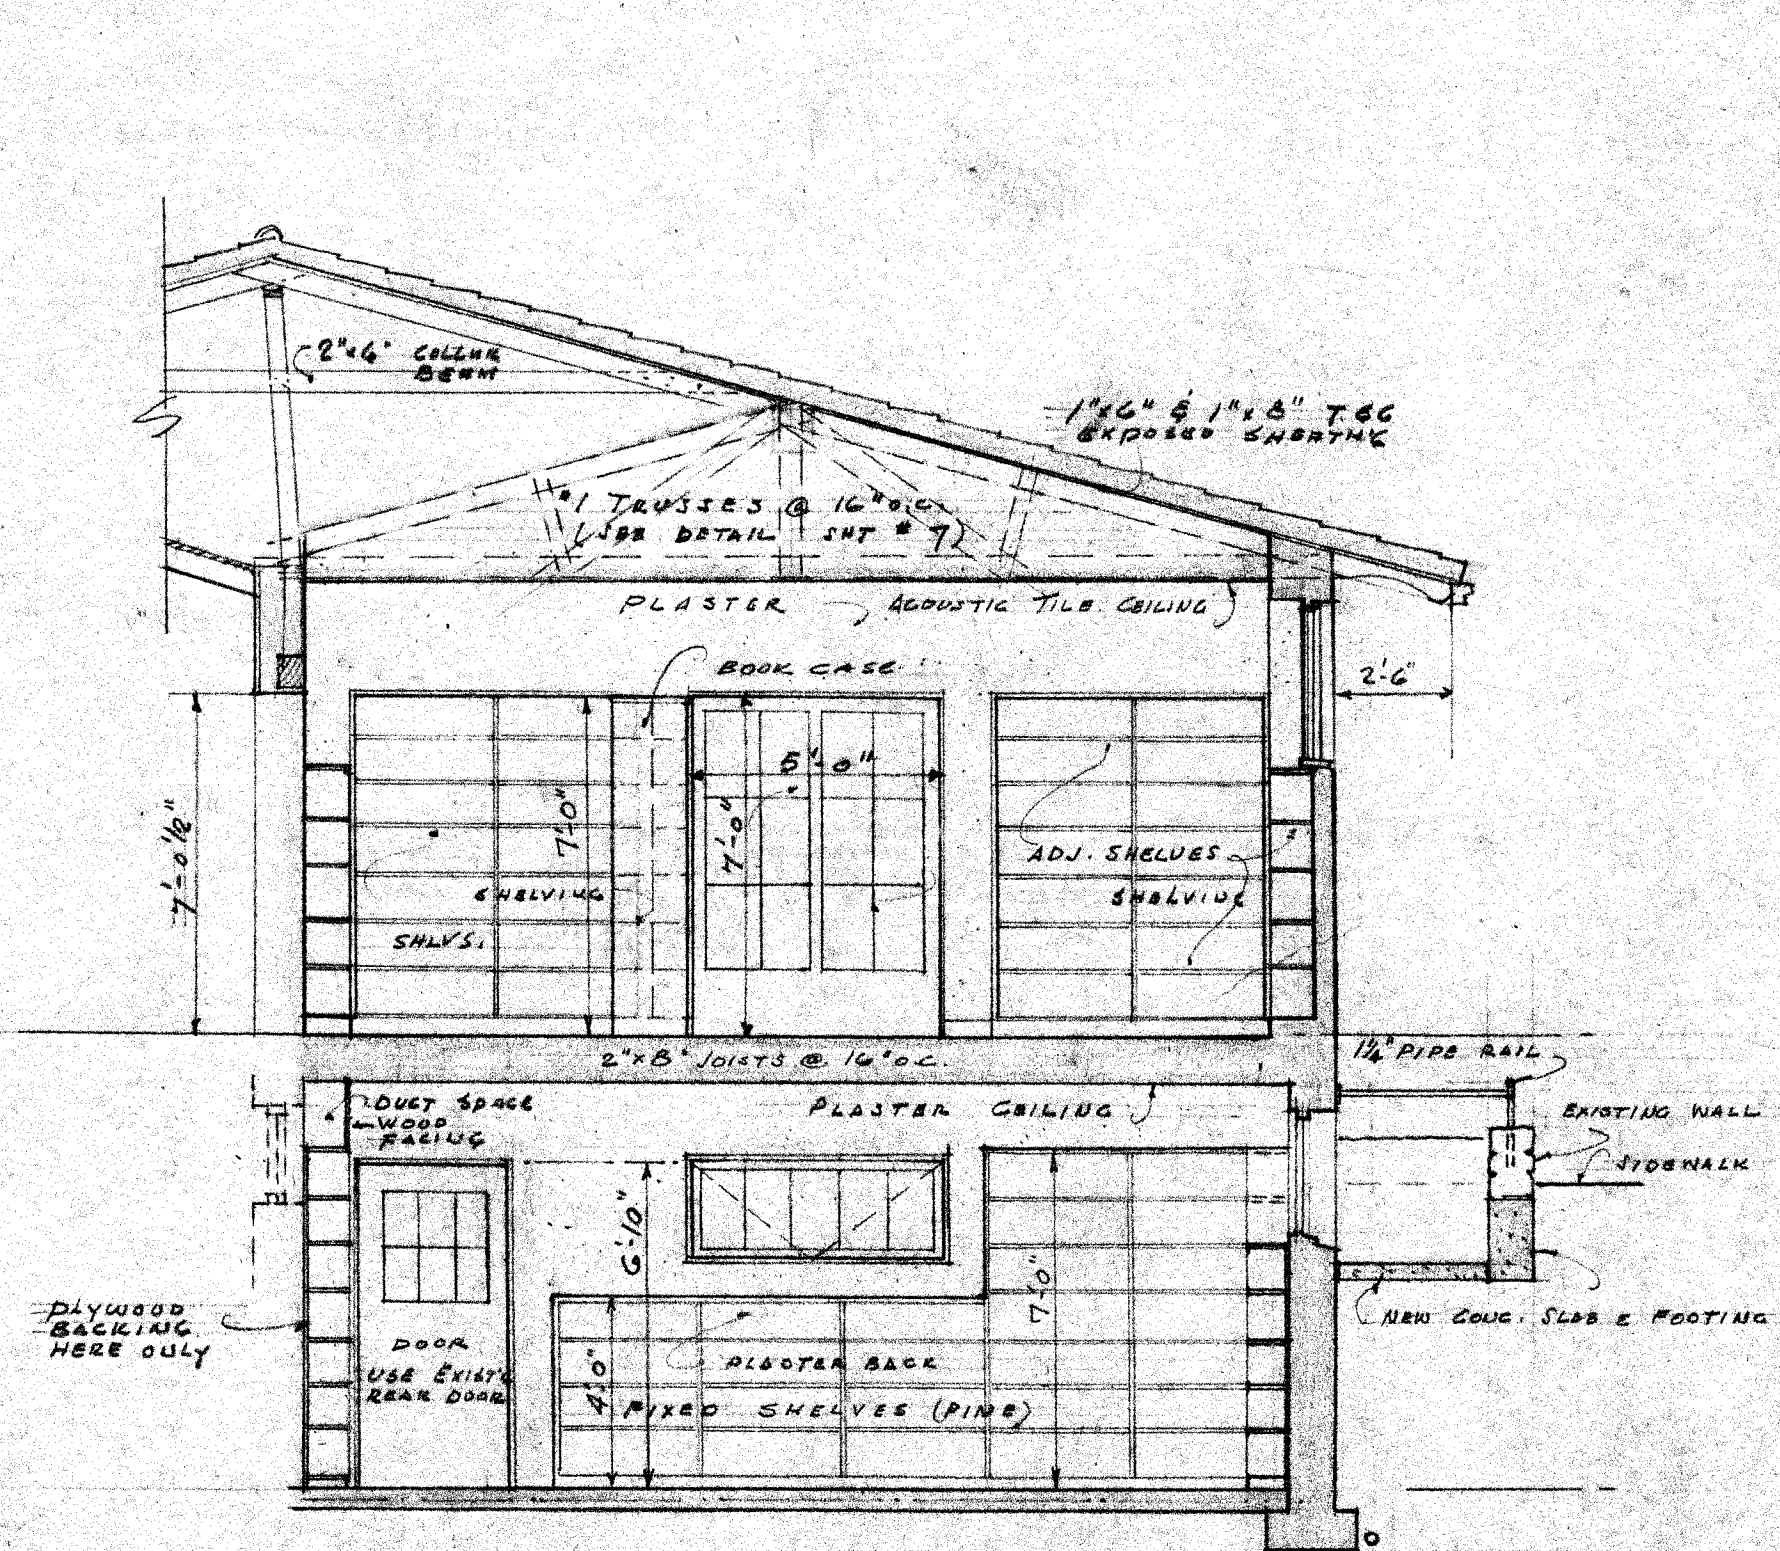


SECTION F-F
LOOKING WEST

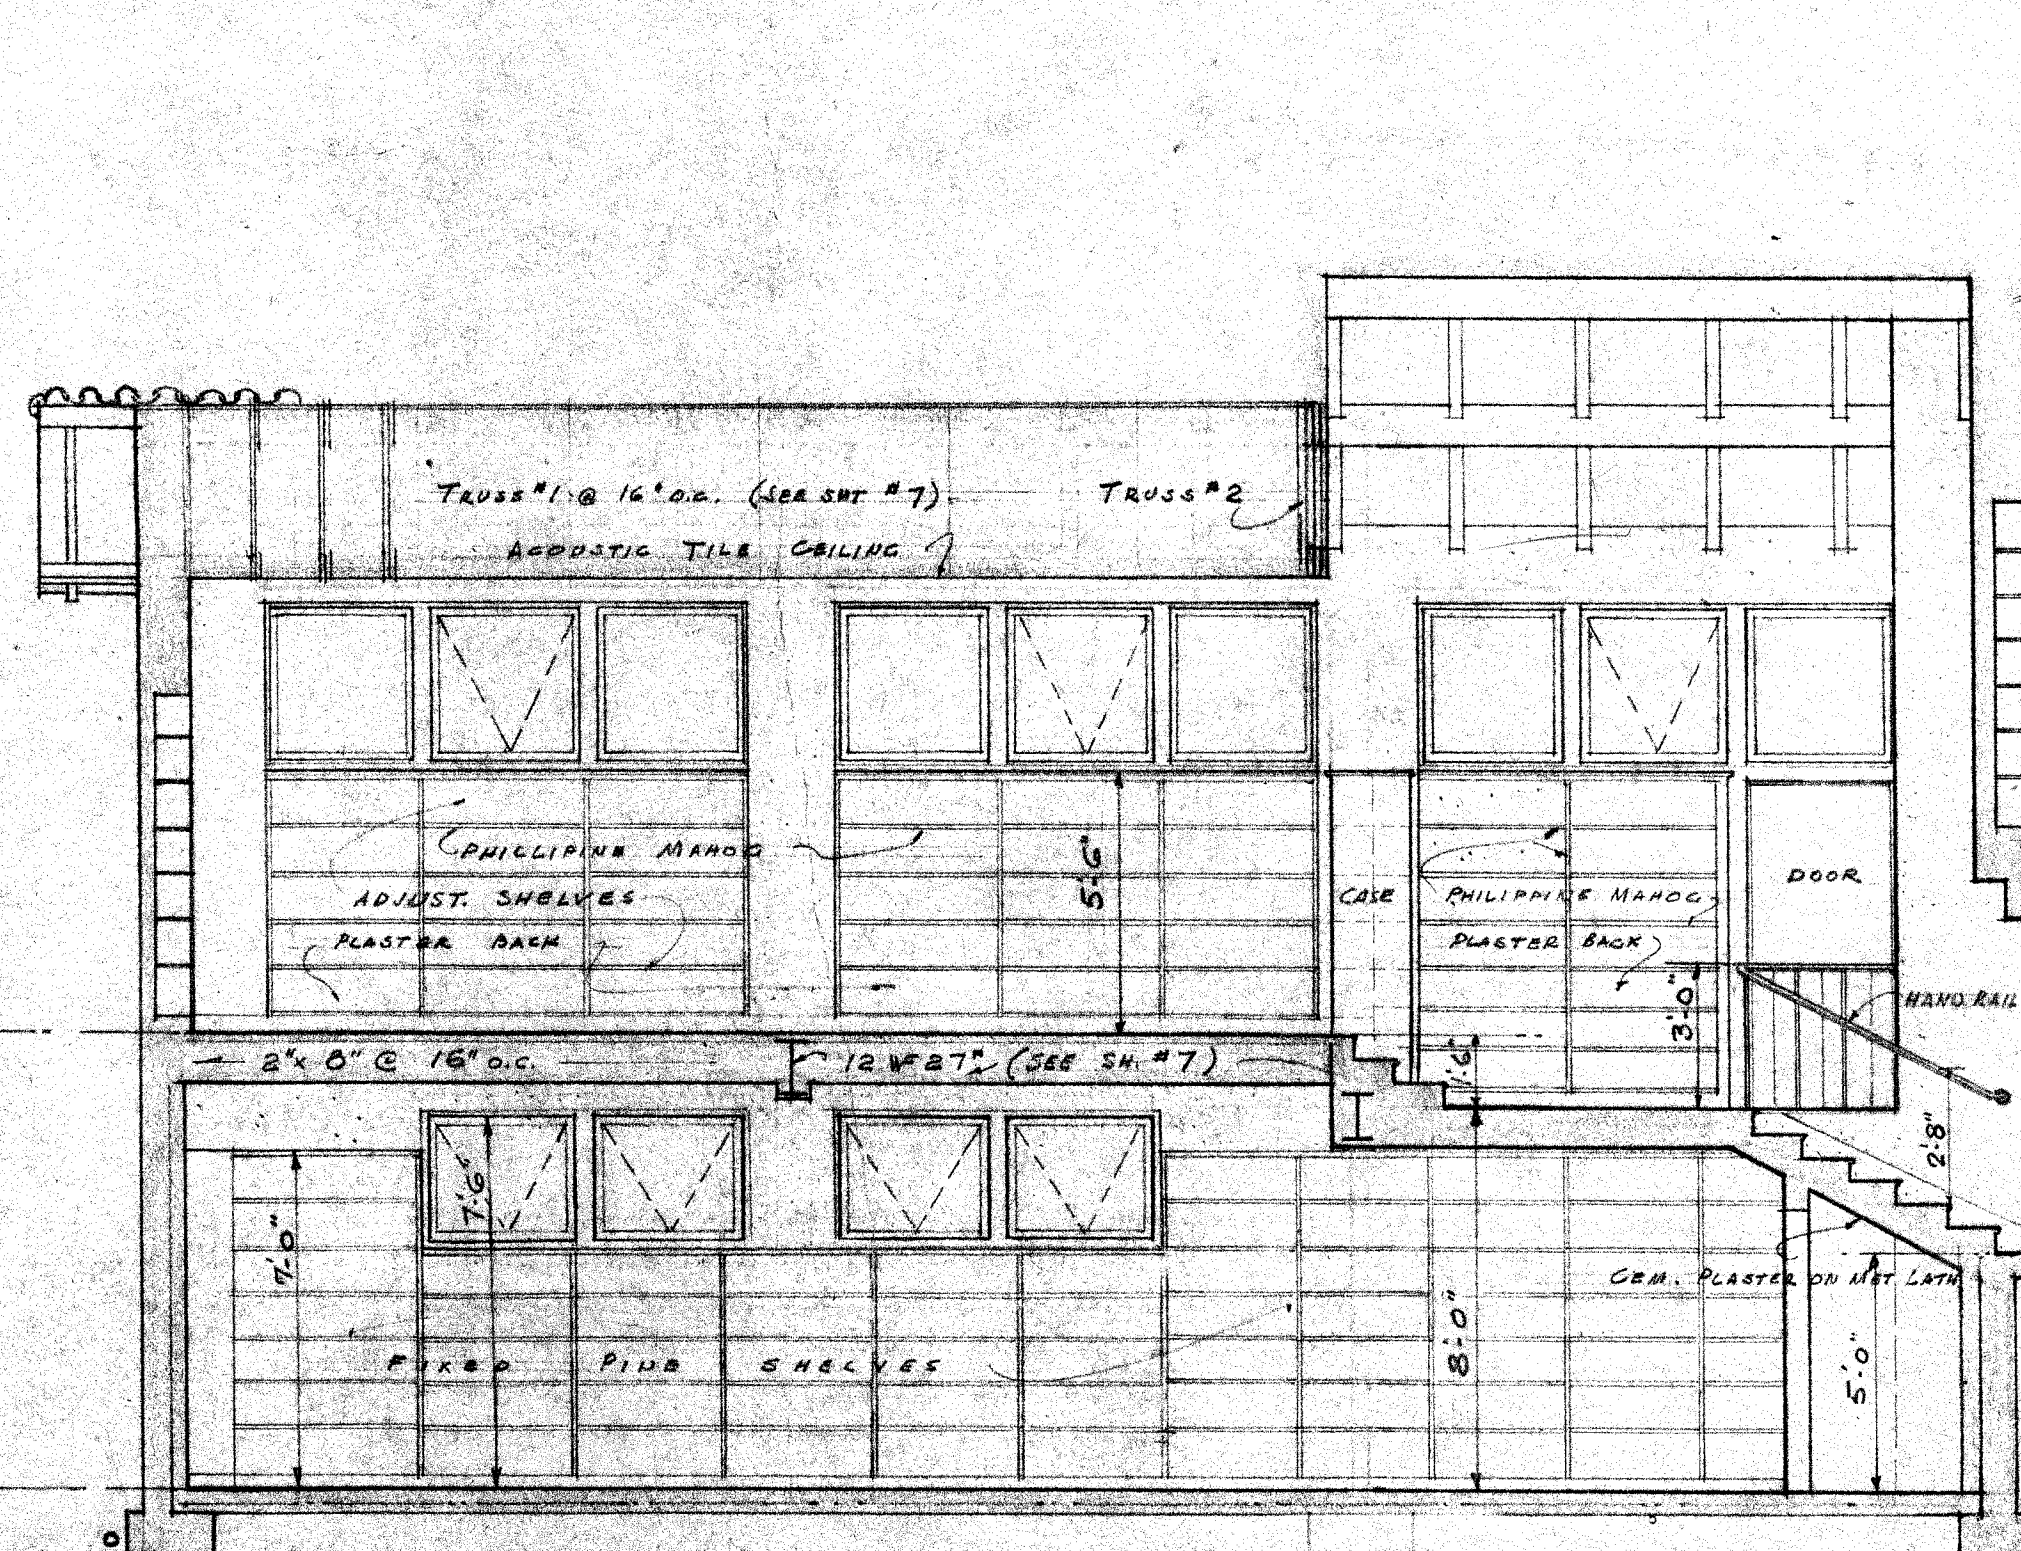





SECTION G-G
LOOKING NORTH

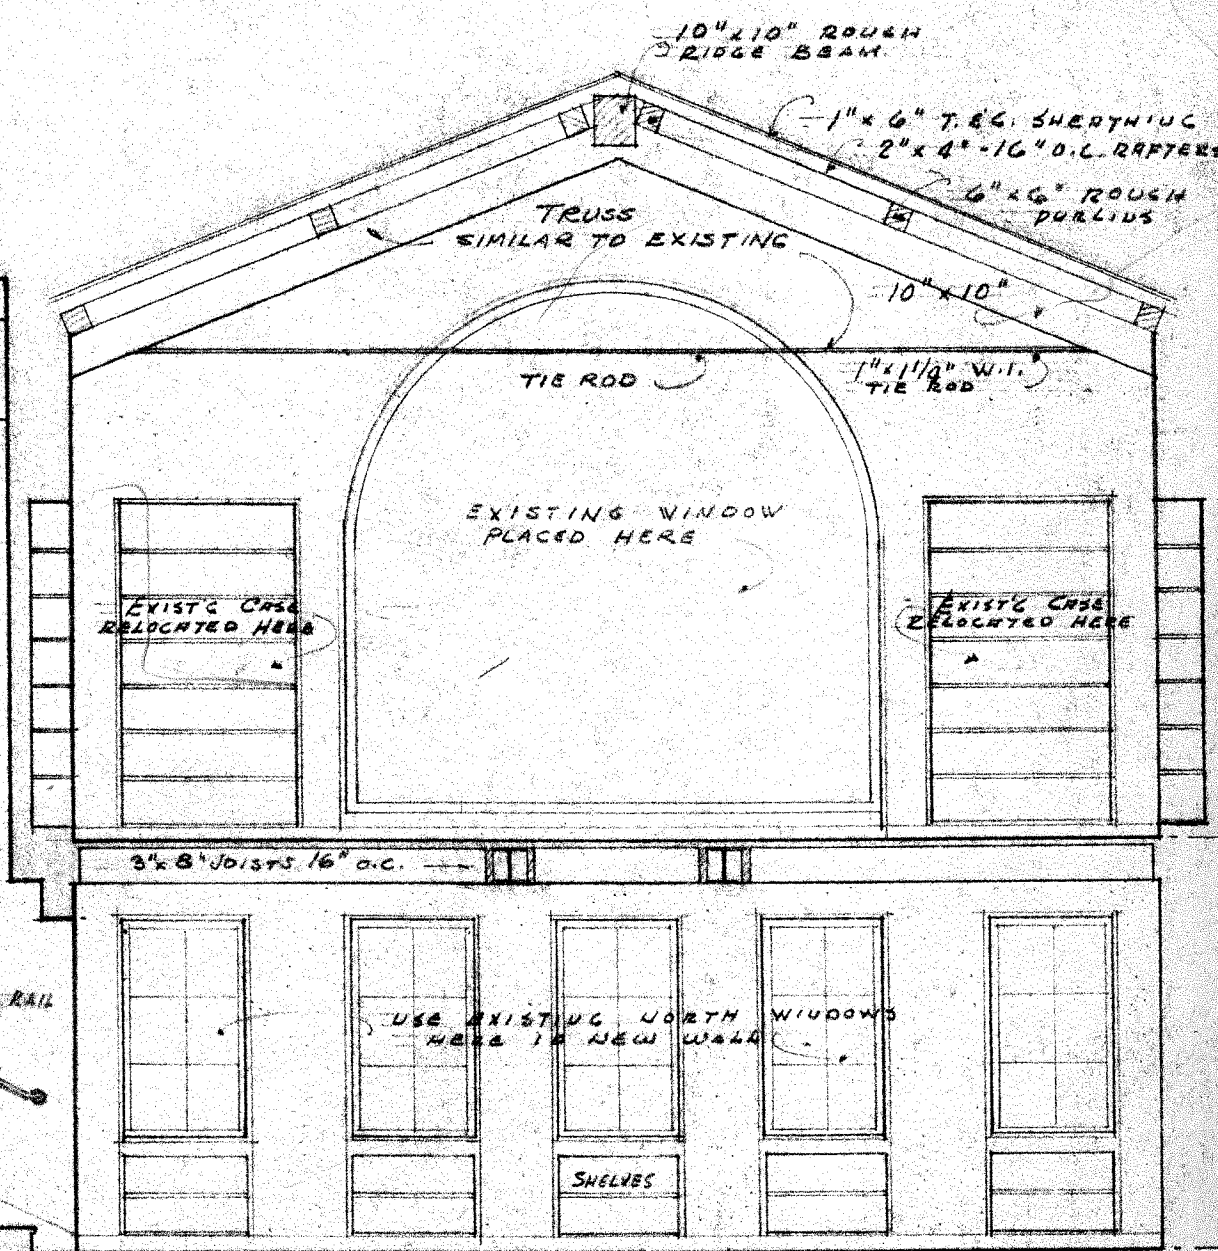

6	ALTERATIONS & ADDITIONS	ISS NO.	4820
5	HARRISON MEMORIAL	DRWG BY	S.J.S.
4	LIBRARY	CHK BY	HTS
3	CARMEL CALIF.	DATE	4/29/49
2	ROBERT R. JONES, ARCHITECT	BY	REV
1	BOX 927 - CARMEL, CALIFORNIA - PHONE 347	DATE	4/29/49
SECTIONS (D) (E) (F) & (G)		OF	8

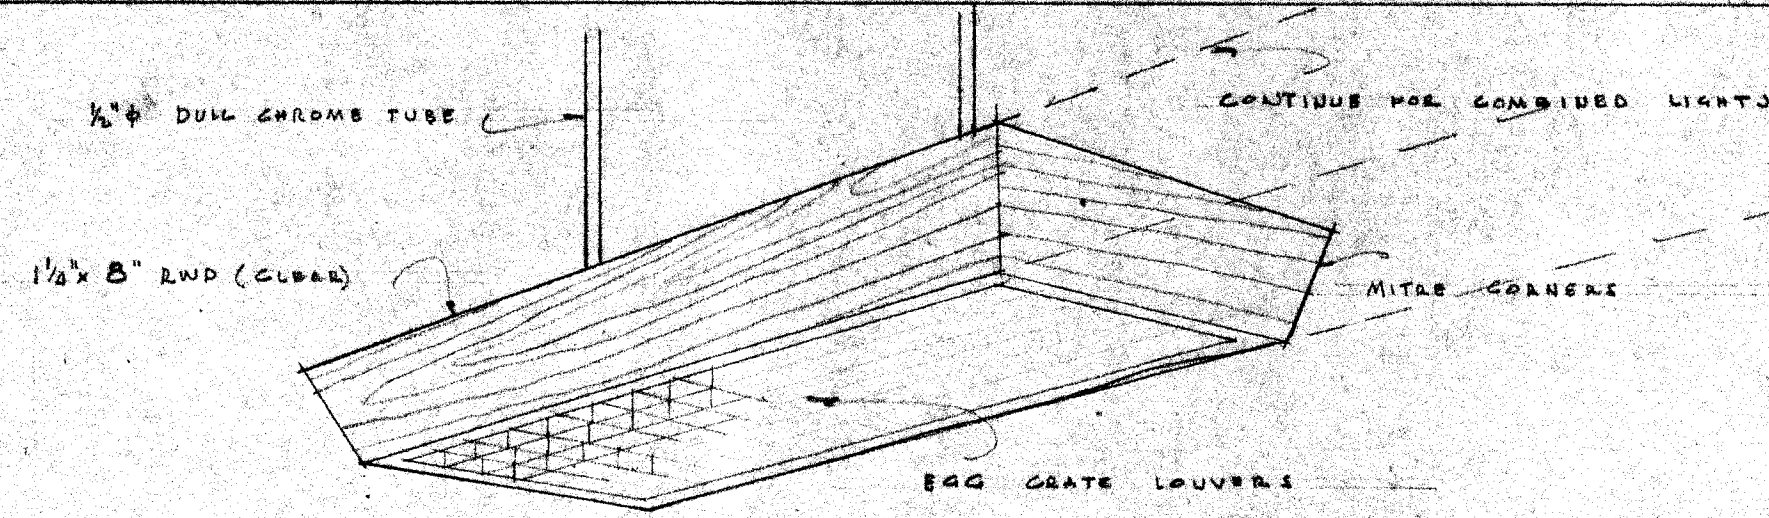

PERSPECTIVE SKETCH OF LIGHT

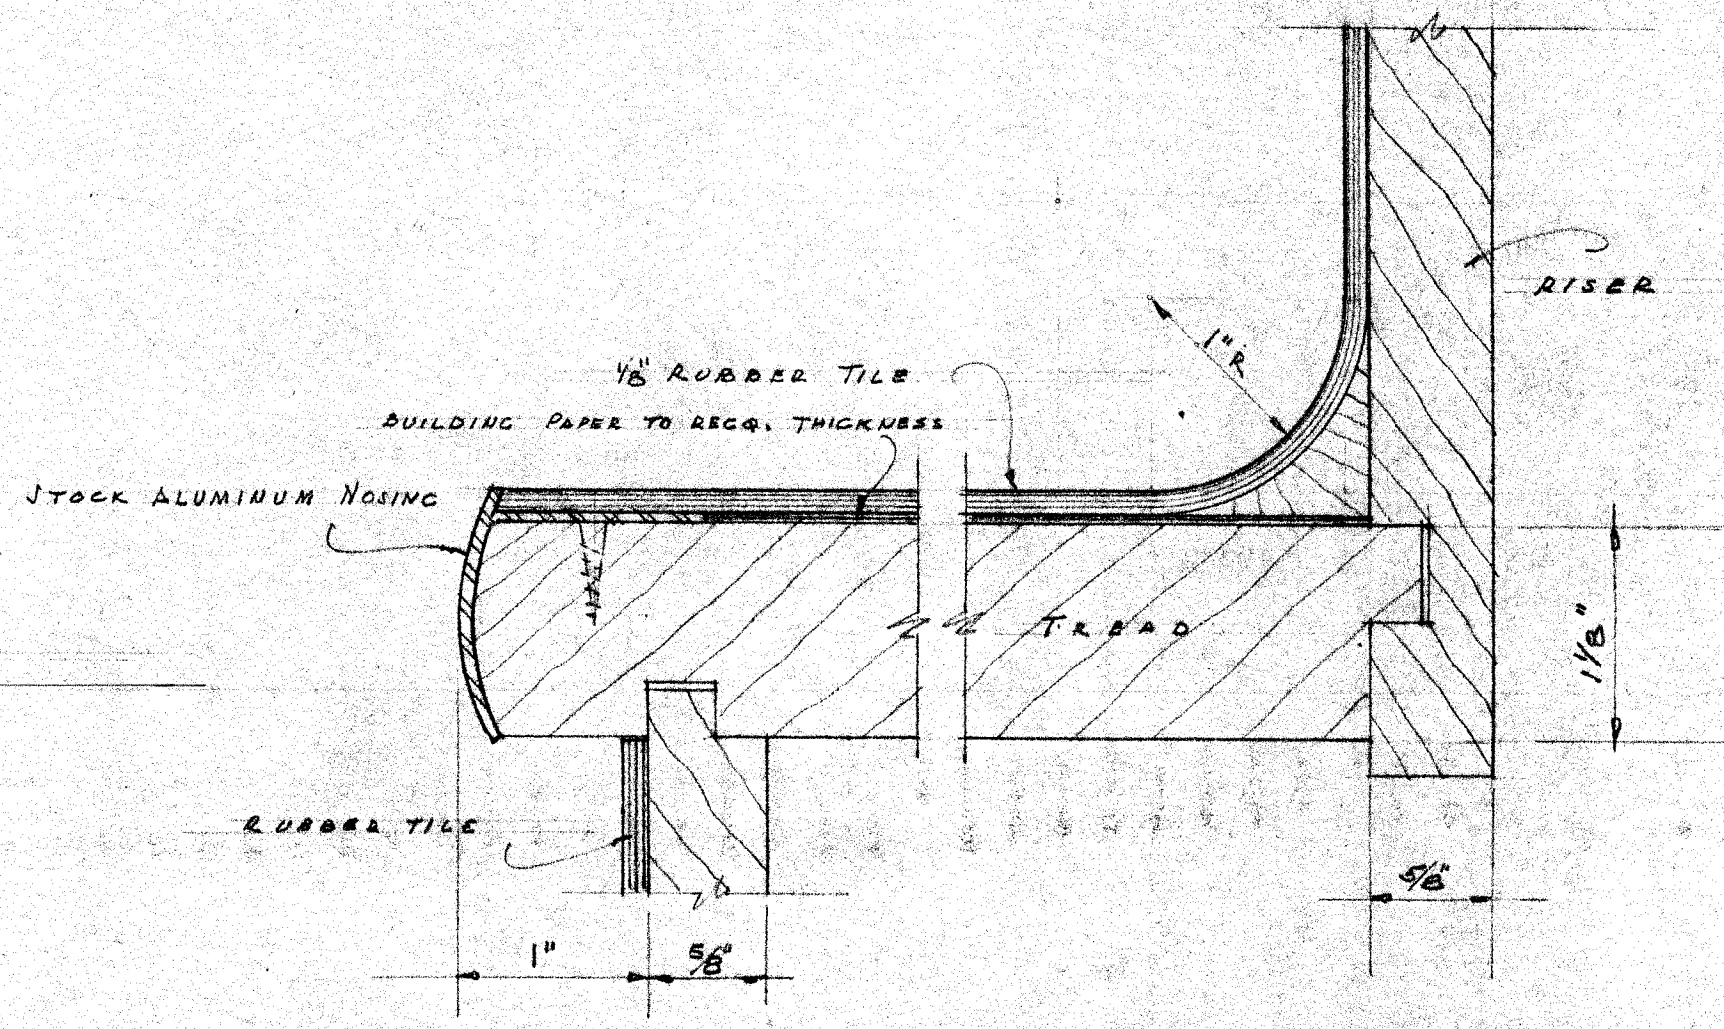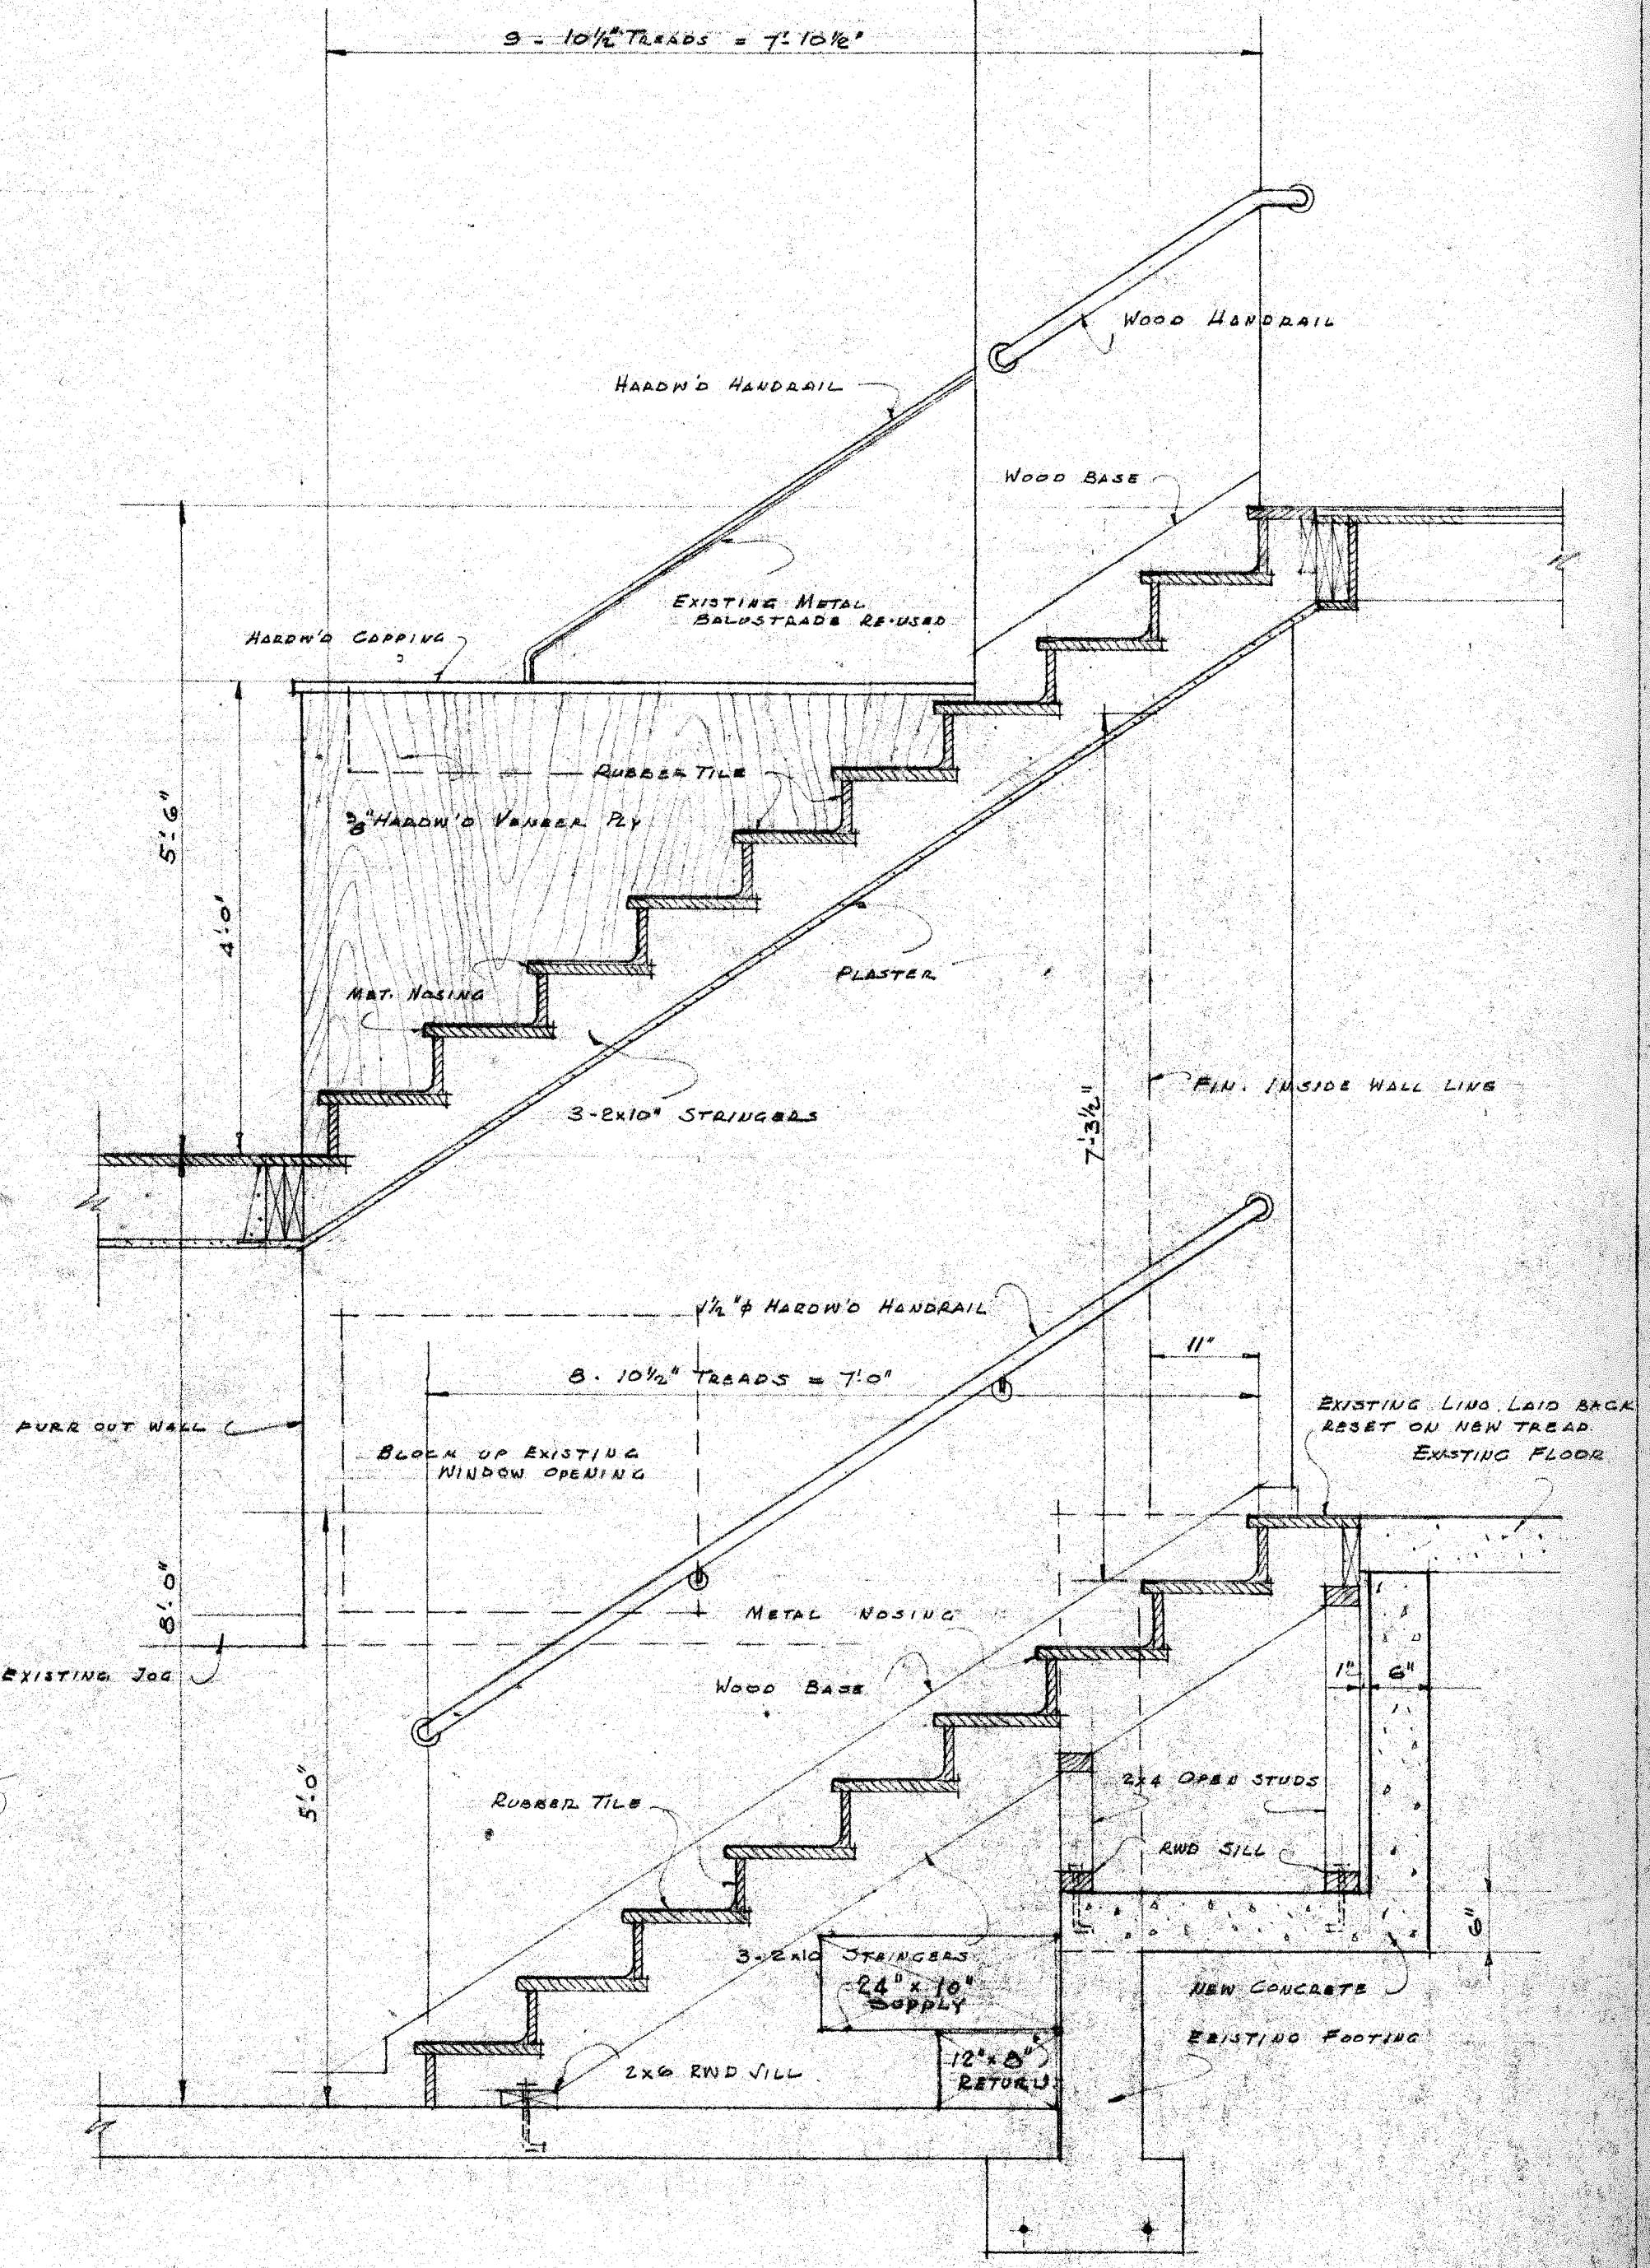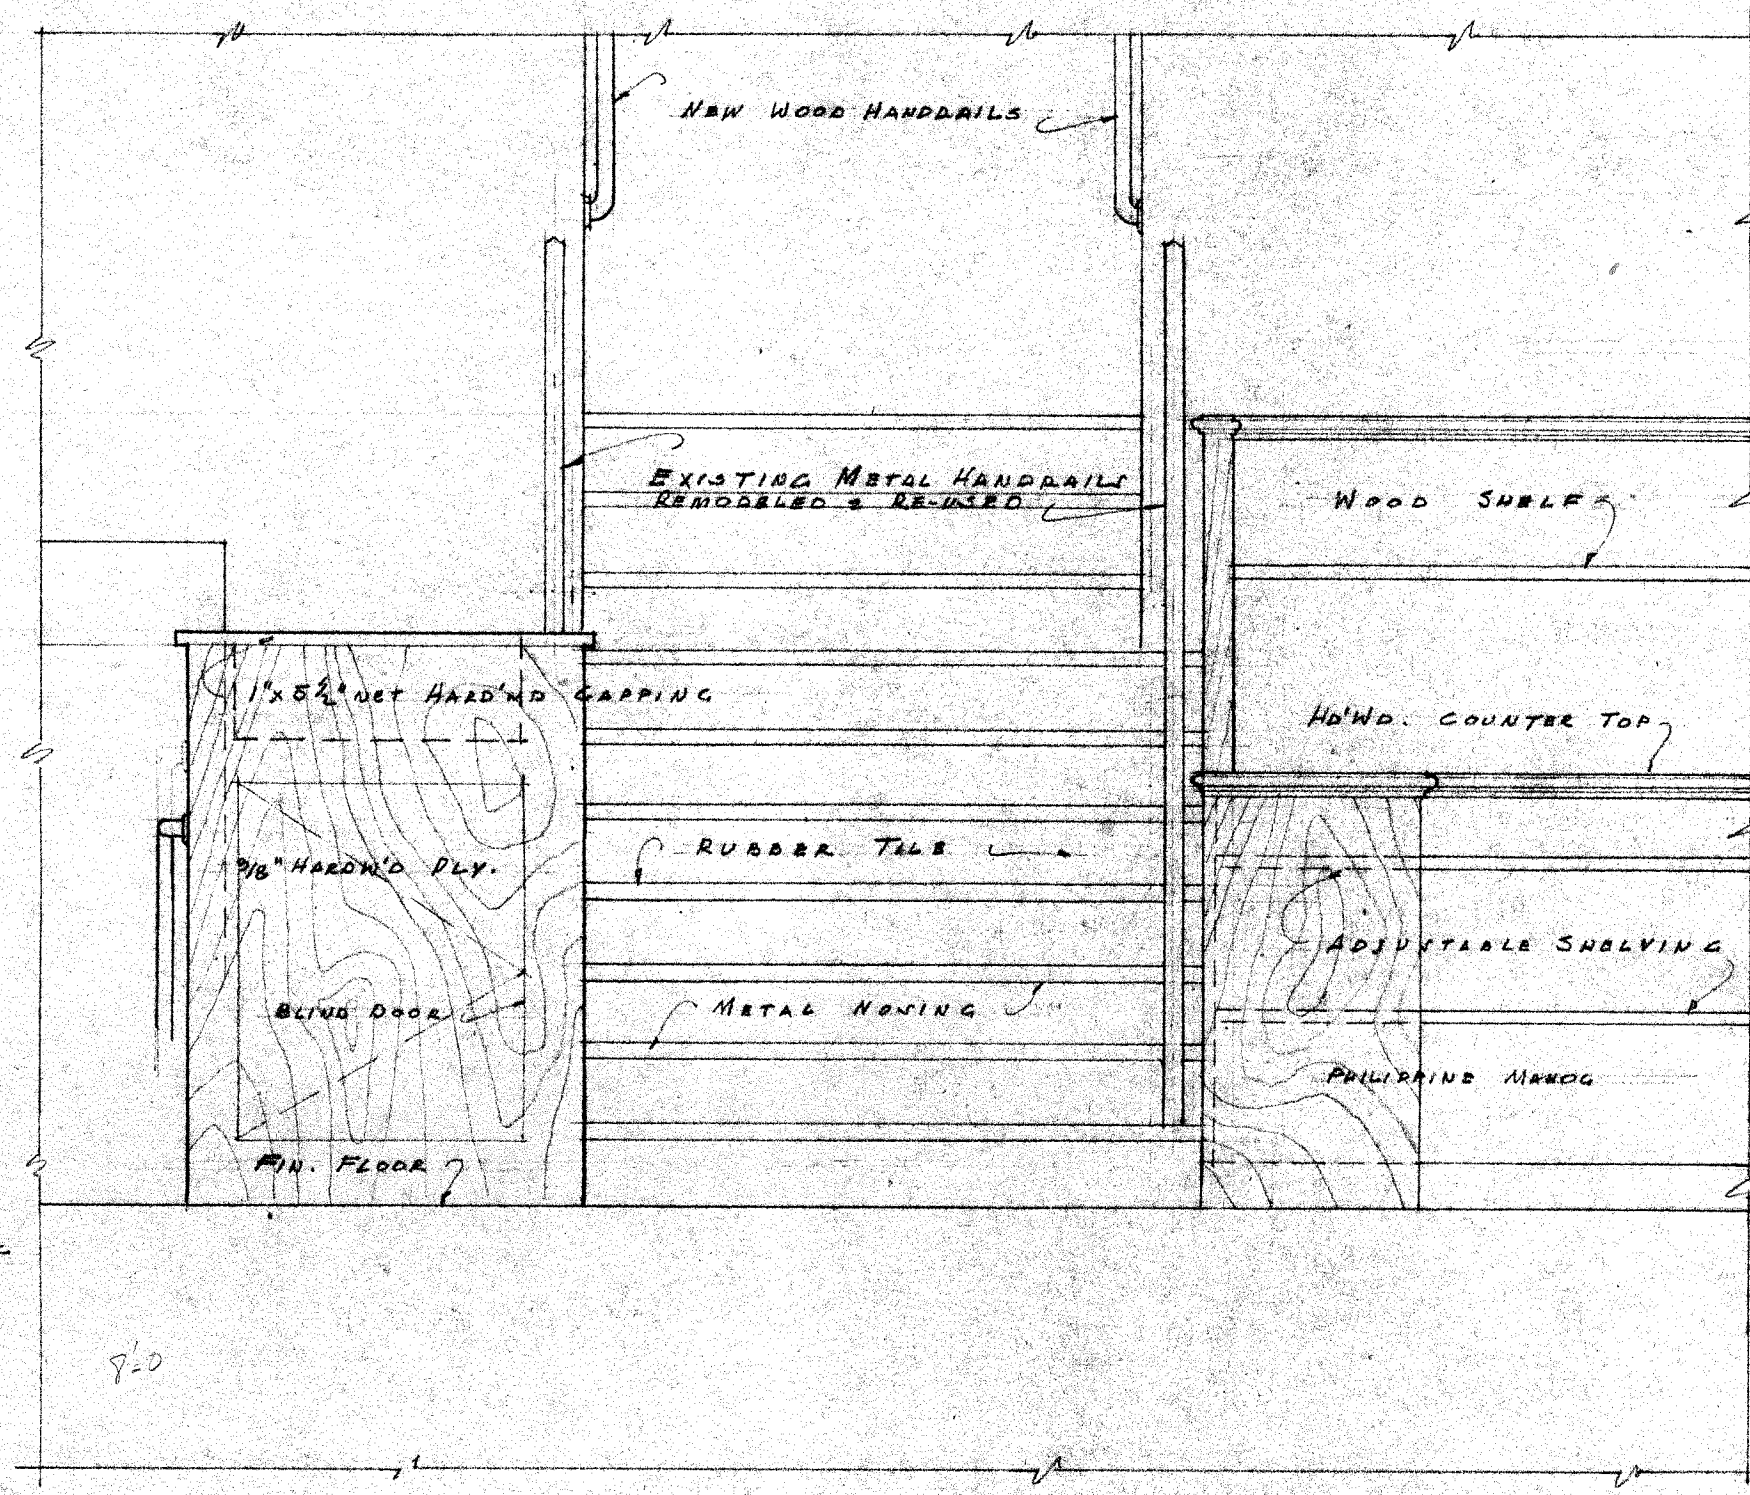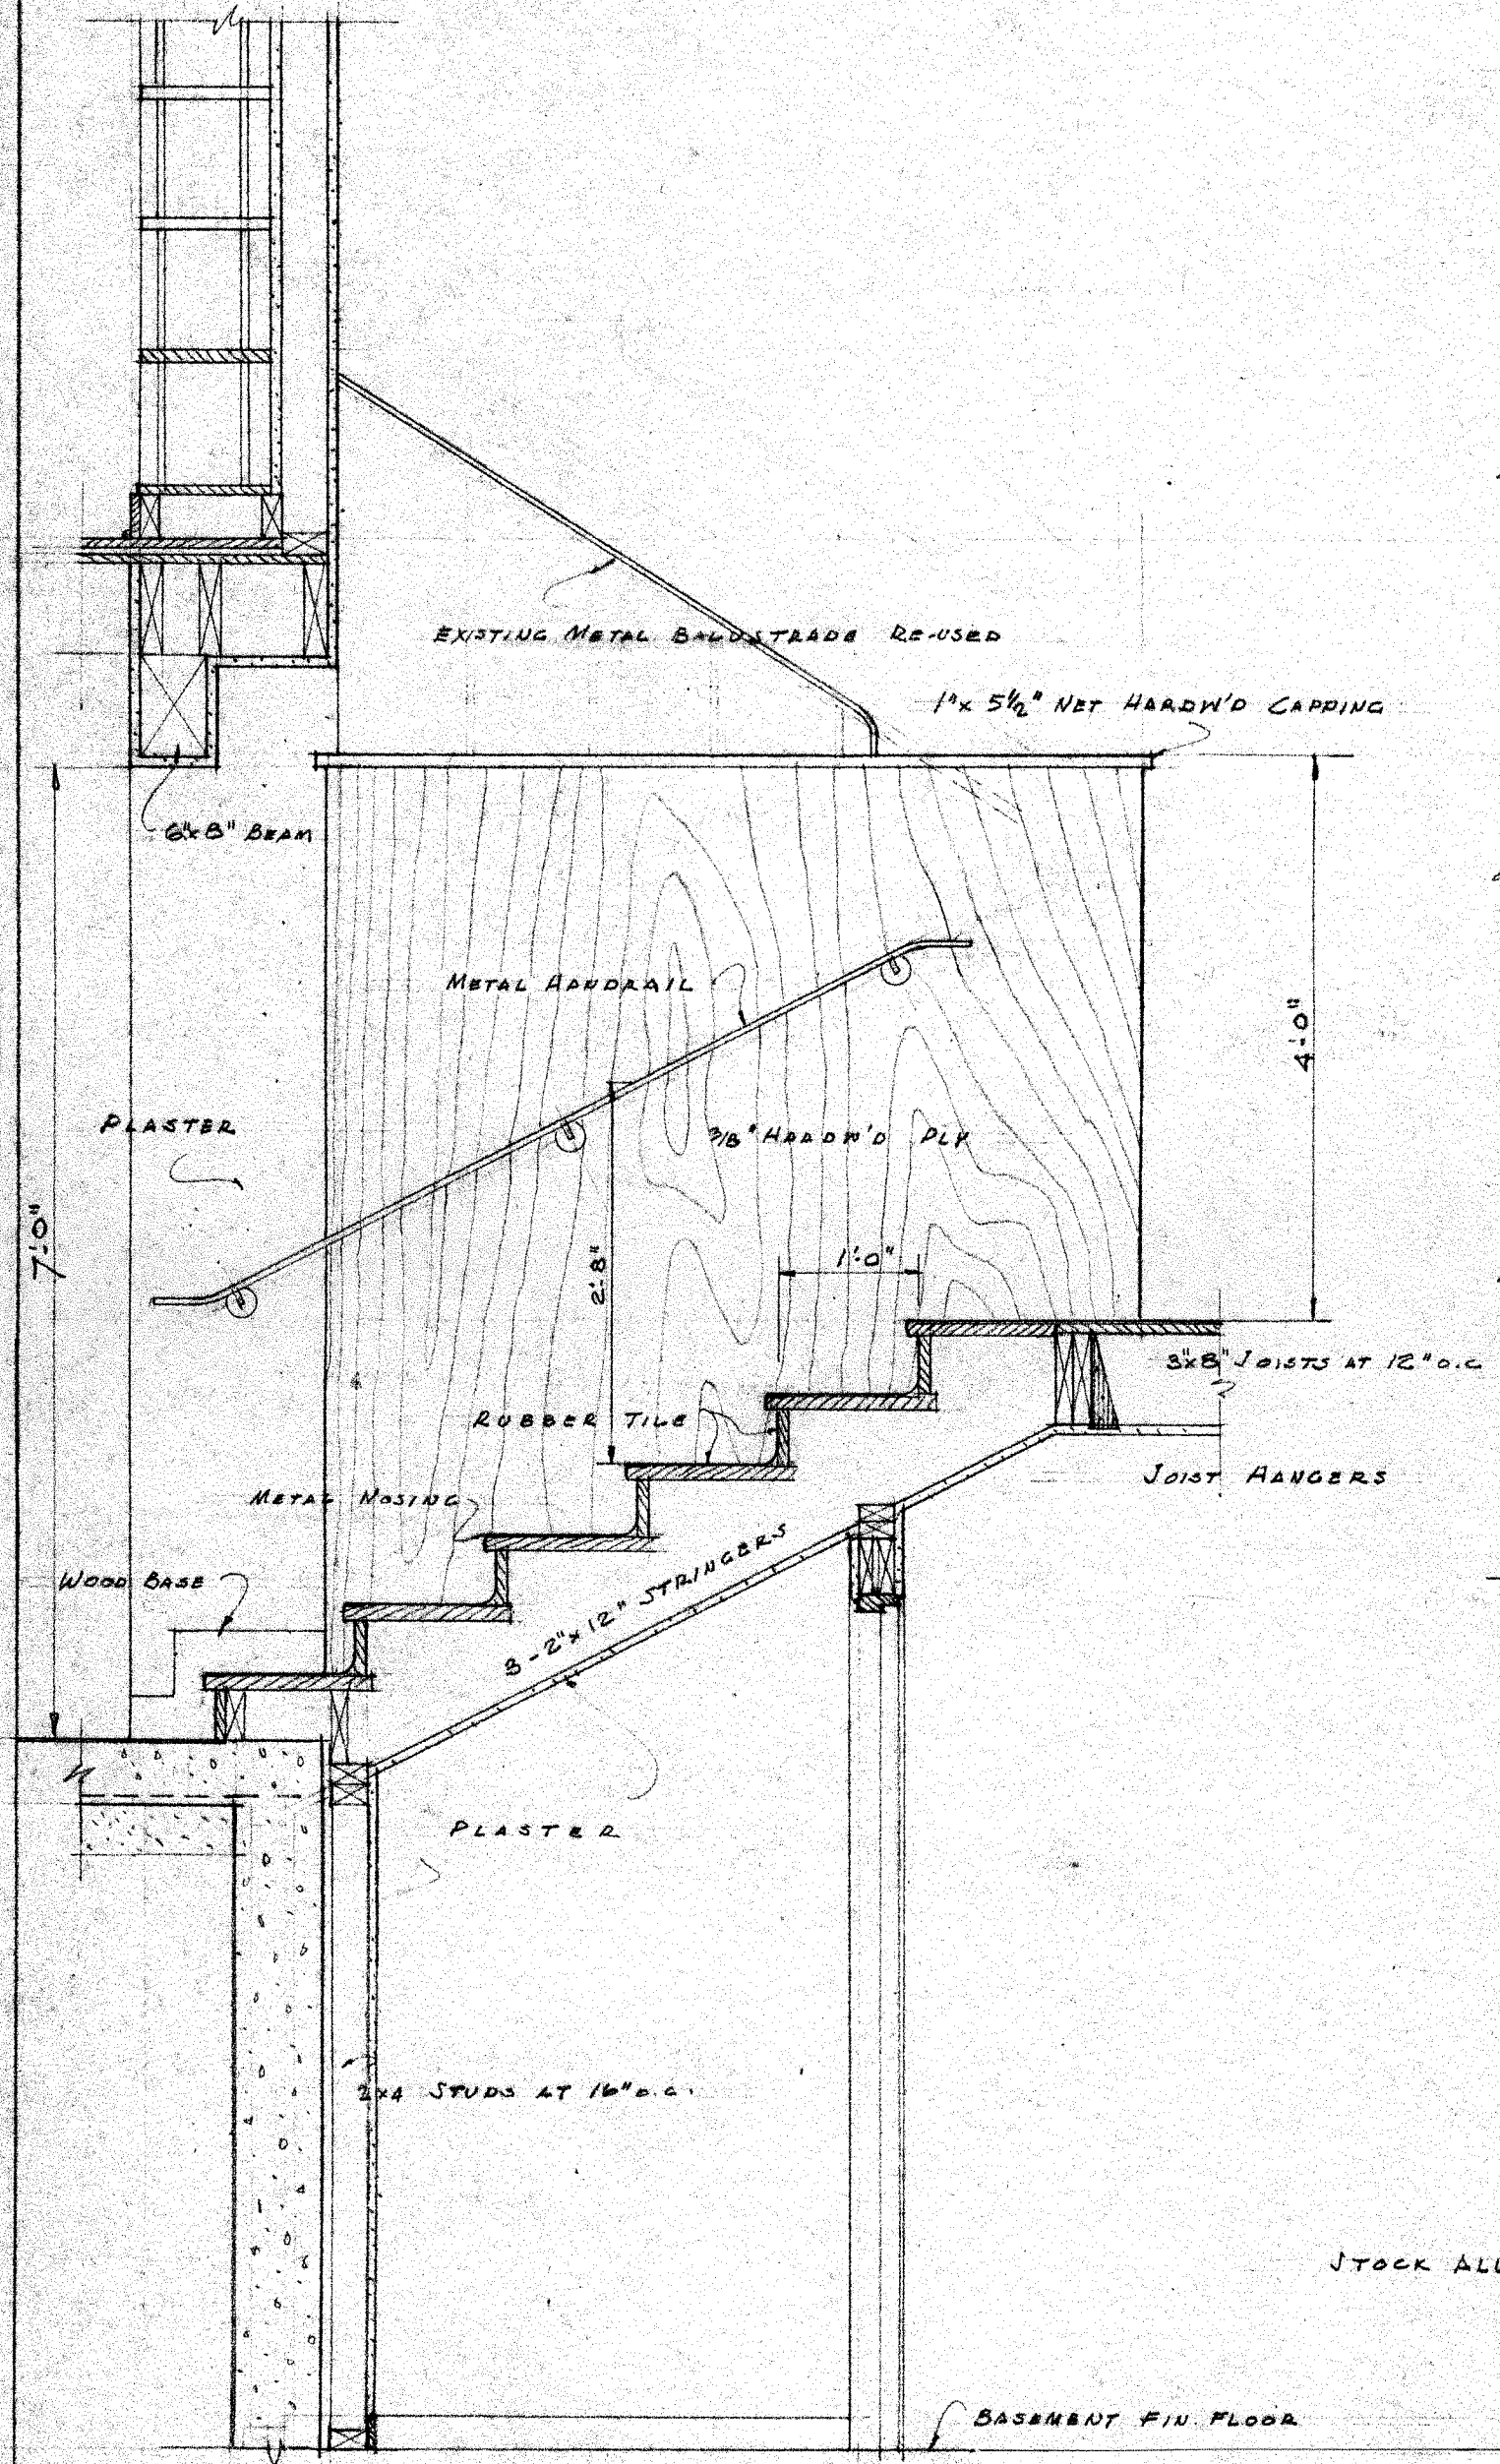



F.S.D. STAIR NOSING & COVE

SCALE 3/4" = 1'-0"


6	ALTERATIONS & ADDITIONS	JOB NO.	4820
5	HARRISON MEMORIAL	DRWG BY	S J S
4	CARMEL LIBRARY CALIFORNIA	CHK BY	H.T.S.
3		SHEET	8
2	ROBERT R. JONES, ARCHITECT	OF 8	
1	BOX 927 - CARMEL, CALIFORNIA - PHONE 247		
Date	By	Rev.	Issued
7/29/47			

 FIXTURE SCHEDULE

A	LEADER, MODEL "LRL-440" WITH 4-48" T12 FLUORESCENT LAMPS, MOUNTING PENDANTS & 1/4" x 8" REDWD. FASCIA.	READING ROOM: BOTTOMS OF FIXTURES 12'-6" ABOVE FIN. FL. CHILDREN'S ROOM: BOTTOMS OF FIXTURES 8'-0" ABOVE FIN. FL.
B	ALL-BRIGHT, MODEL "RUL-400" WITH LOUVER BOTTOM, 4-40 WATT 48" FLUORESCENT LAMPS, GLASS SIDE PANELS & MOUNTING PENDANTS.	LOBBY & REFERENCE ROOM: BOTTOMS OF FIXTURES 9'-0" ABOVE FIN. FL.
C	ALL-BRIGHT, "XUG-296" - WITH FLUORESCENT TUBES	CEILING MOUNTED: 
D	ALL-BRIGHT "XUG-272" - WITH FLUORESCENT TUBES.	SAME
E	LEADER, MODEL "NHT-280" RECESSED TROFFER, 2-96" SLIMLINE TUBES, MOULDED PLASTIC LOUVERS	SAME
F	LEADER, MODEL "NHT-280" RECESSED TROFFER, 2-72" SLIMLINE TUBES, MOULDED PLASTIC LOUVERS.	SAME
G	LEADER, MODEL "NHT-280" RECESSED TROFFER, 1-96" SLIMLINE TUBE, MOULDED PLASTIC LOUVERS.	SAME
H	LEADER, MODEL "TS-240", 3-40-WATT, 48" LAMPS. MOULDED PLASTIC LOUVERS	SAME
J	ALL-BRIGHT, MODEL "RUL-1002" WITH LOUVER BOTTOM, 2-40 WATT 48" FLUORESCENT TUBES & MOUNTING PENDANTS.	BOTTOMS OF FIXTURES 9'-0" ABOVE FIN. FLOOR.

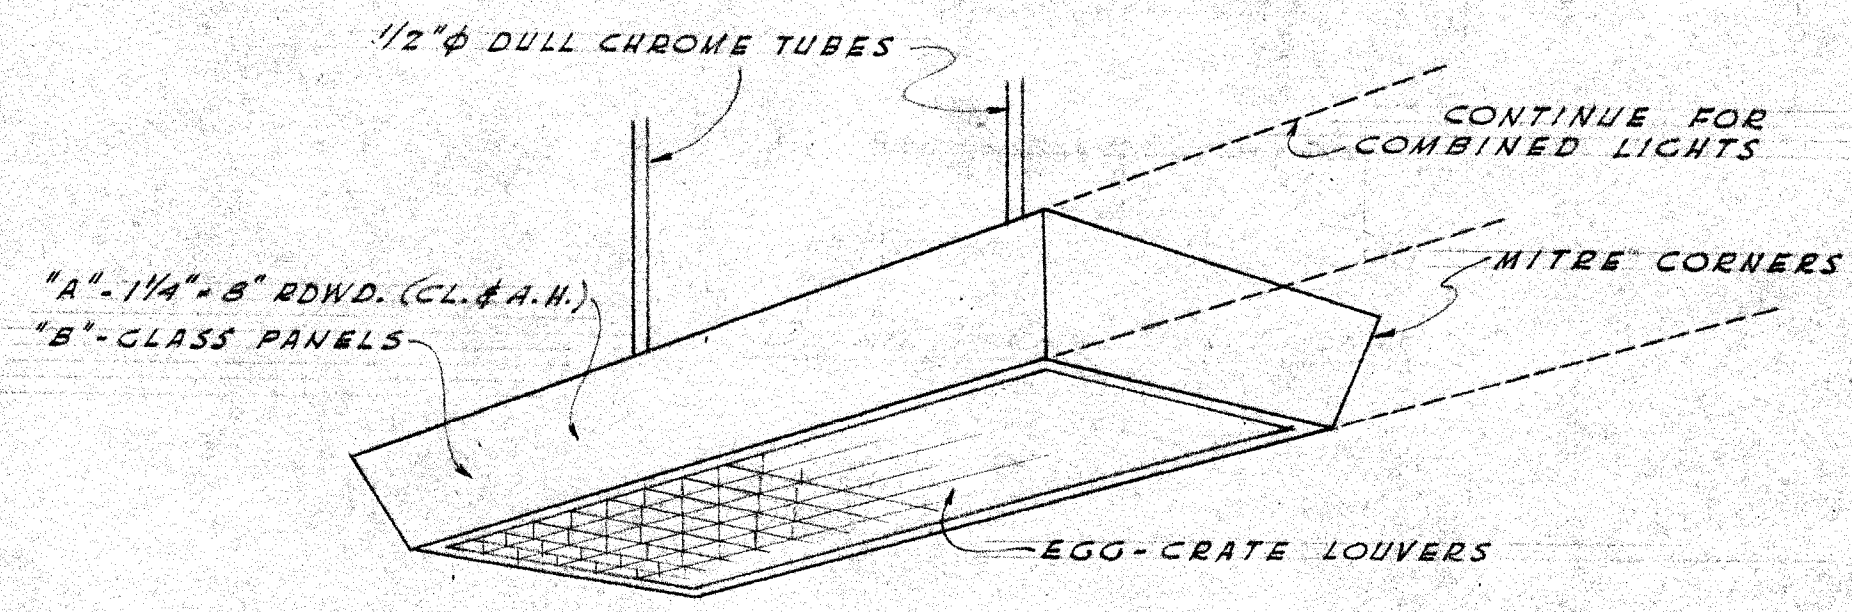

PERSPECTIVE SKETCH OF FIXTURE

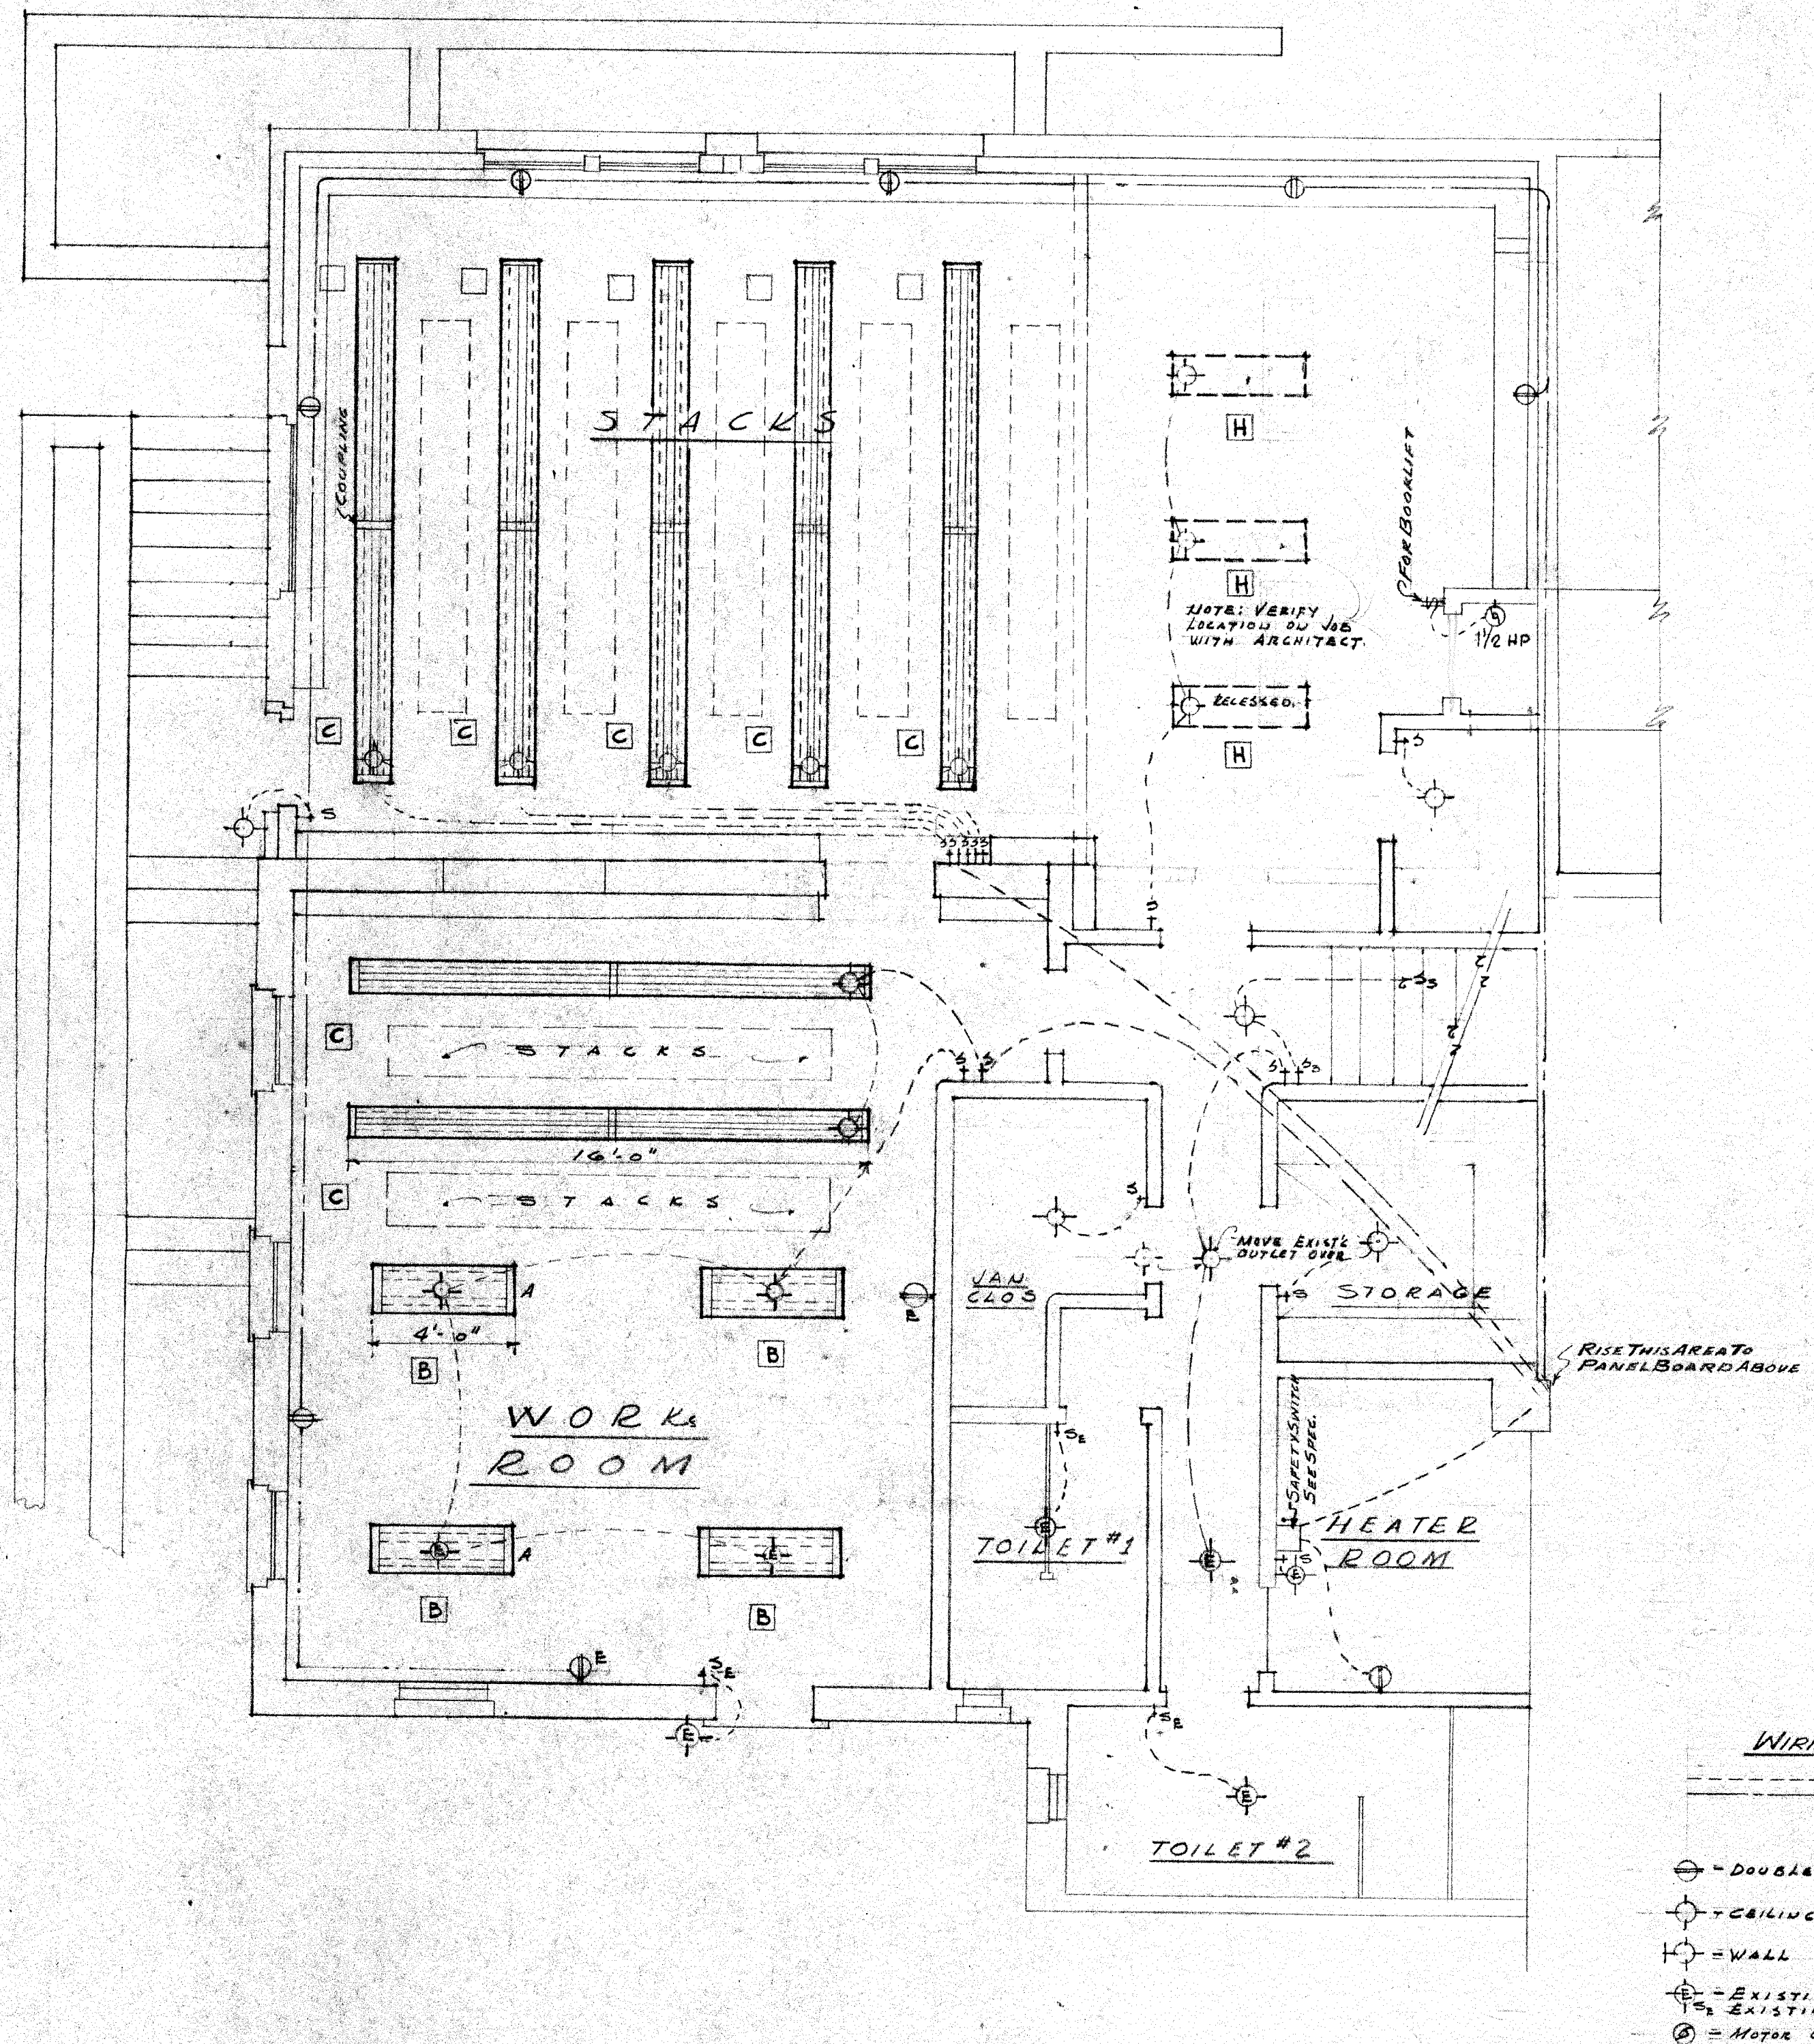

WIRING SCHEDULE

- 15 AMP CIRCUITS
- 20 AMP CIRCUITS
- ⊖ = DOUBLE WALL OUTLET
- ⊕ = CEILING OUTLET
- ⊕ = WALL OUTLET
- ⊕ = EXISTING OUTLET
- ⊕ = EXISTING SWITCH
- ⊕ = MOTOR OUTLET 1 1/2 HP



BASEMENT PLAN

SCALE 1/4" = 1'-0"

NOTE: EXISTING OUTLETS & SWITCHES MARKED "E" ARE SHOWN FOR INFORMATION AND ARE TO REMAIN.

6	WIRING & LIGHTING LAYOUT	ICB NO. 4820
5	HARRISON MEMORIAL LIBRARY	DRWG BY W.M.
4	CARMEL CALIF.	CHK BY H.T.S.
3		SHEET
2	ROBERT R. JONES, ARCHITECT	E-1
1	BOX 927 - CARMEL, CALIFORNIA - PHONE 347	OF 2
Date	By	Rev.
7/29/49		

216

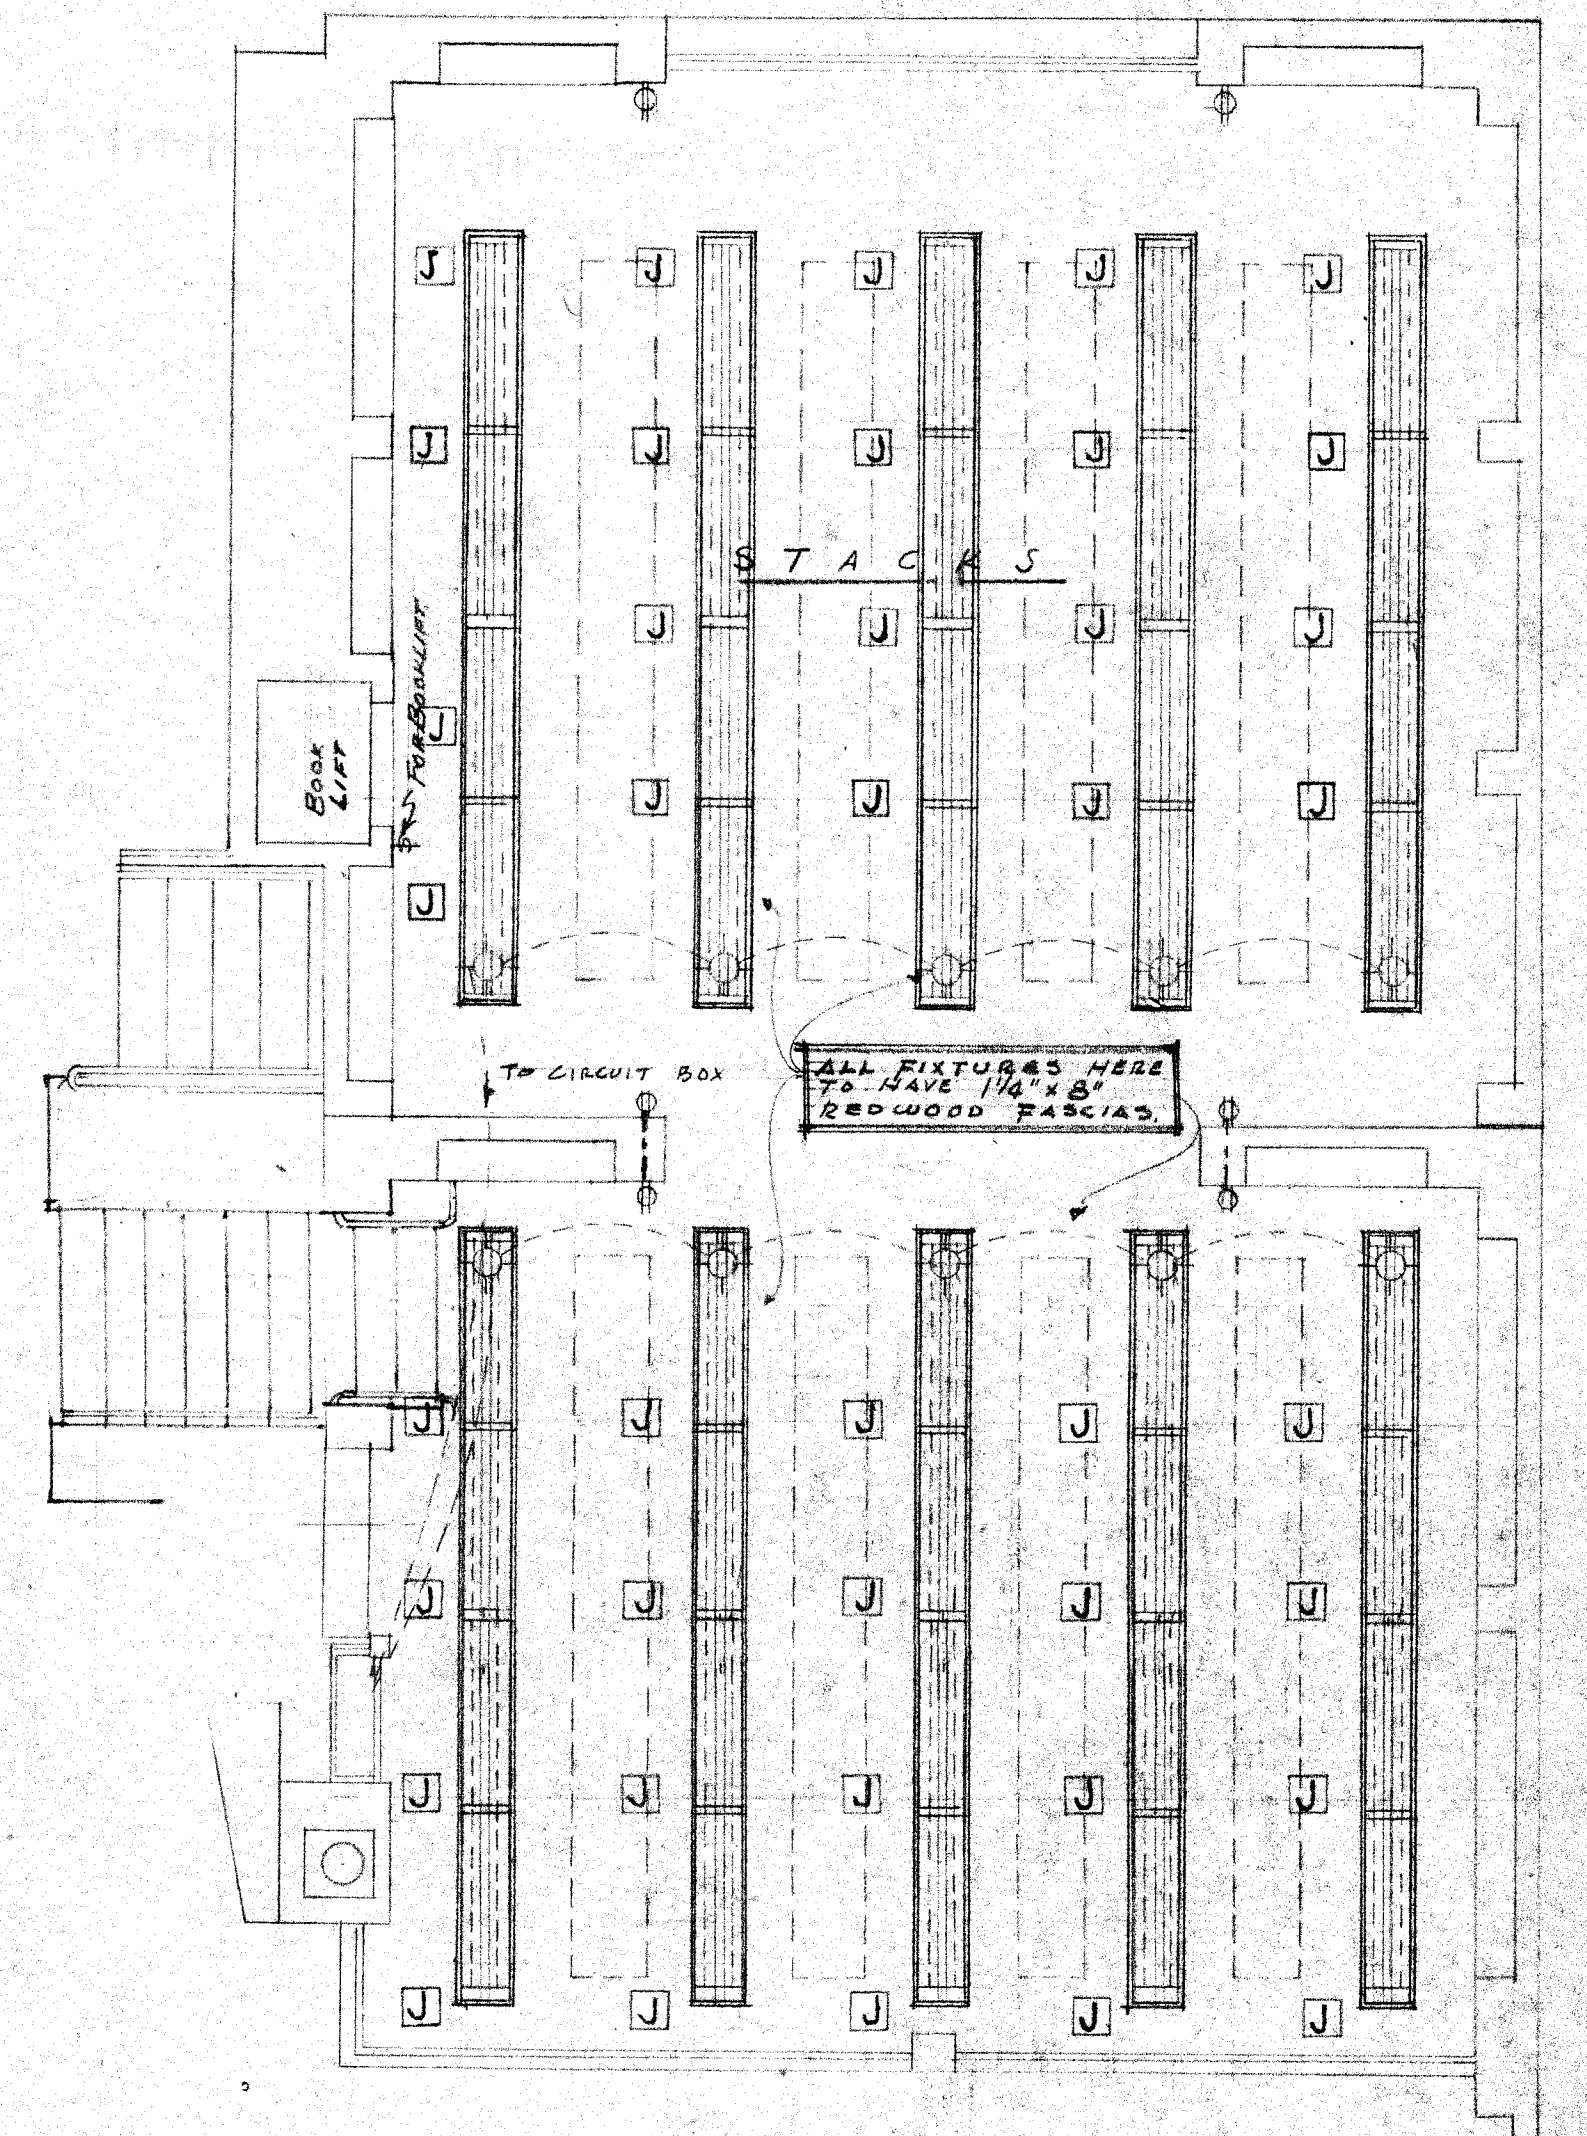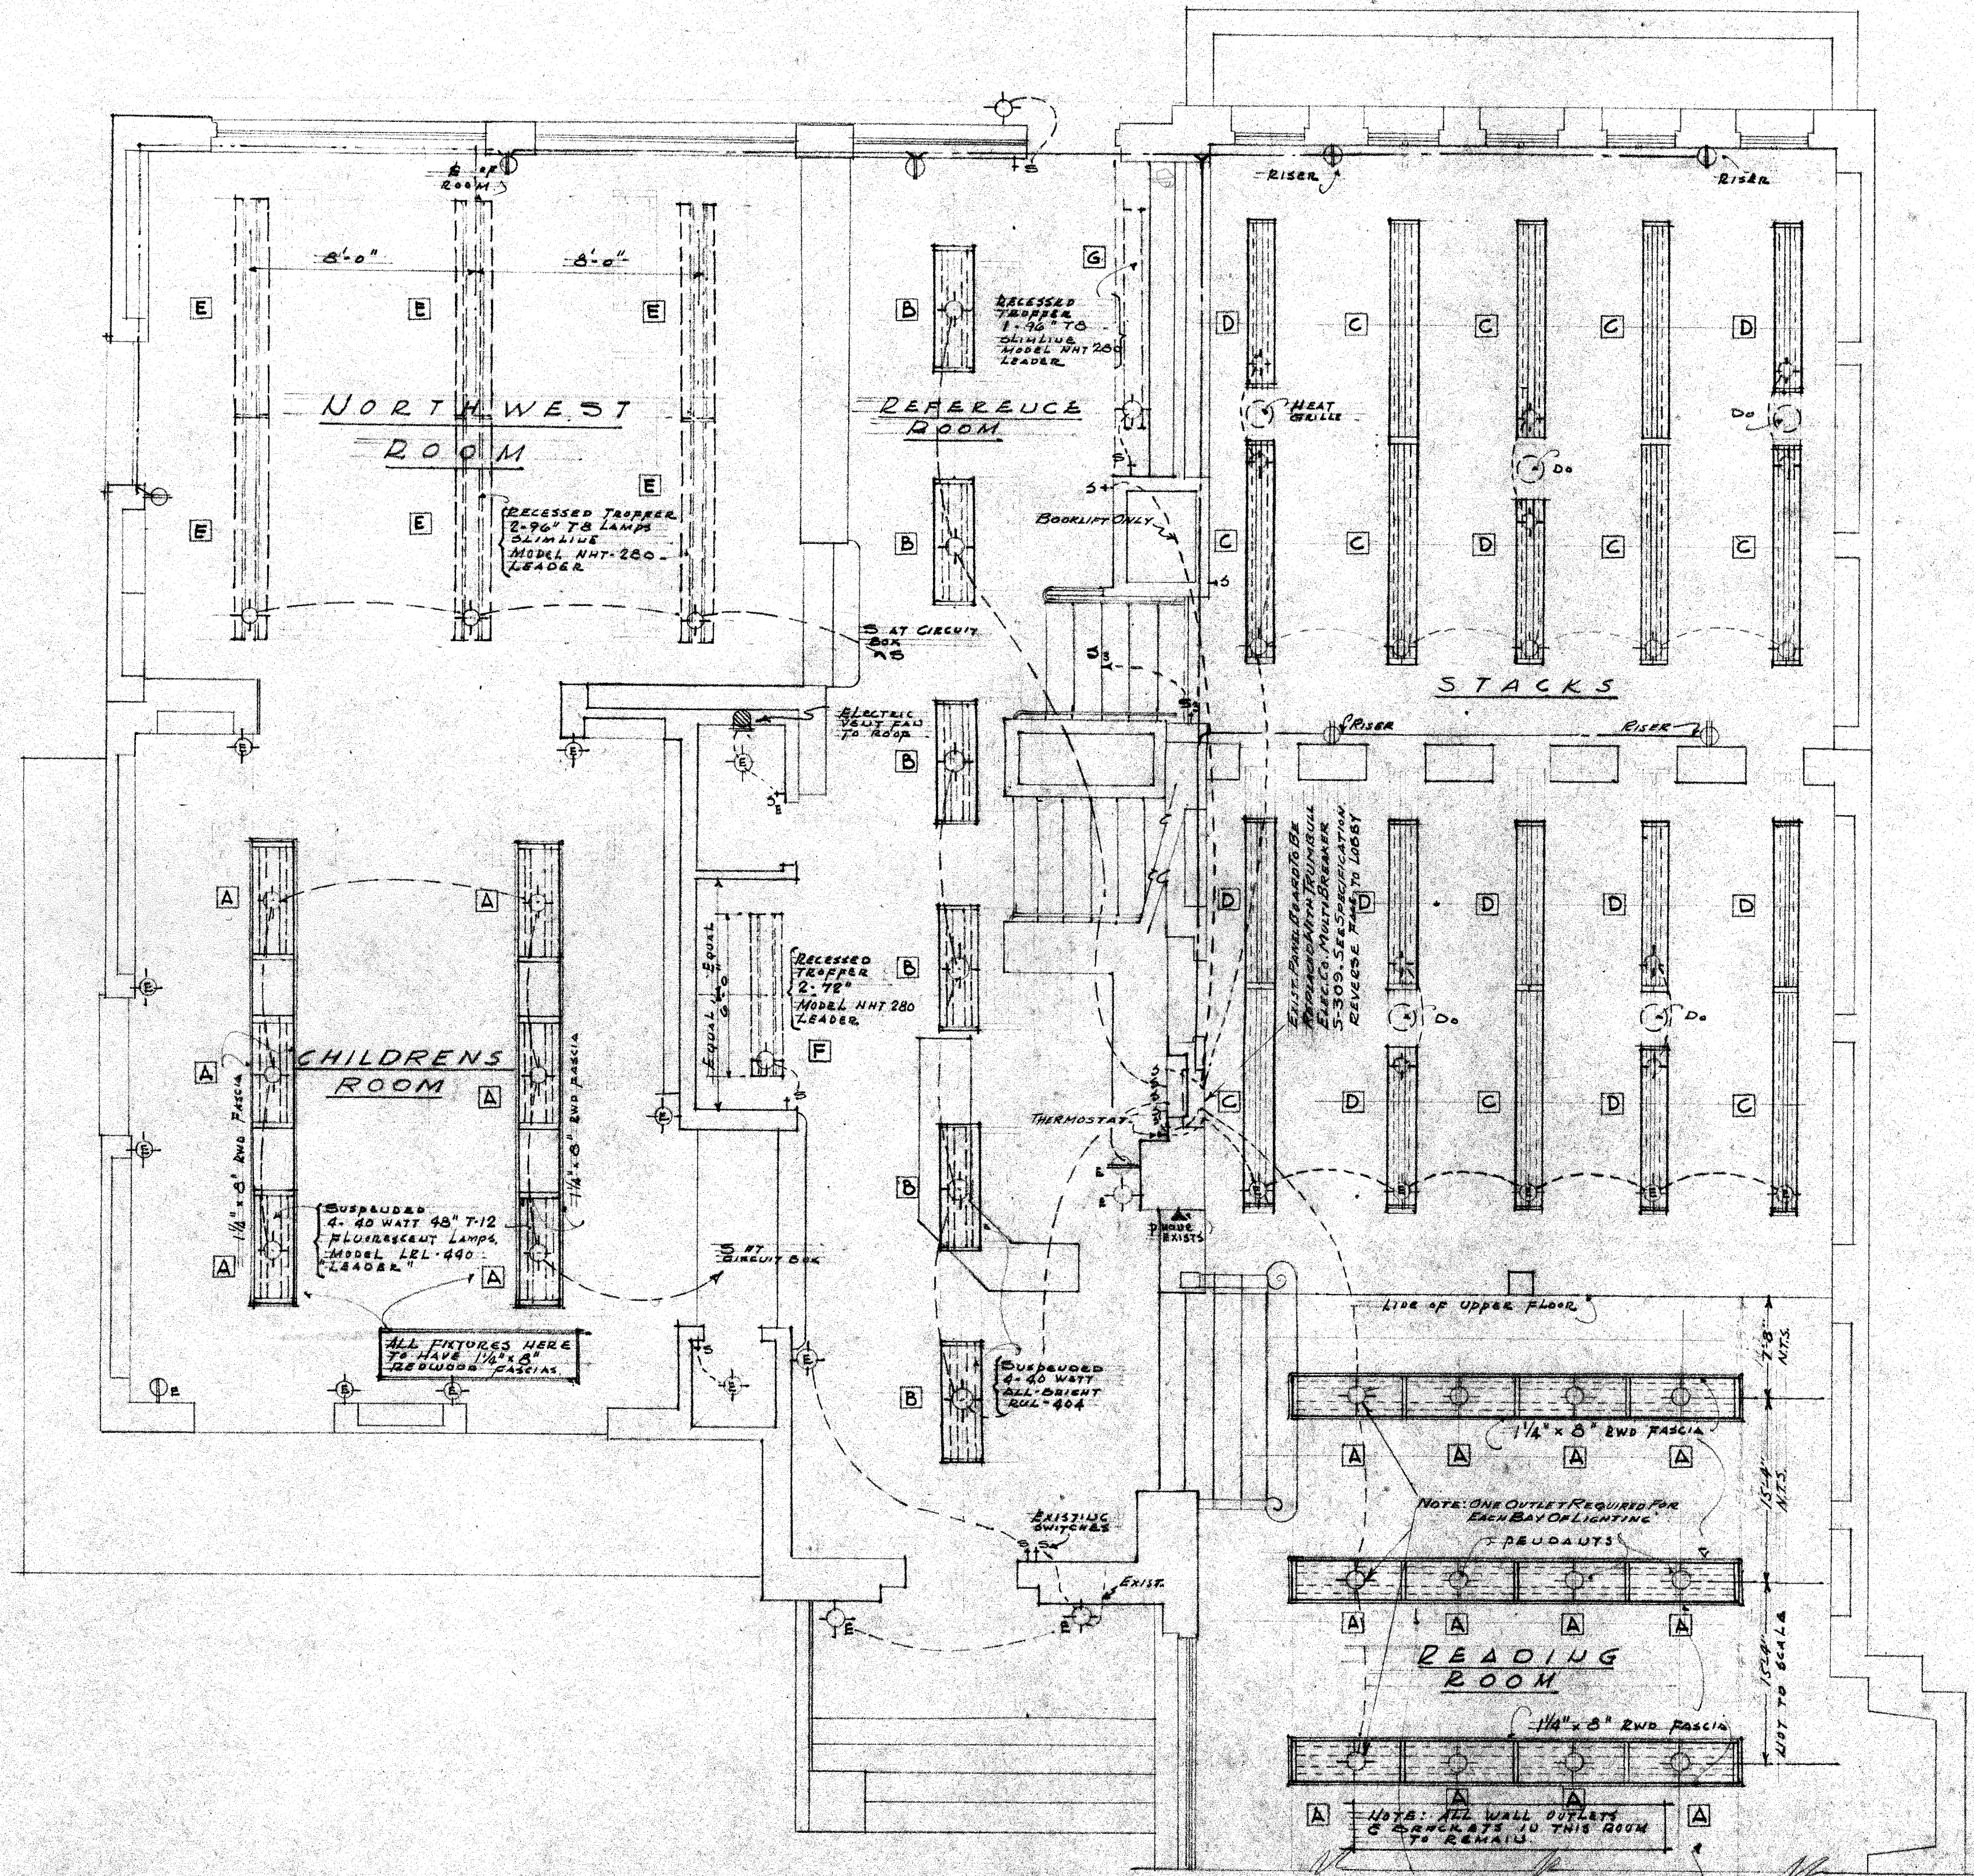


MAIN FLOOR PLAN
SCALE 1/4" = 1'-0"


UPPER FLOOR PLAN
SCALE 1/4" = 1'-0"

6	WIRING & LIGHTING LAYOUT	ISS NO
5	HARRISON MEMORIAL LIBRARY	4820
4	CARMEL CALIF.	DRAWN BY
3		D.M.M.
2	ROBERT R. JONES, ARCHITECT	CHK. BY
1	BOX 927 - CARMEL, CALIFORNIA - PHONE 347	N.T.
		SHEET
		E-2
		OF 2
Date	By	Rev.
7/29/49		


J.M.

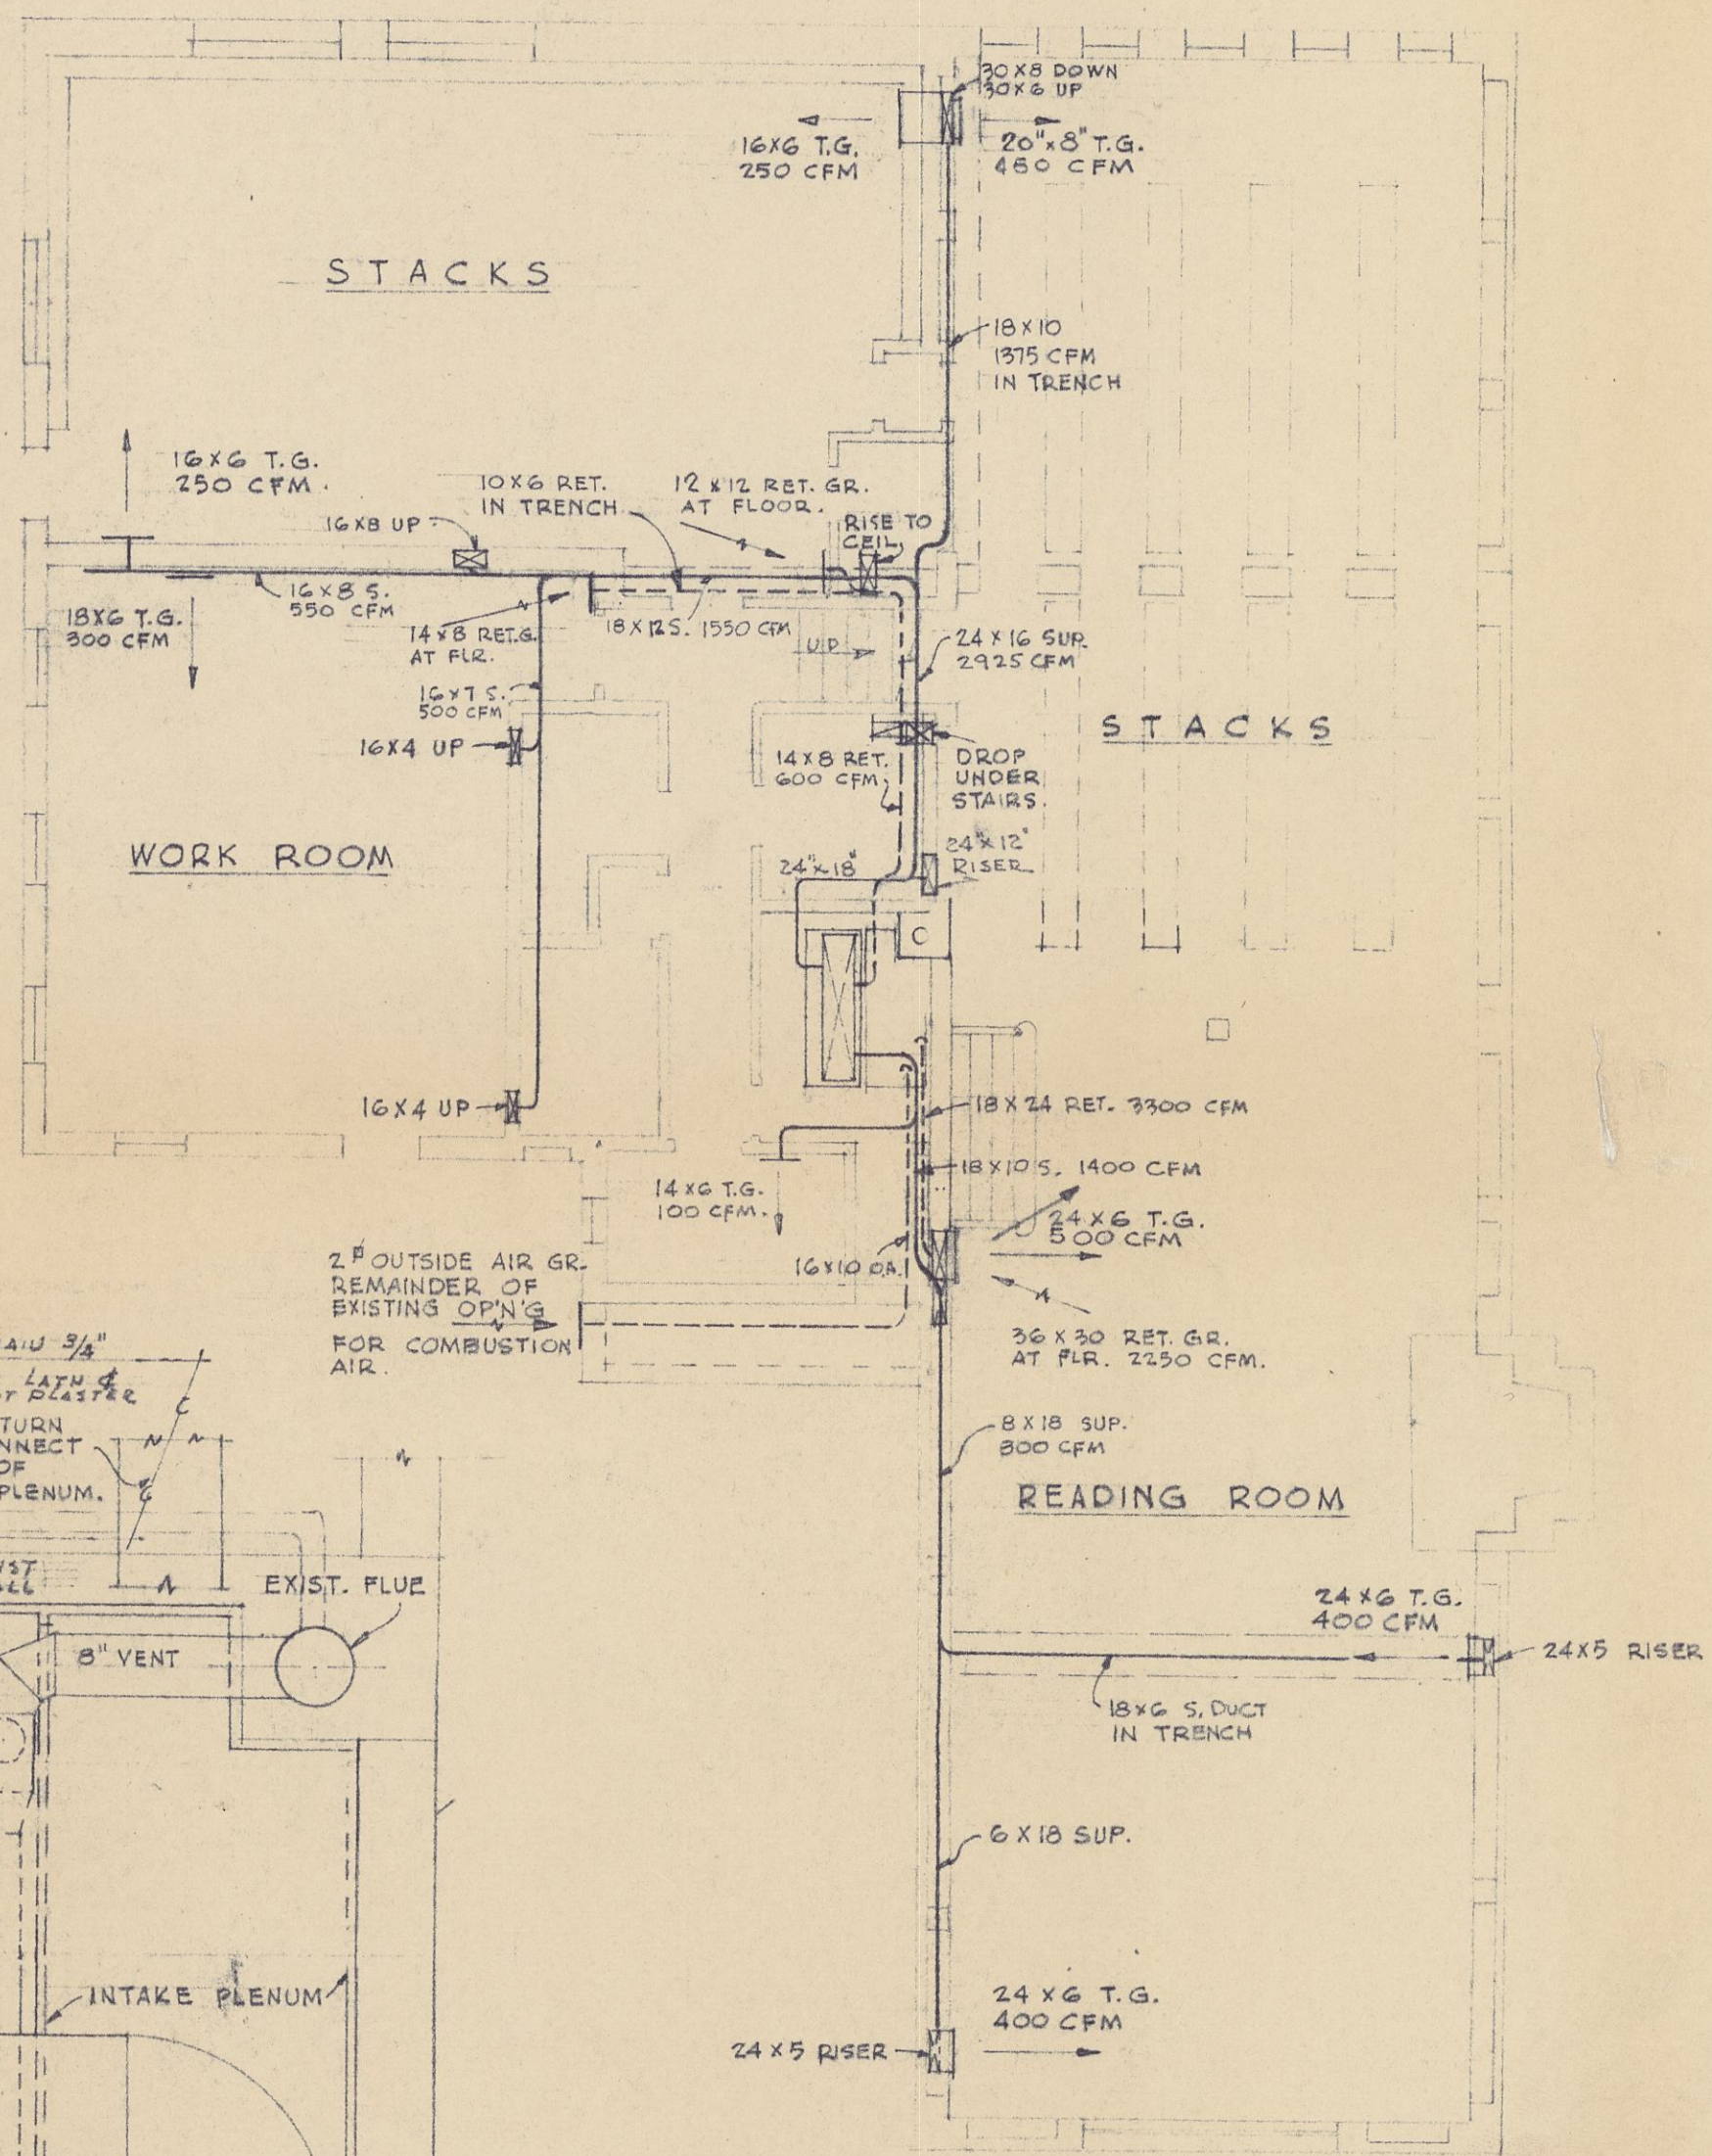


BASEMENT & FIRST FLOOR PLAN
SCALE 1/8" = 1'0"

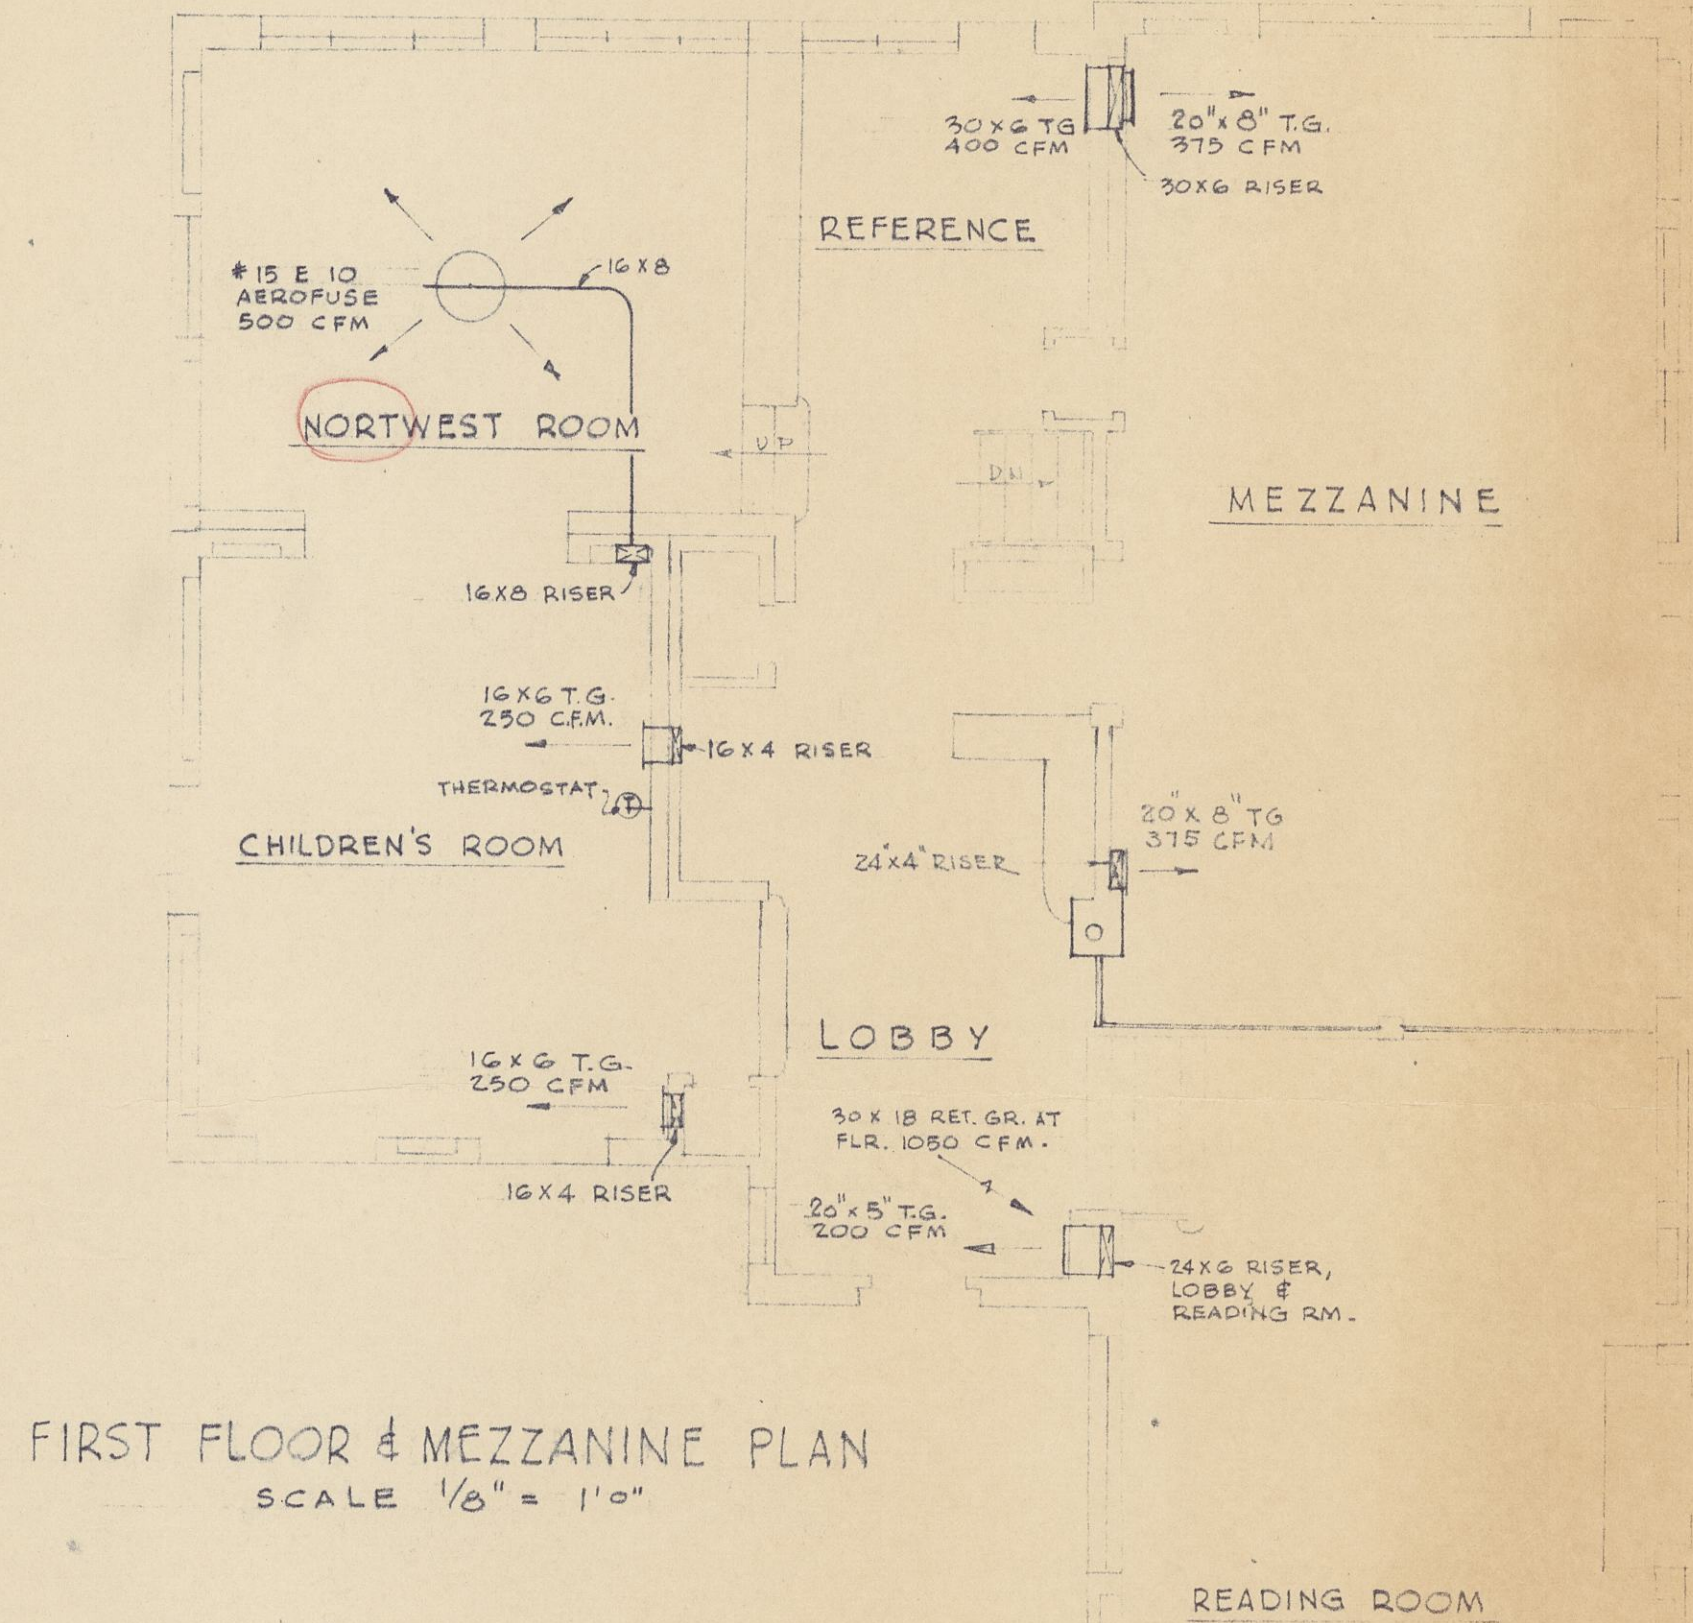

FIRST FLOOR & MEZZANINE PLAN
SCALE 1/8" = 1'0"

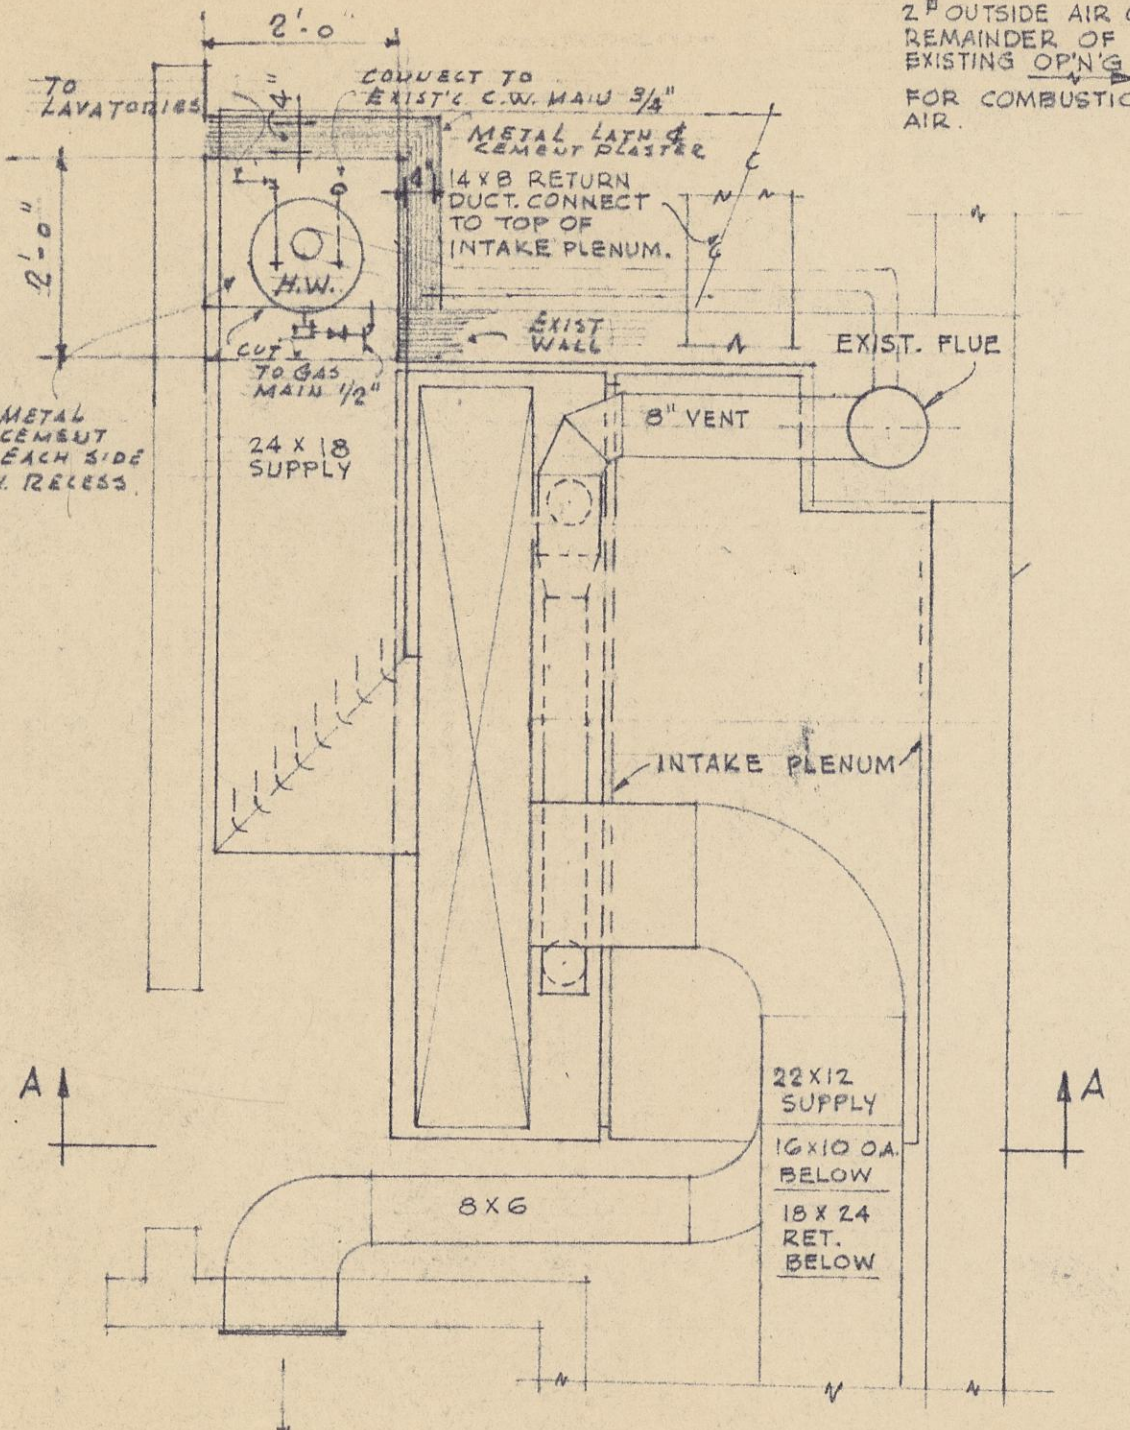

FURNACE ROOM PLAN
SCALE 1/2" = 1'0"

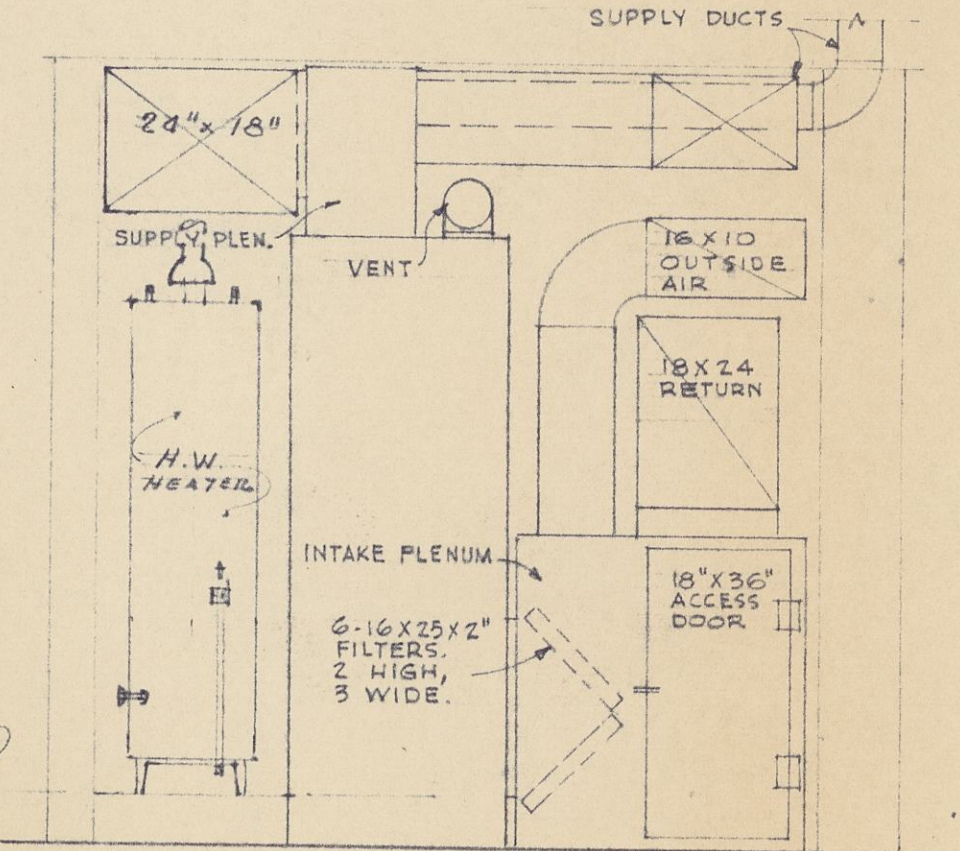

SECTION A-A
SCALE 1/2" = 1'0"

*Revised
Sheet
9a*

- NOTES.
- DAMPERS ARE NOT INDICATED. INSTALL VOLUME CONTROL DAMPERS WITH LOCKING TYPE QUADRANTS IN MAIN SUPPLY DUCTS IN ALL BRANCH DUCTS AND ALL OTHER LOCATIONS NECESSARY TO BALANCE SYSTEM. MAKE DAMPERS ACCESSIBLE.
 - INSTALL SUPPLY GRILLES APPROXIMATELY 3" ABOVE FLOOR IN ROOMS WITHOUT CEILING, AND 6" BELOW CEILING IN OTHER ROOMS.
 - TRENCHES: FINISHED INSIDE DIMENSION SHALL BE 2" GREATER (EACH WAY) THAN DUCT SIZE CALLED FOR.

NOTE: THIS DRAWING SUPERCEDES HEATING LAYOUT ONLY OF SHEET M-1.

NOTE: RELOCATION OF HOT WATER HEATER IN RECESS.

6	ALTERATIONS & ADDITIONS	4820
5	HARRISON MEMORIAL	
4	LIBRARY	
3	ROBERT R. JONES, ARCHITECT	RTS
2	BOX 927 - CARMEL, CALIFORNIA - FICHE 347	
1	HEATING PLAN	M-2
10/11/49	HTS	OK 2
10/6/49	HTS	

CLYDE E. BENTLEY
CONSULTING ENGINEER
374-17th ST., OAKLAND 12